




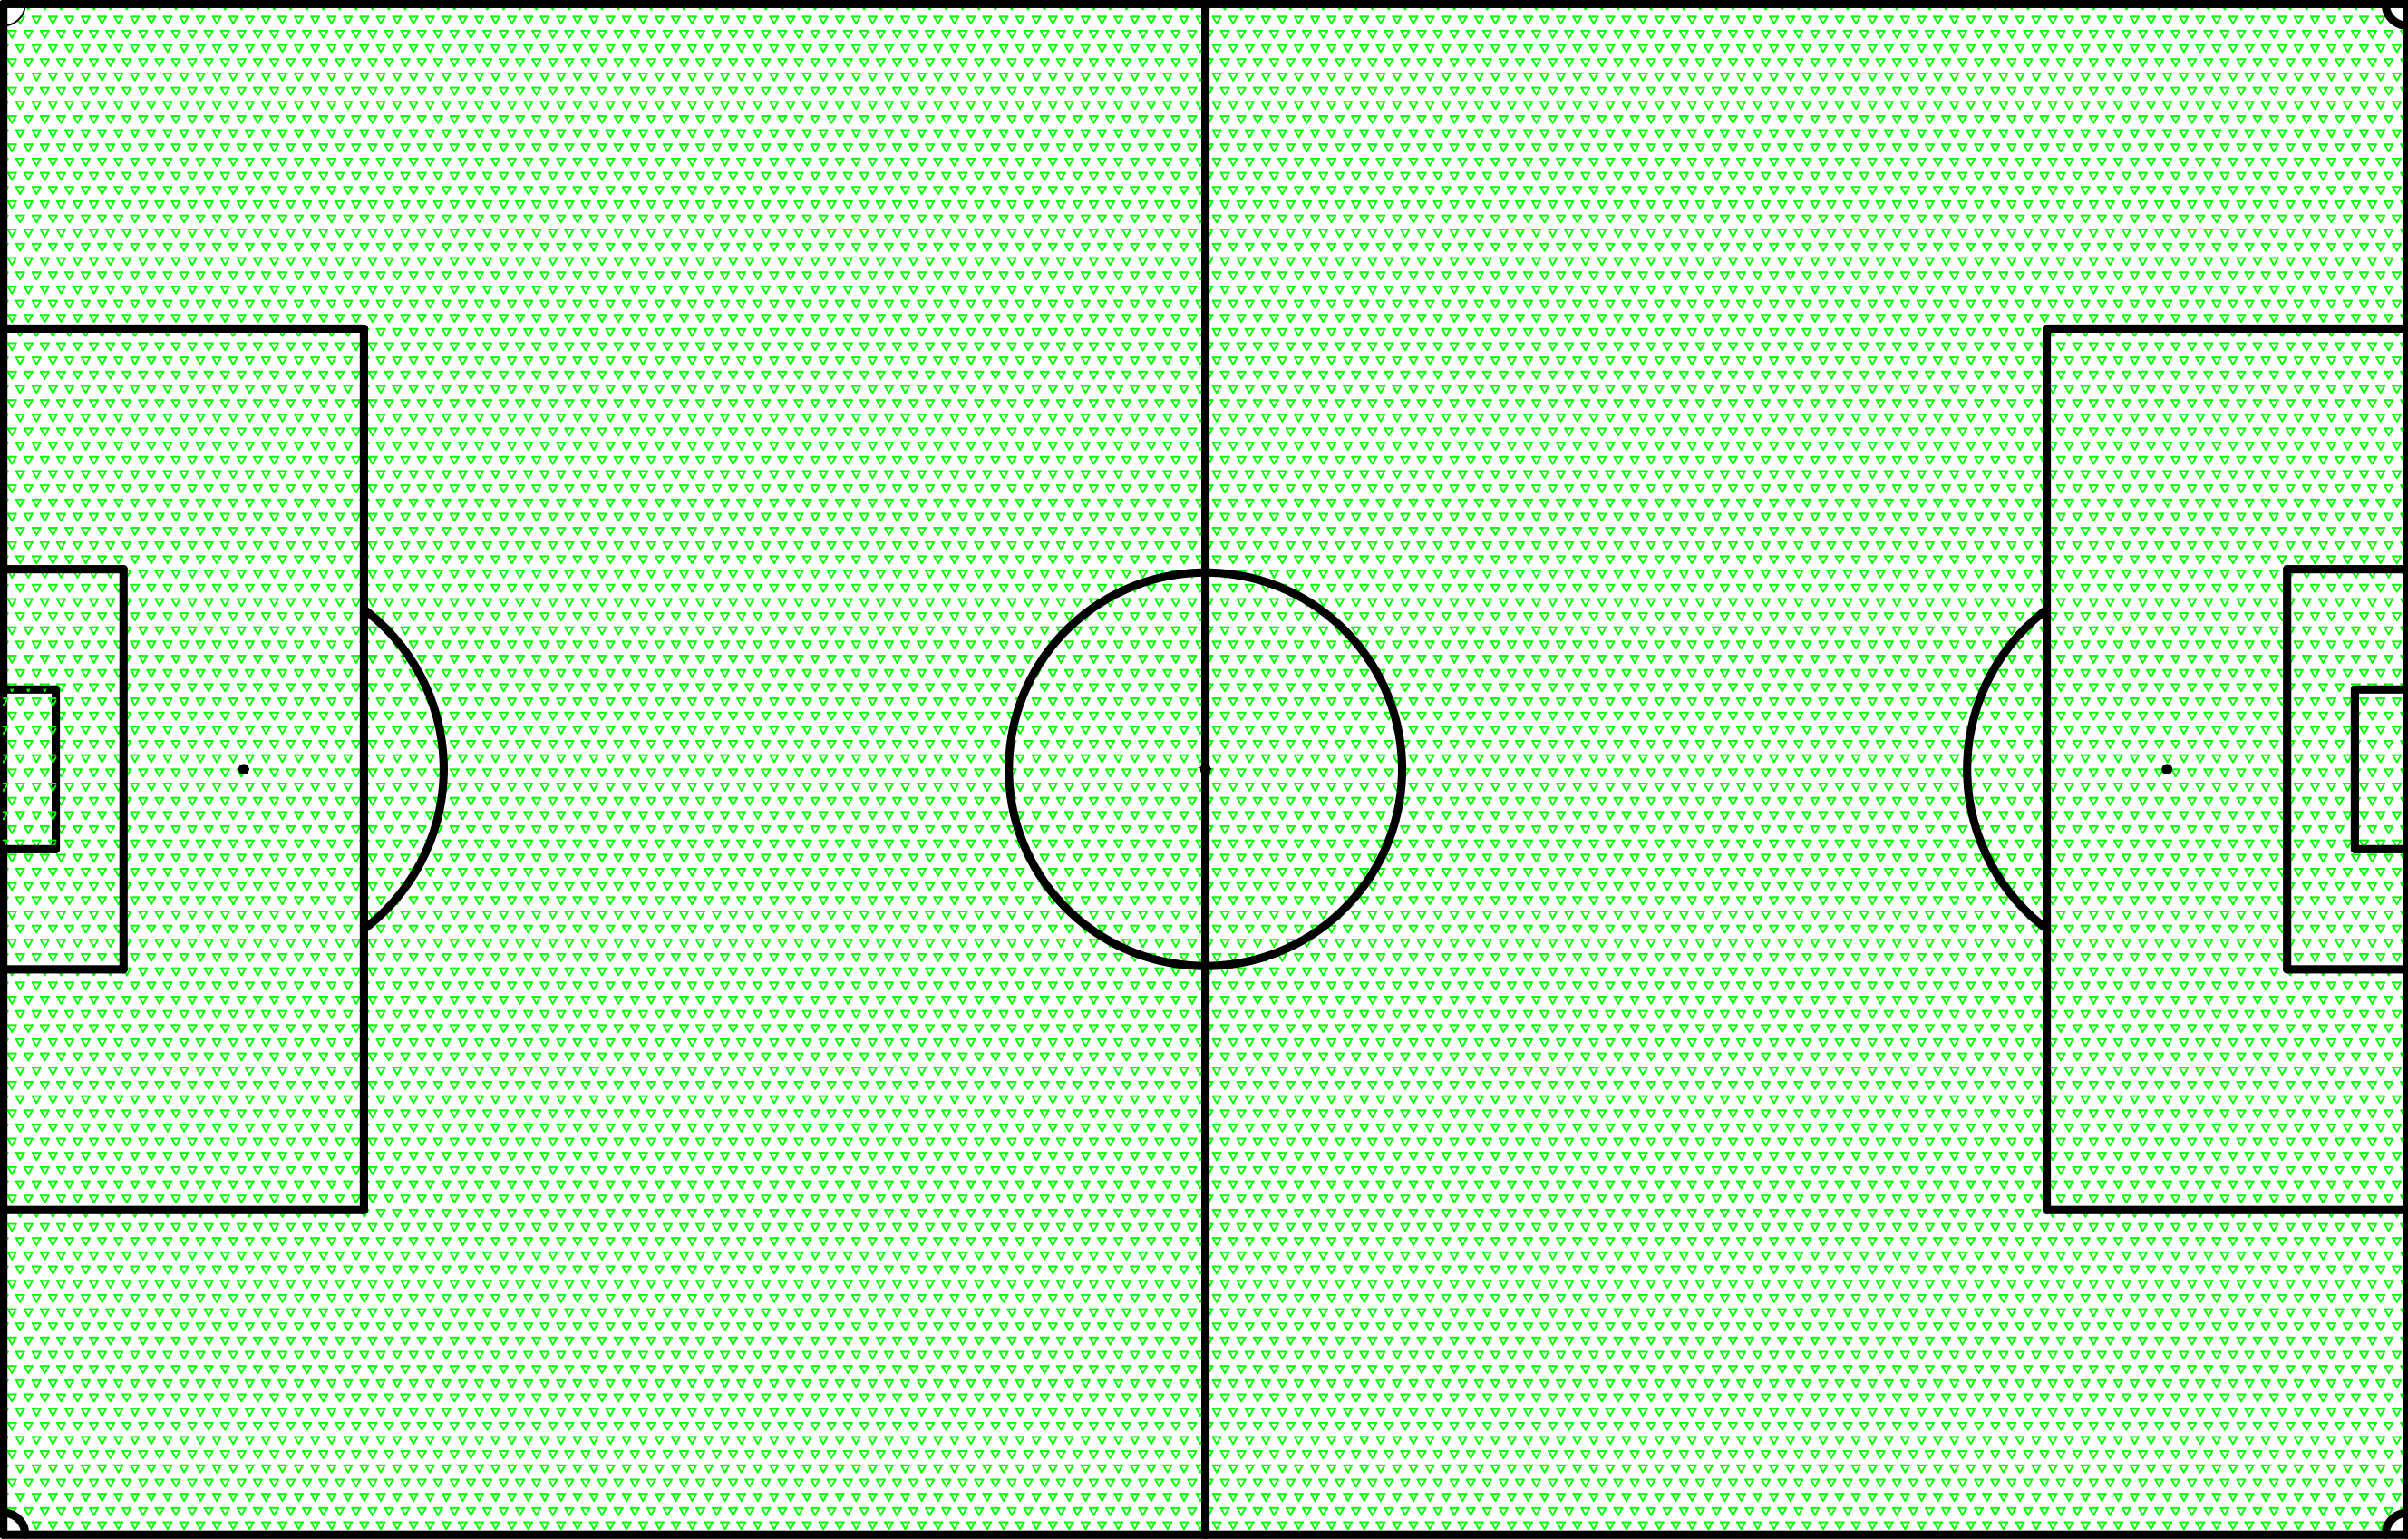


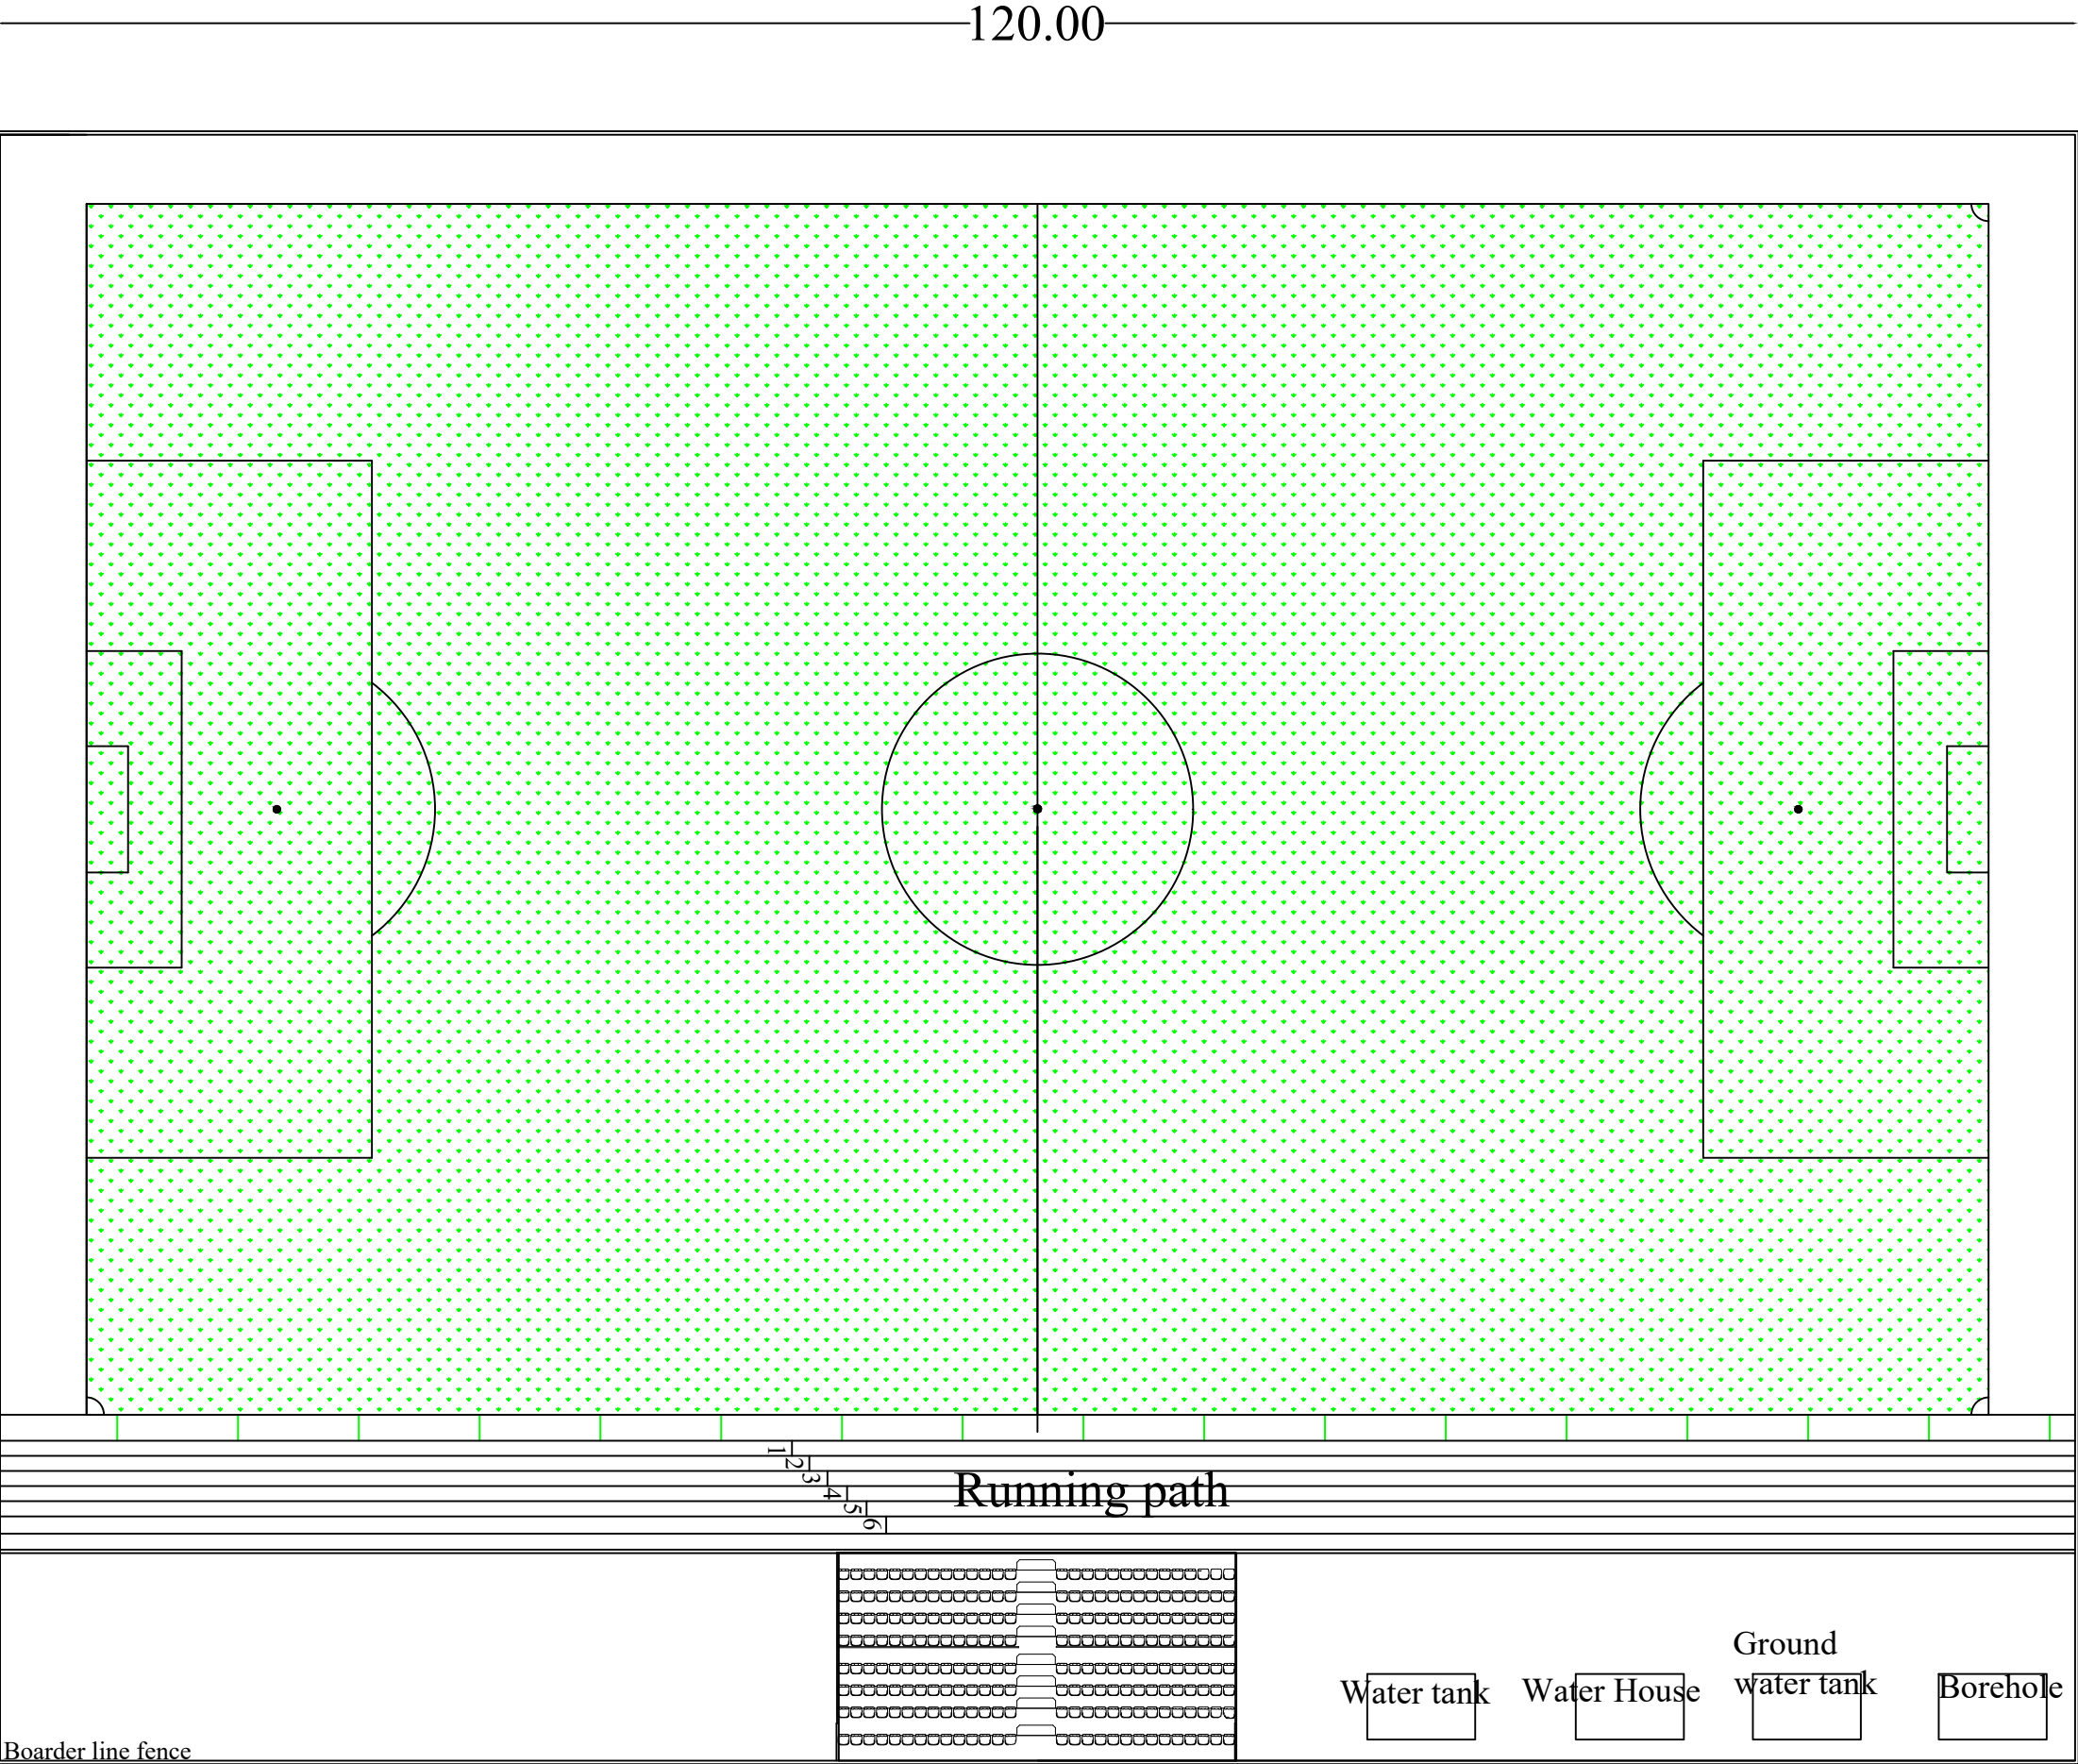

Site plan

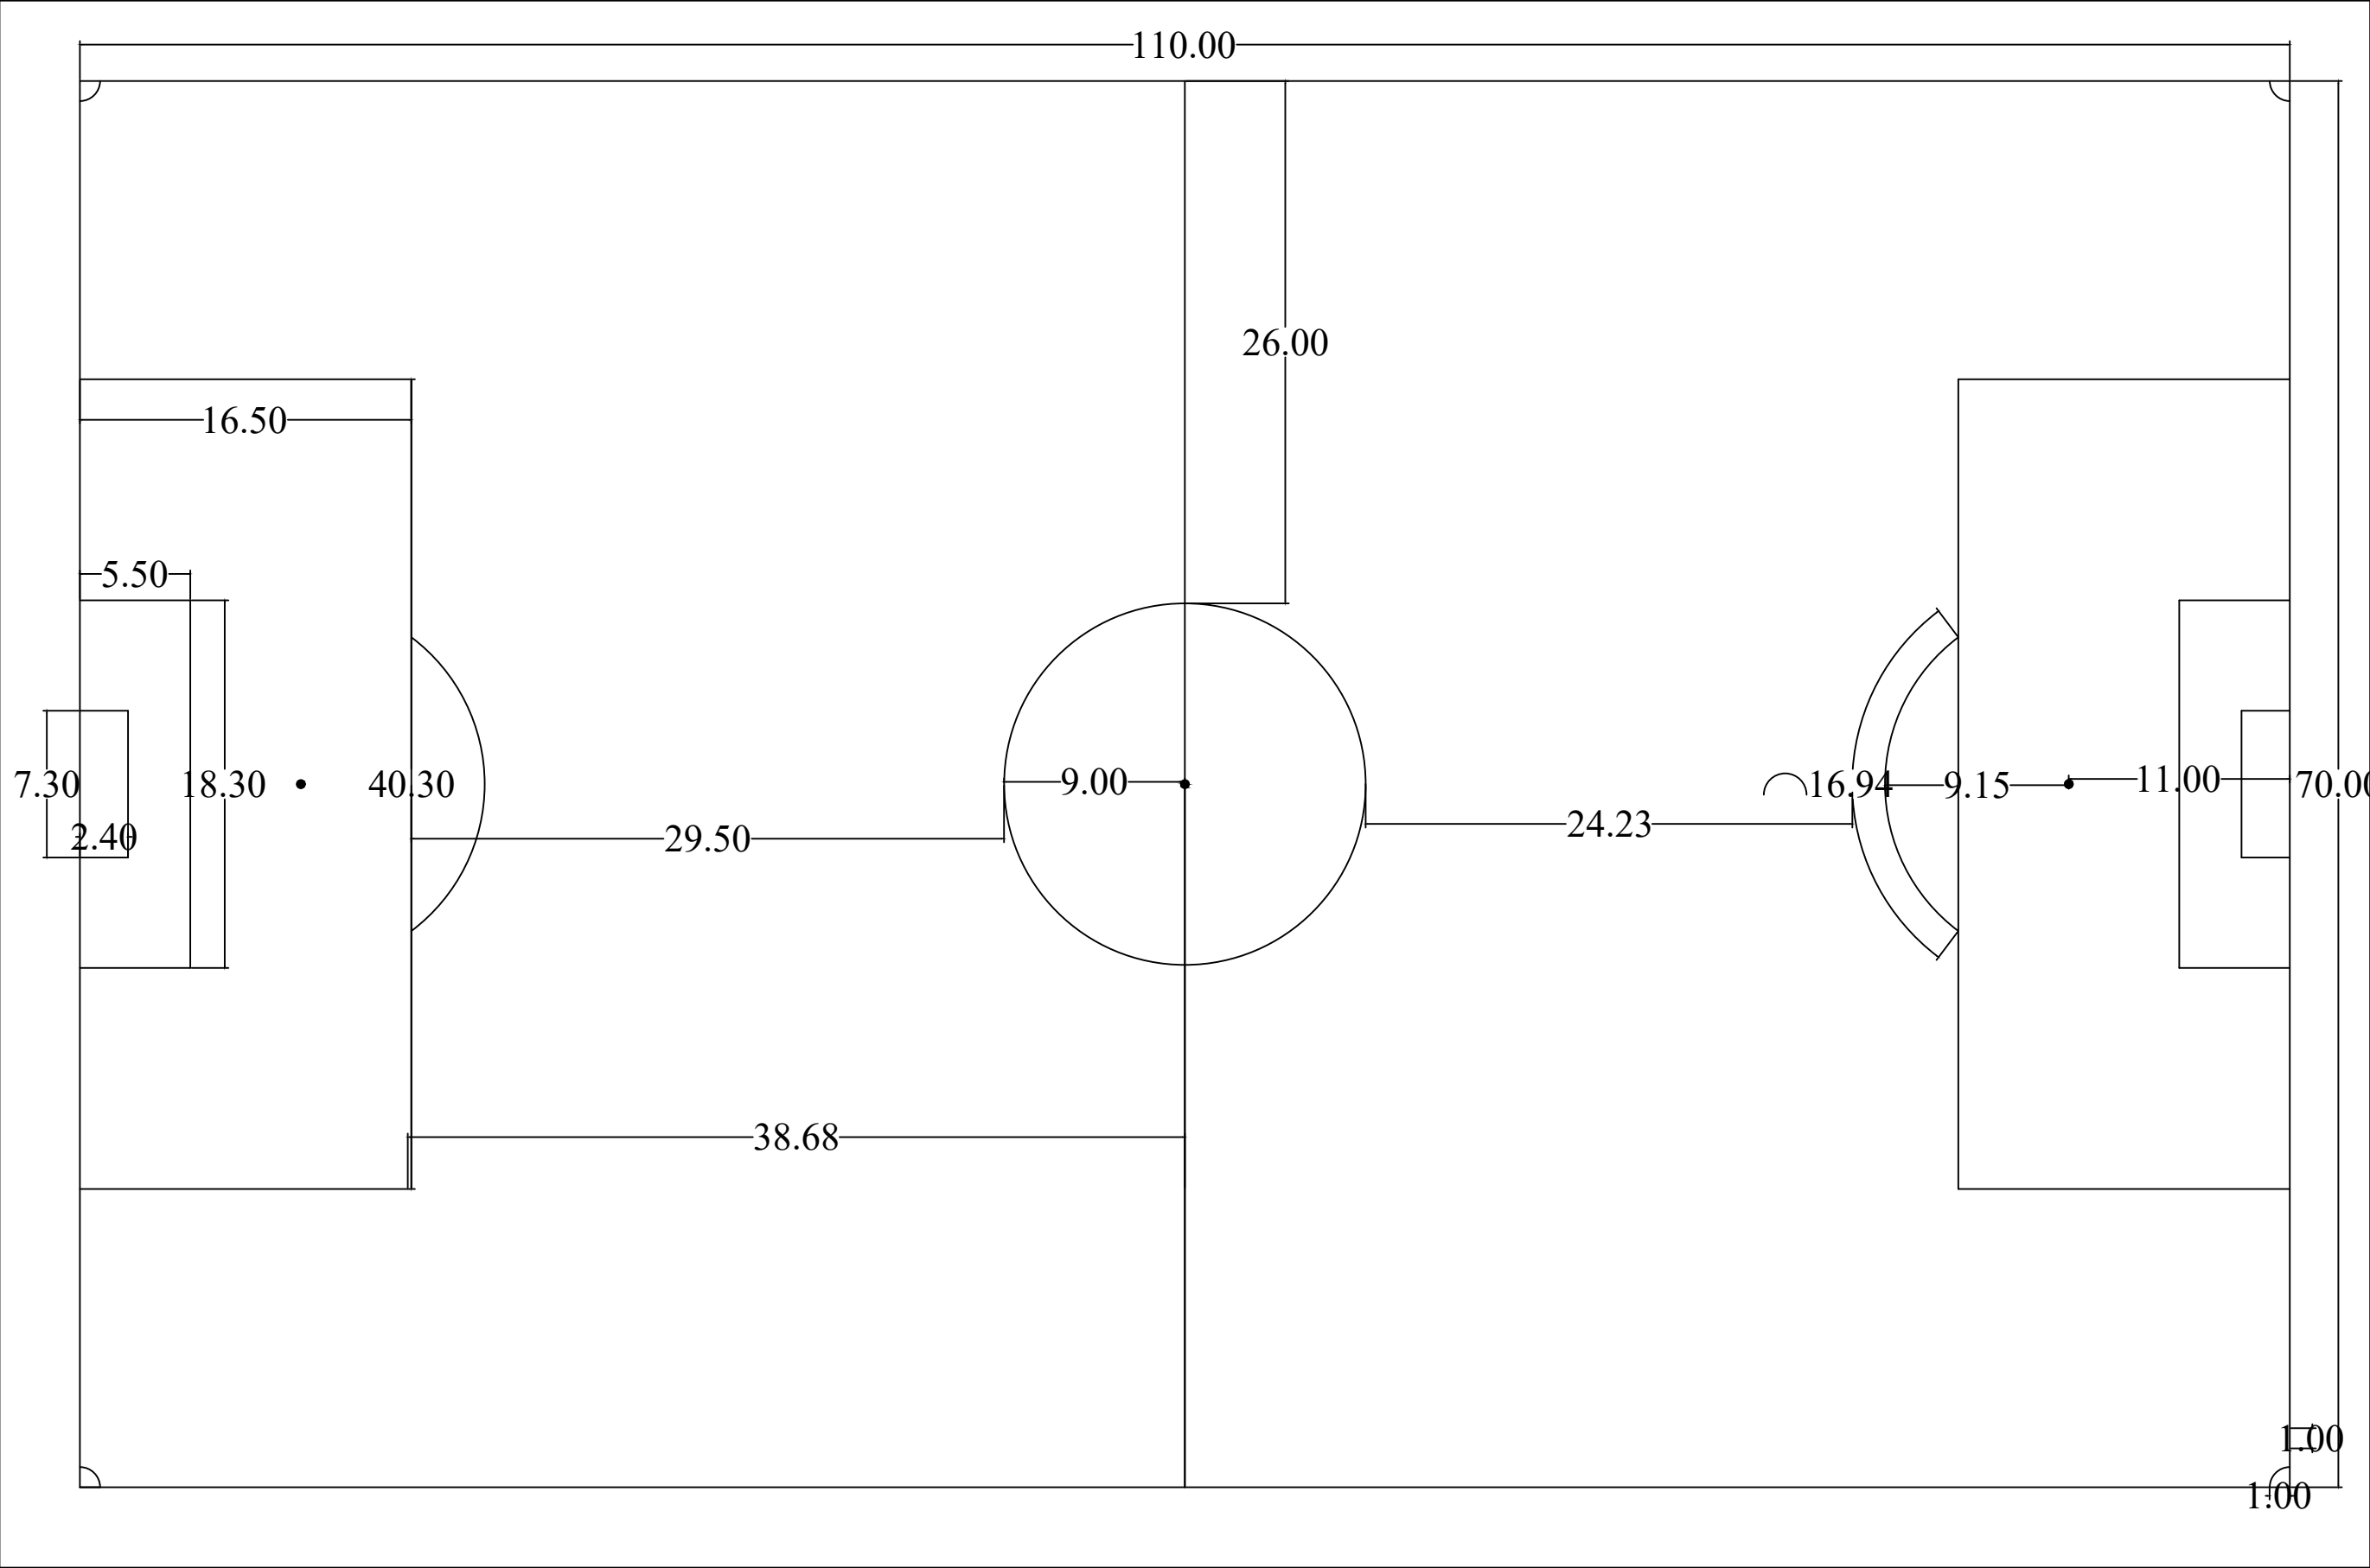


Play ground with dimension

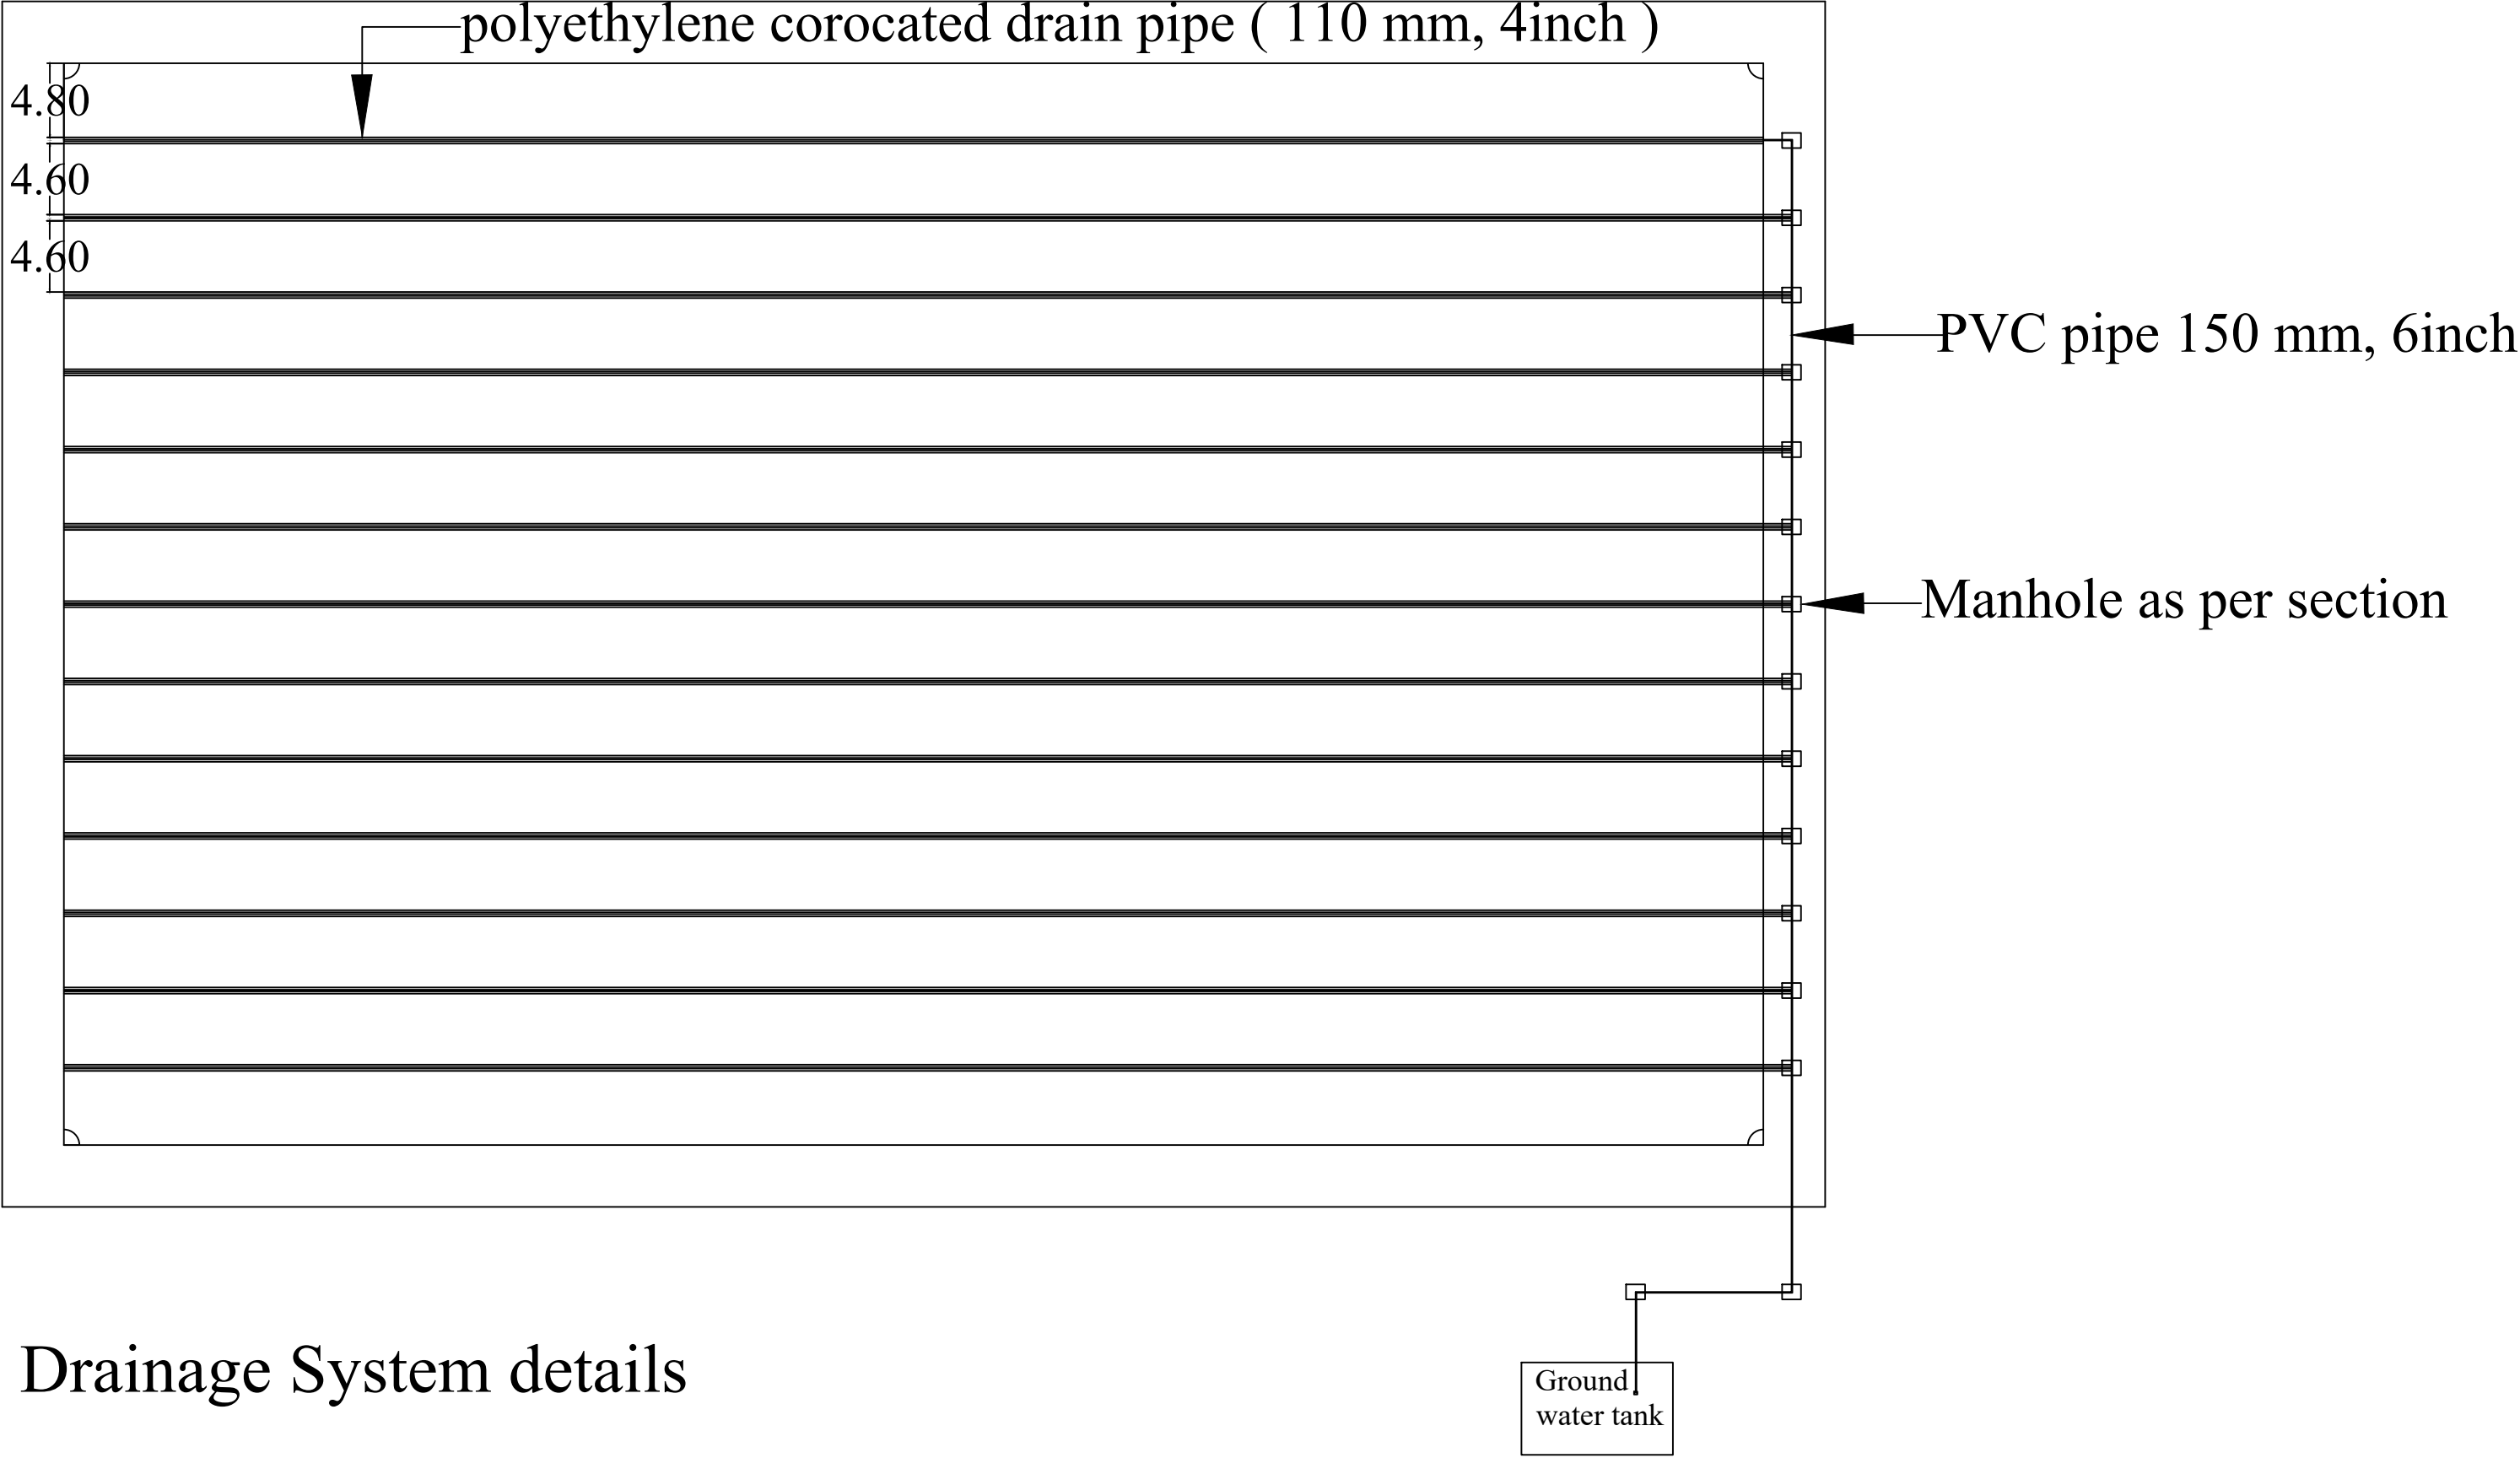


Drainage System details

Telsqof play ground



Trench section

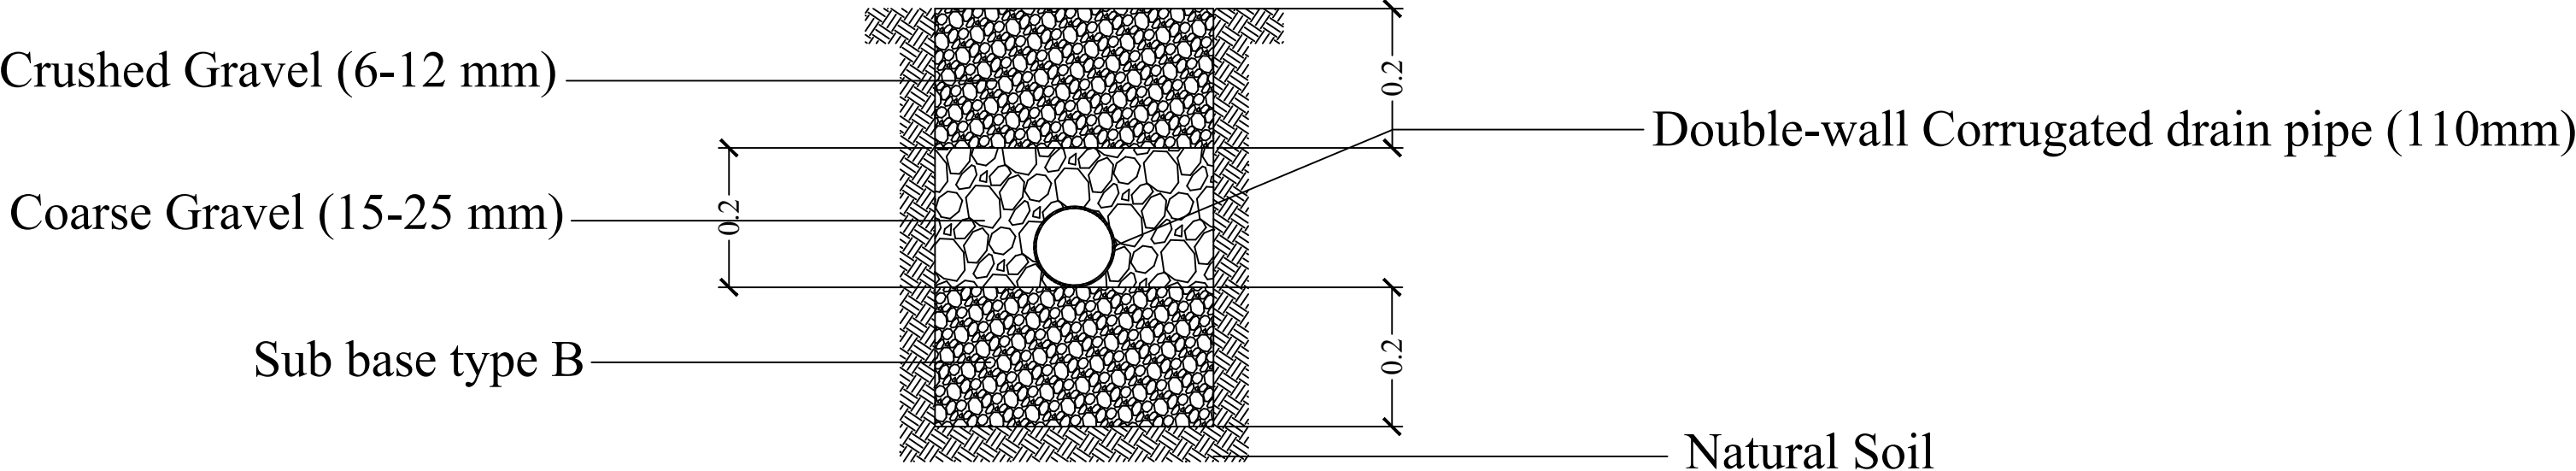


Trench Details

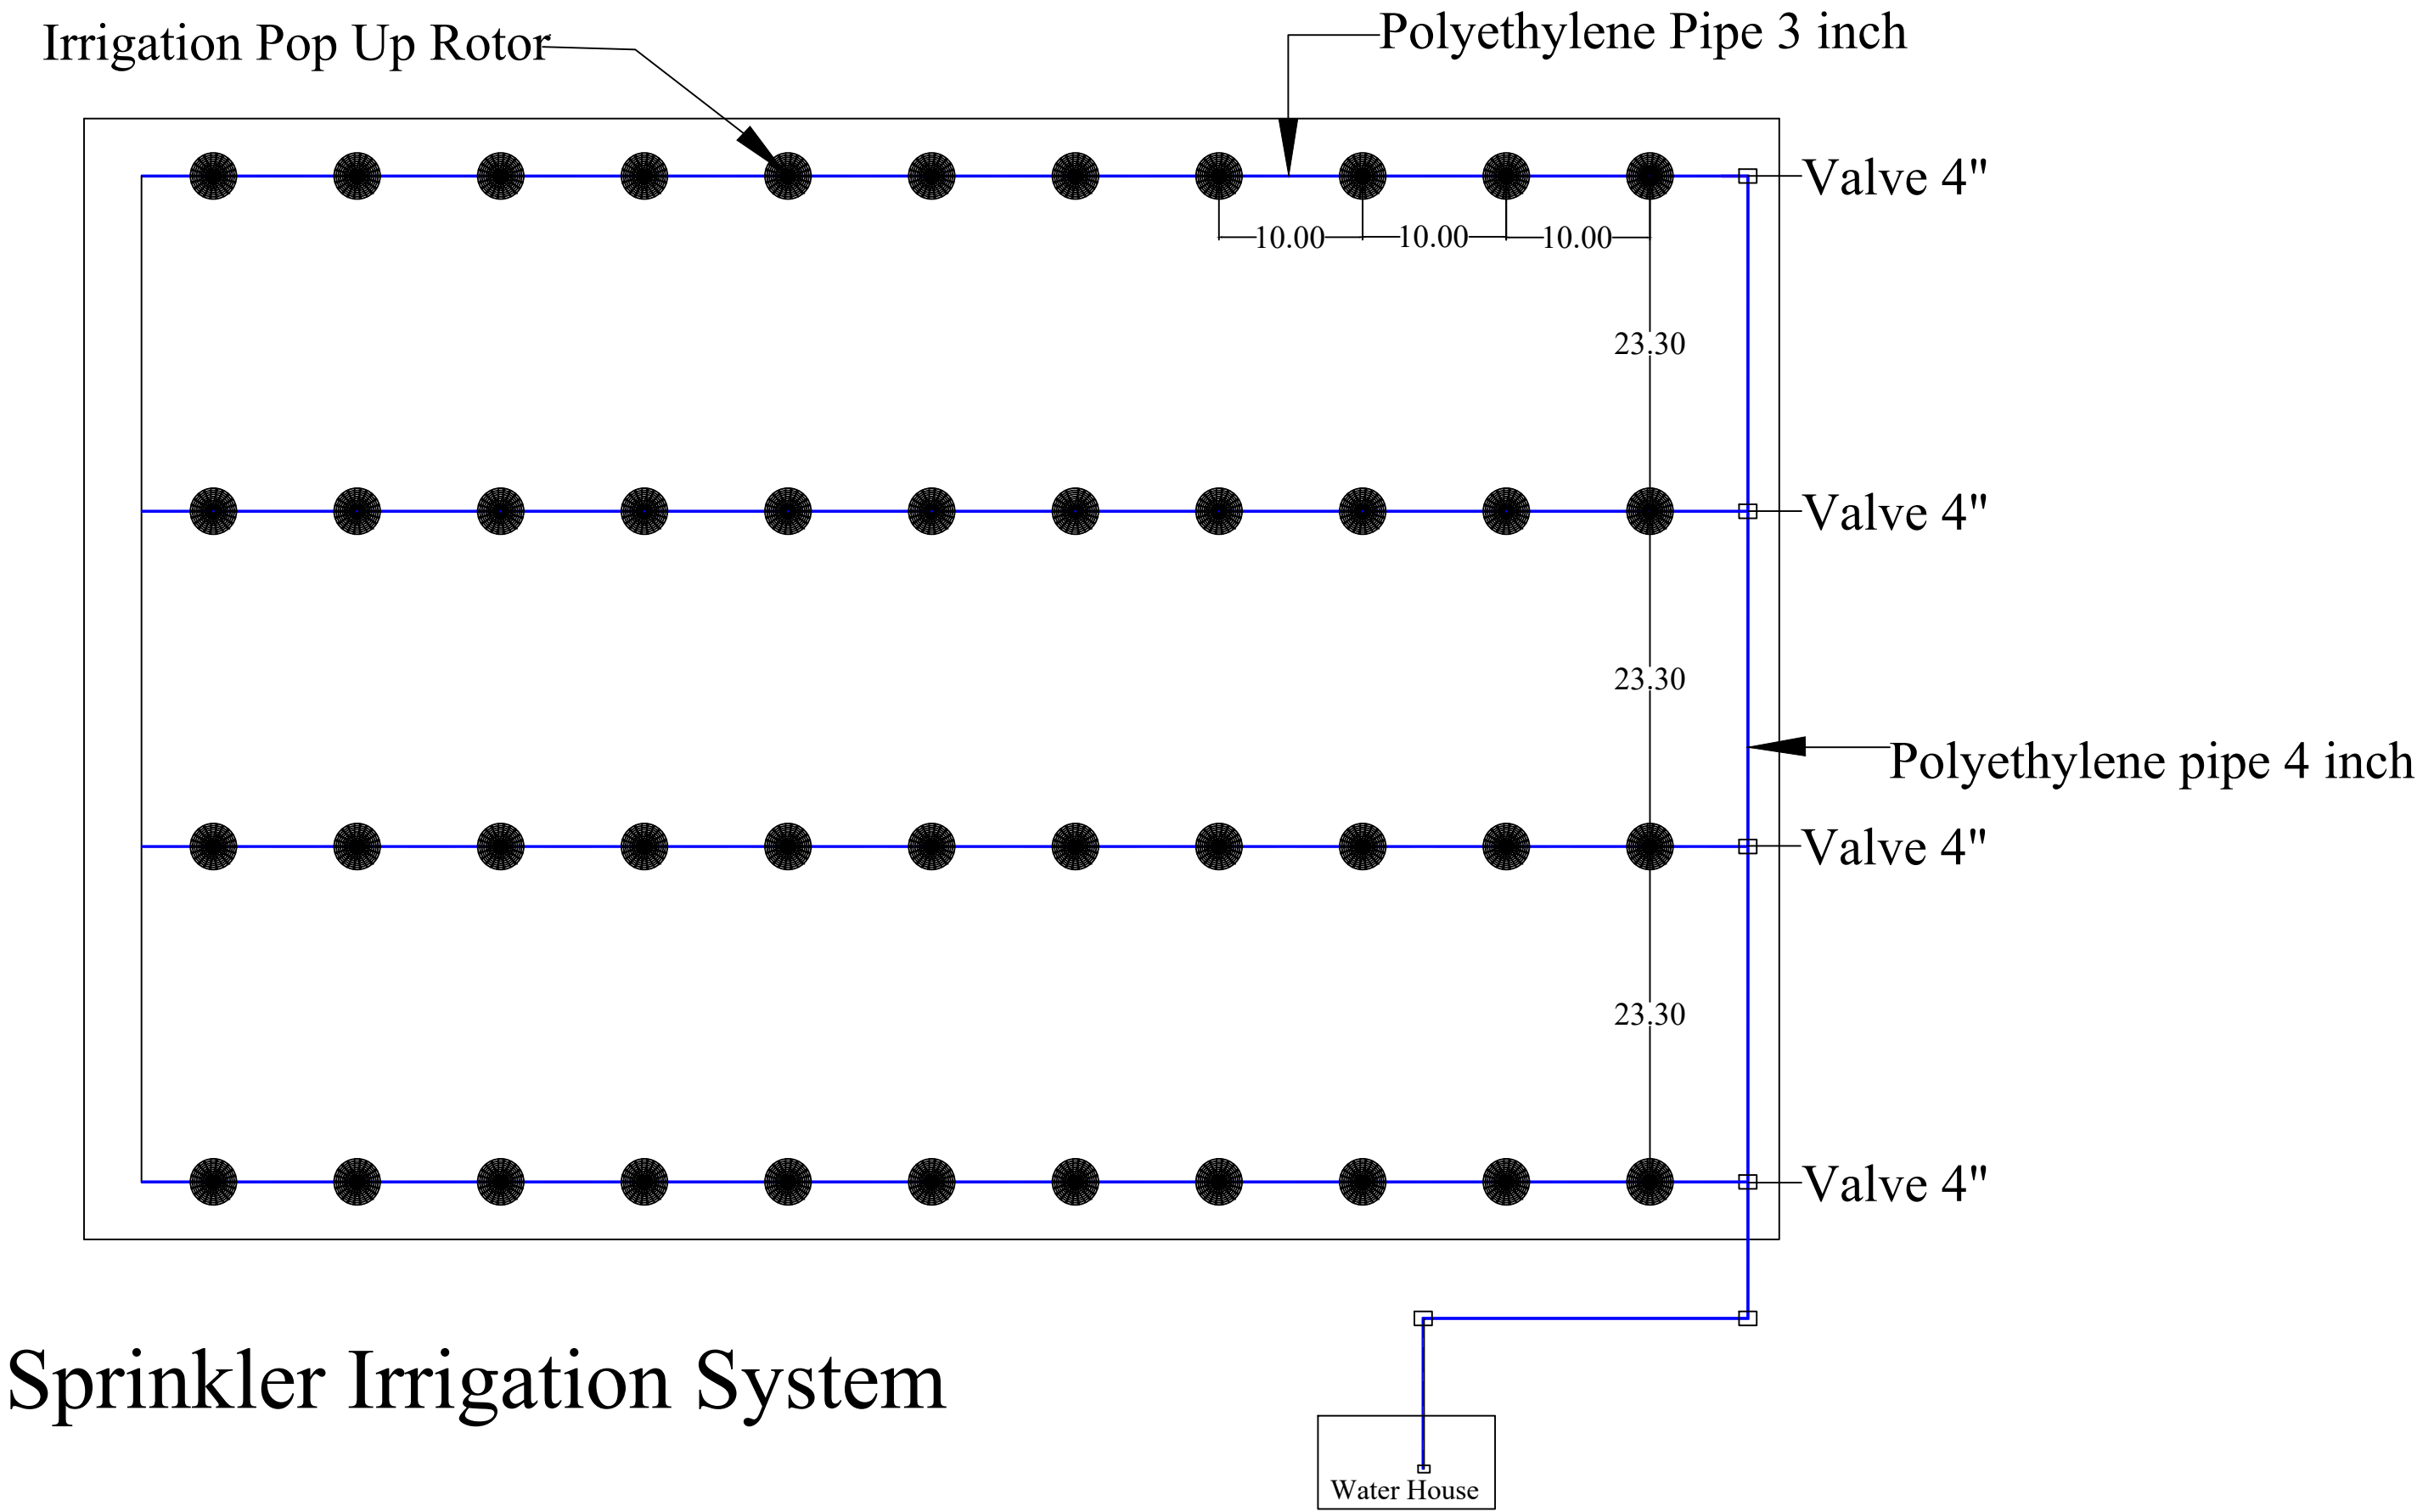


Sprinkler Irrigation System

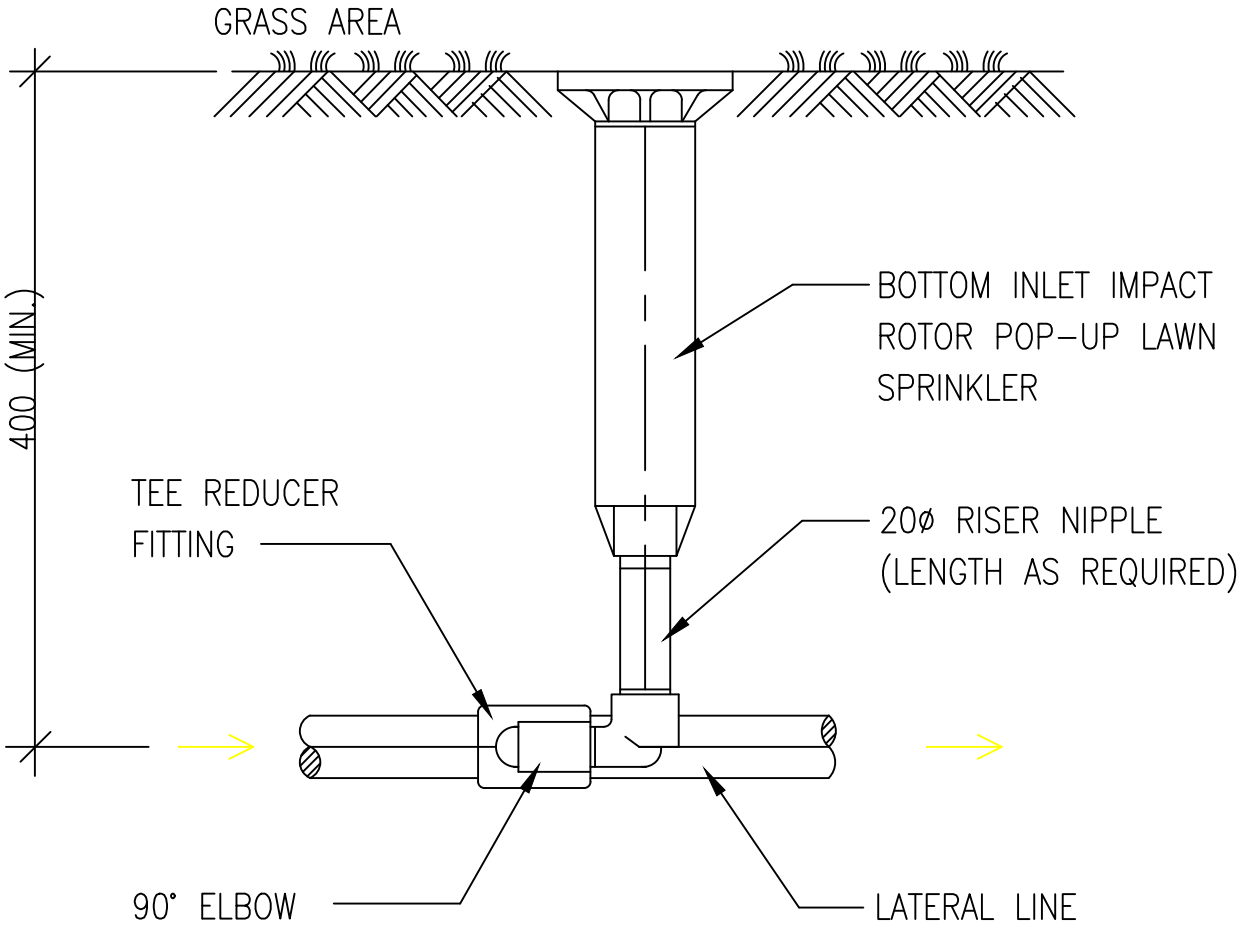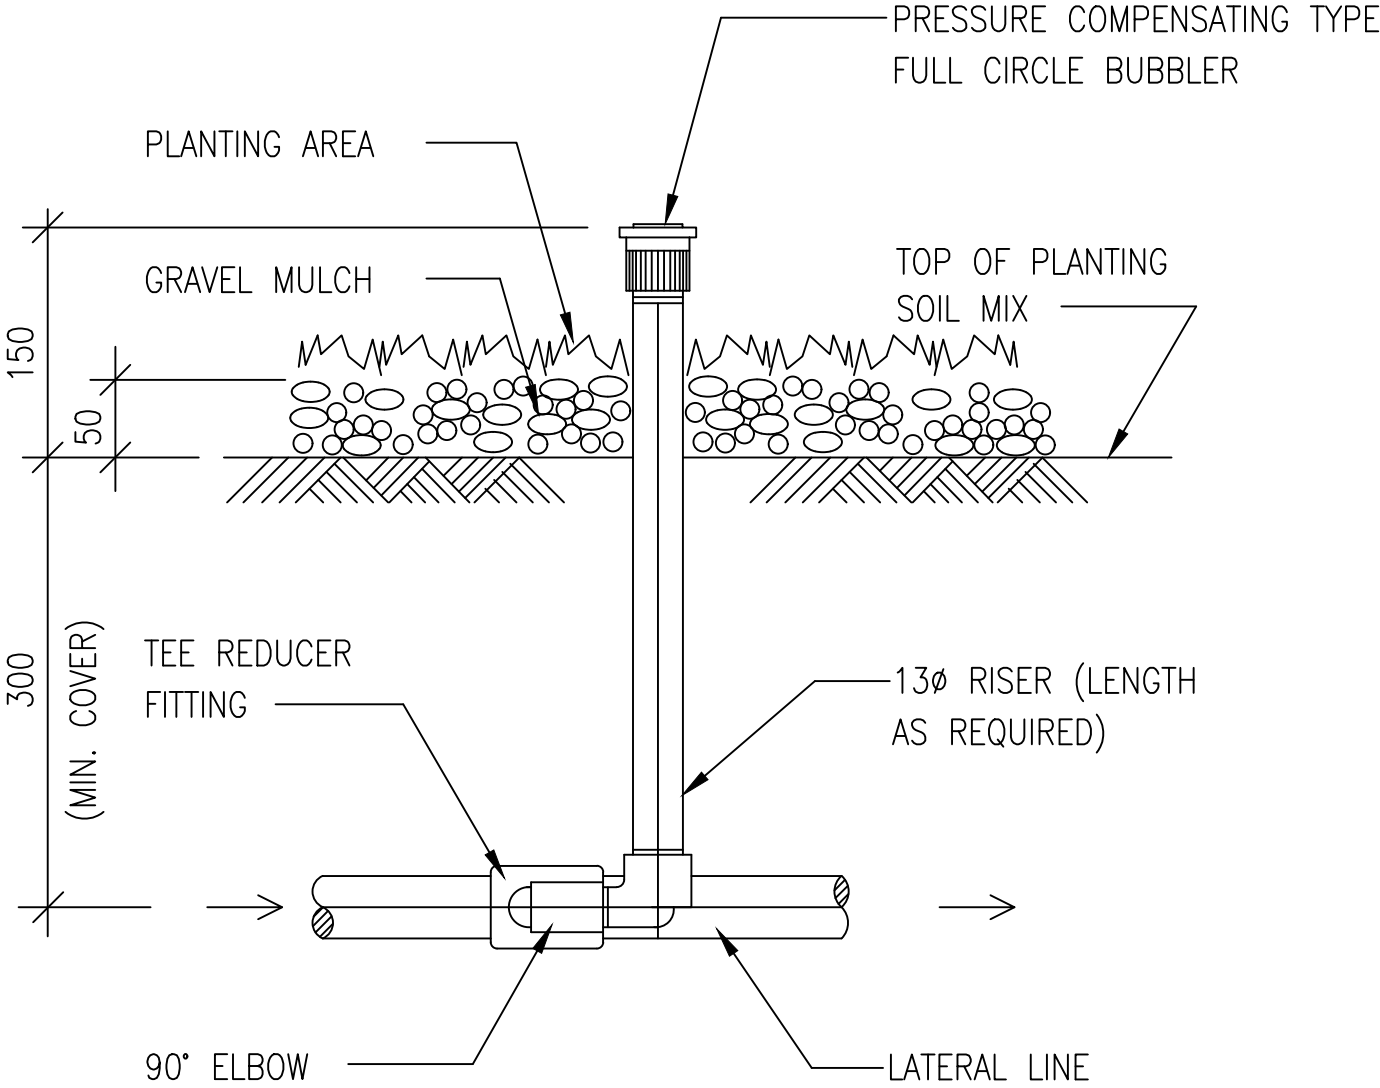


Irrigation rotor details

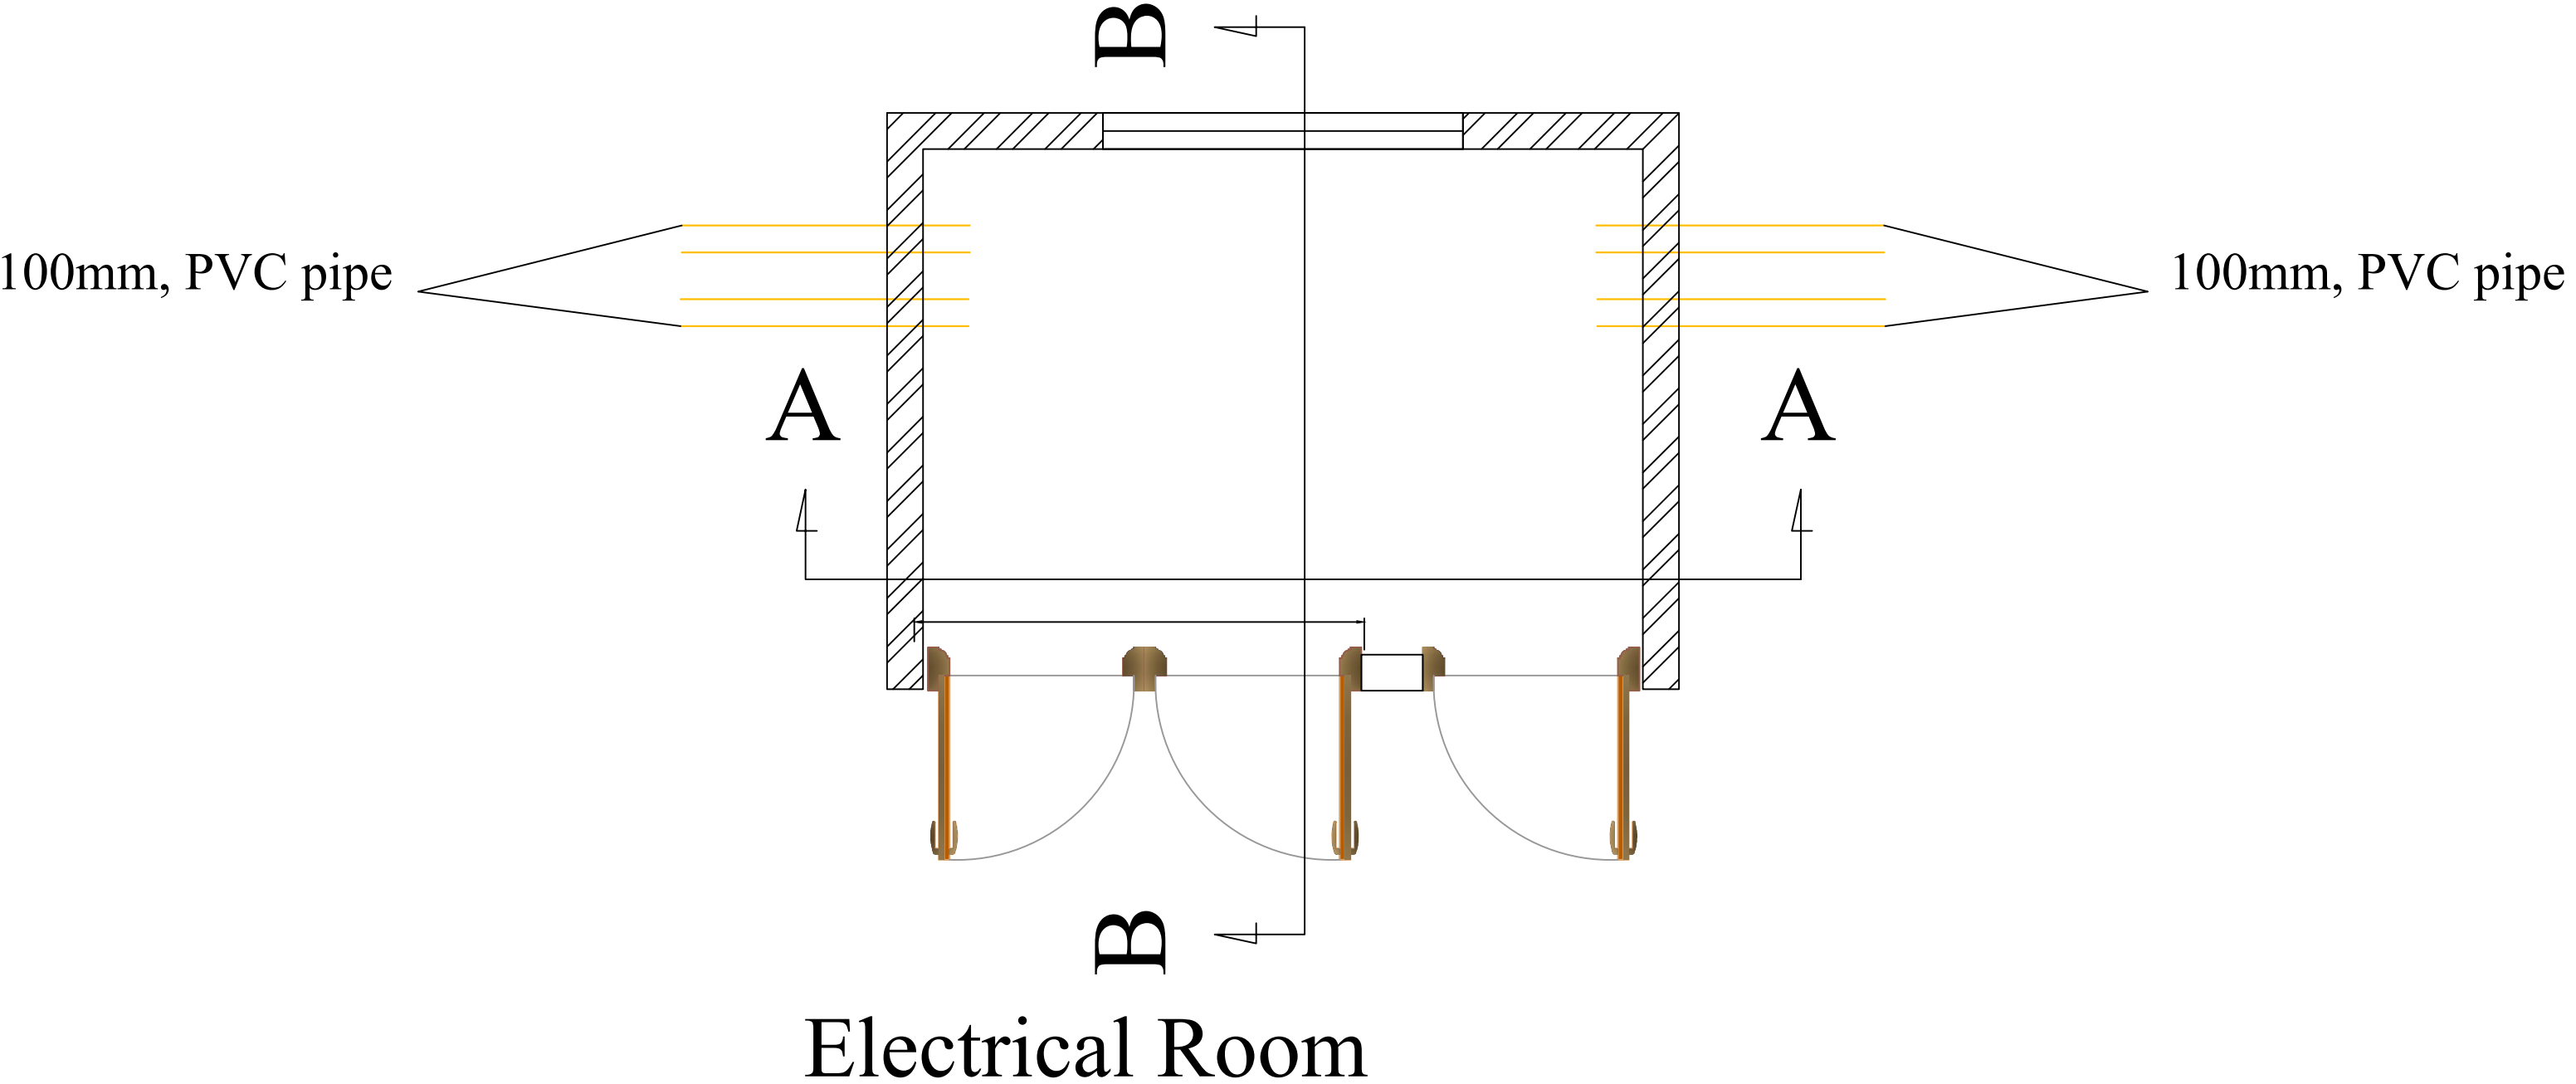

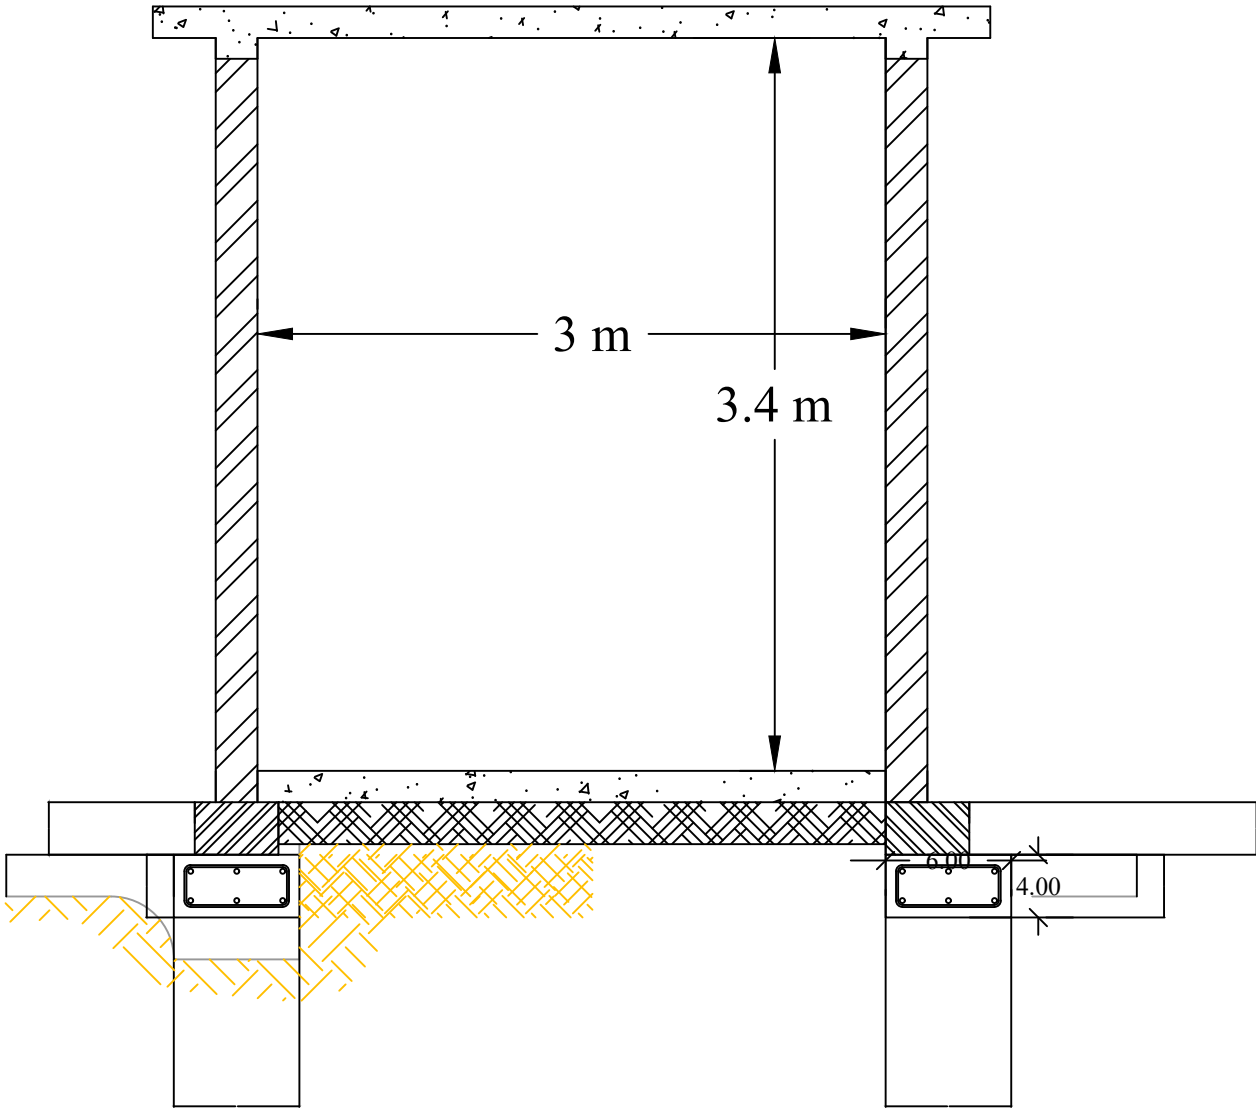


Section A-A

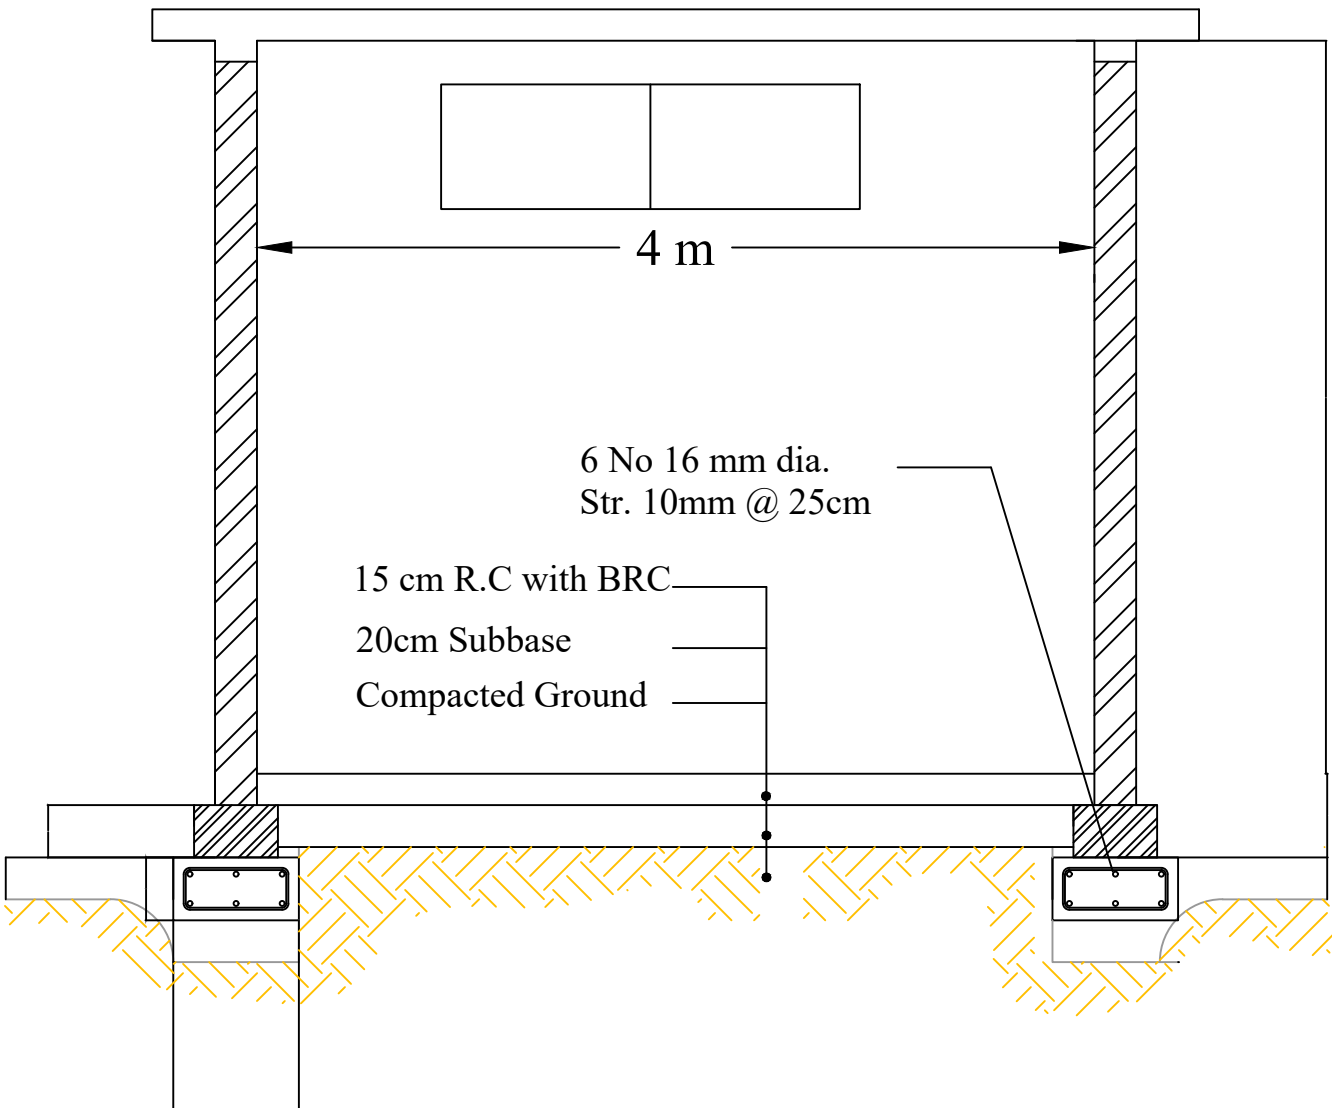


Section B-B

Telsqof play ground


Drawing no.10

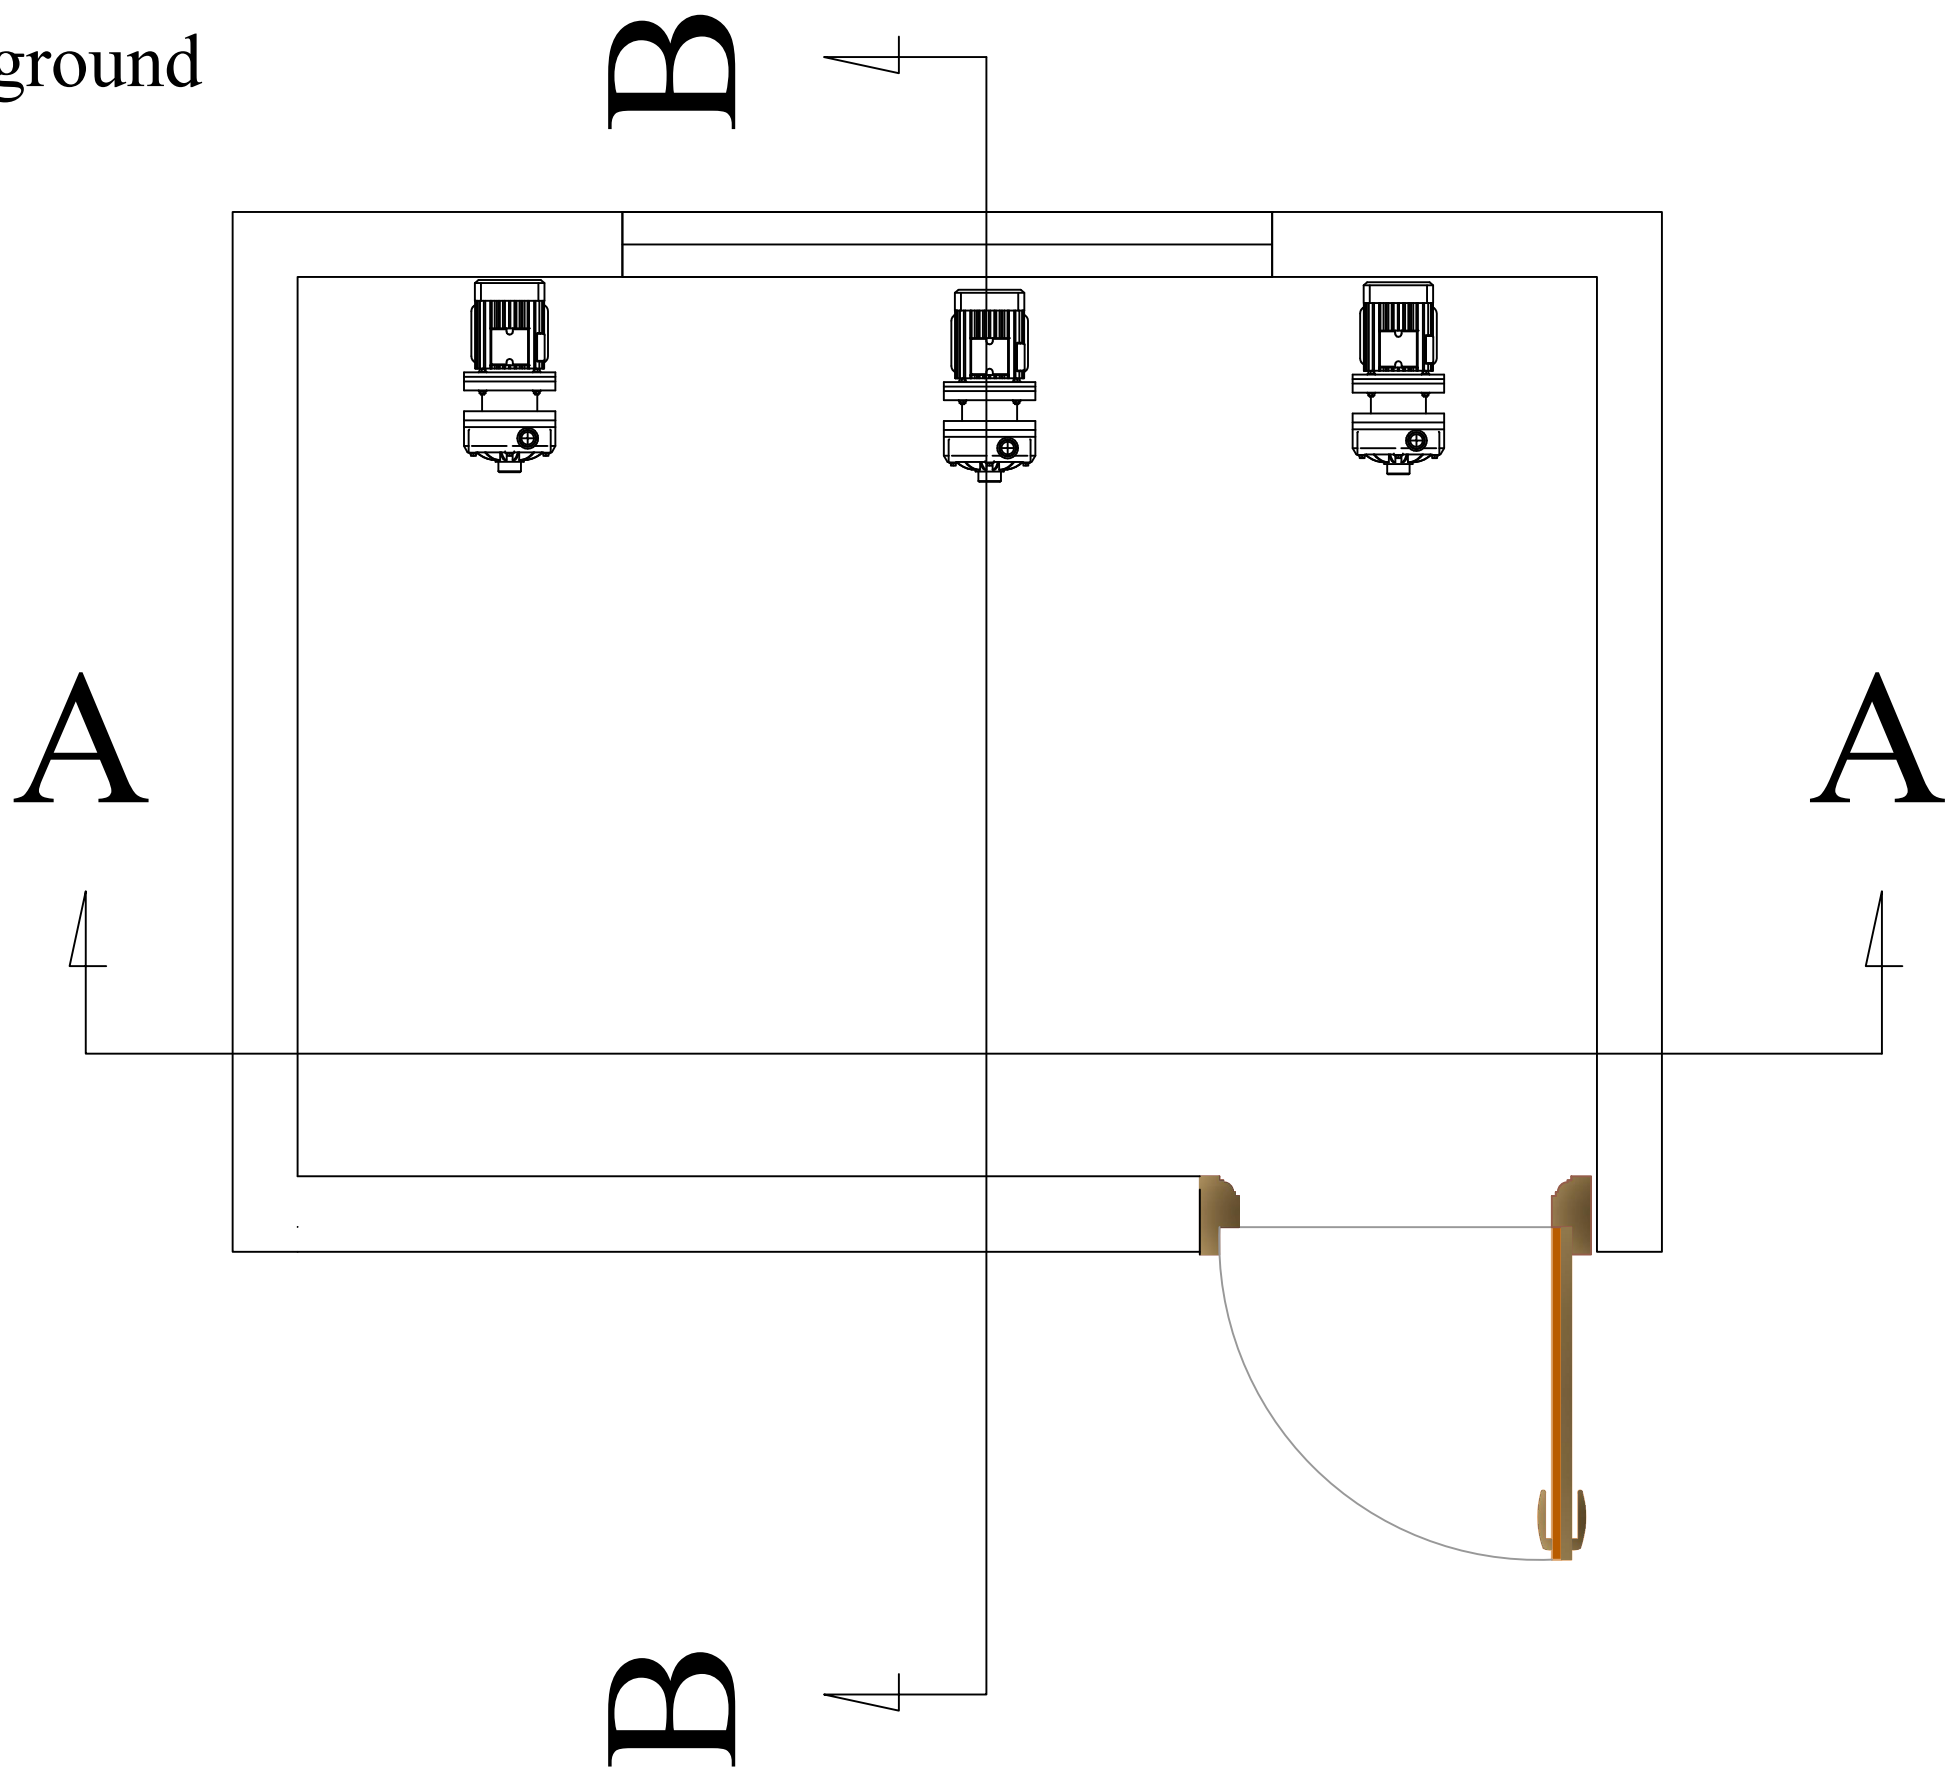

Water Room

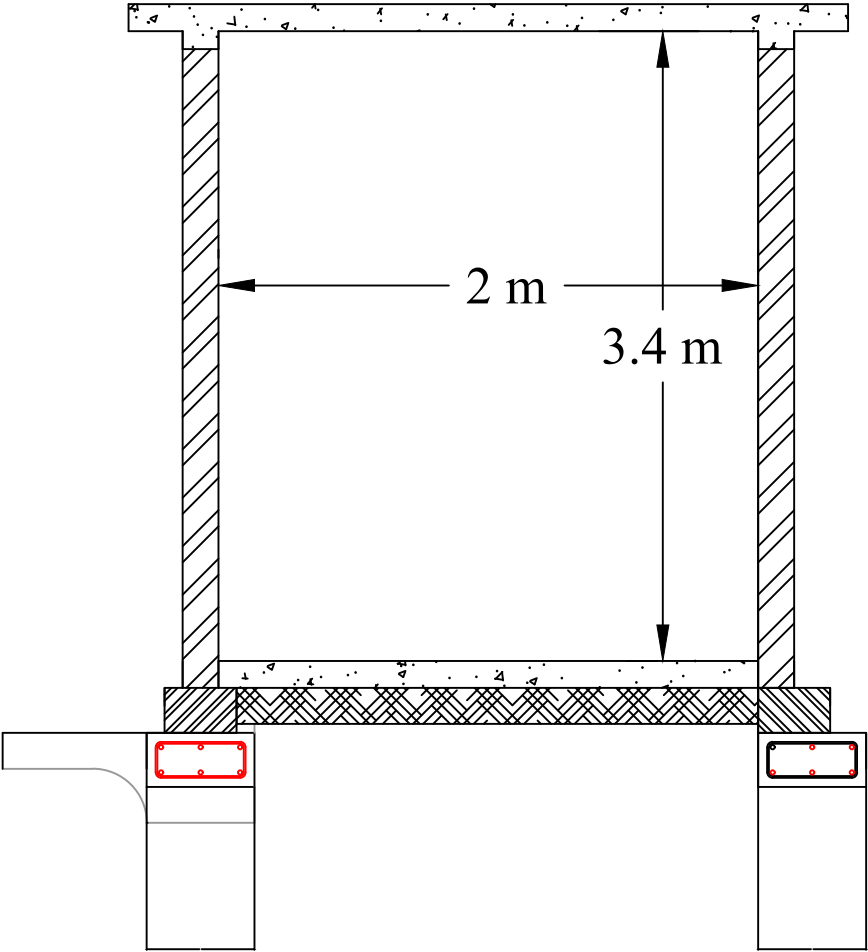


Section A-A

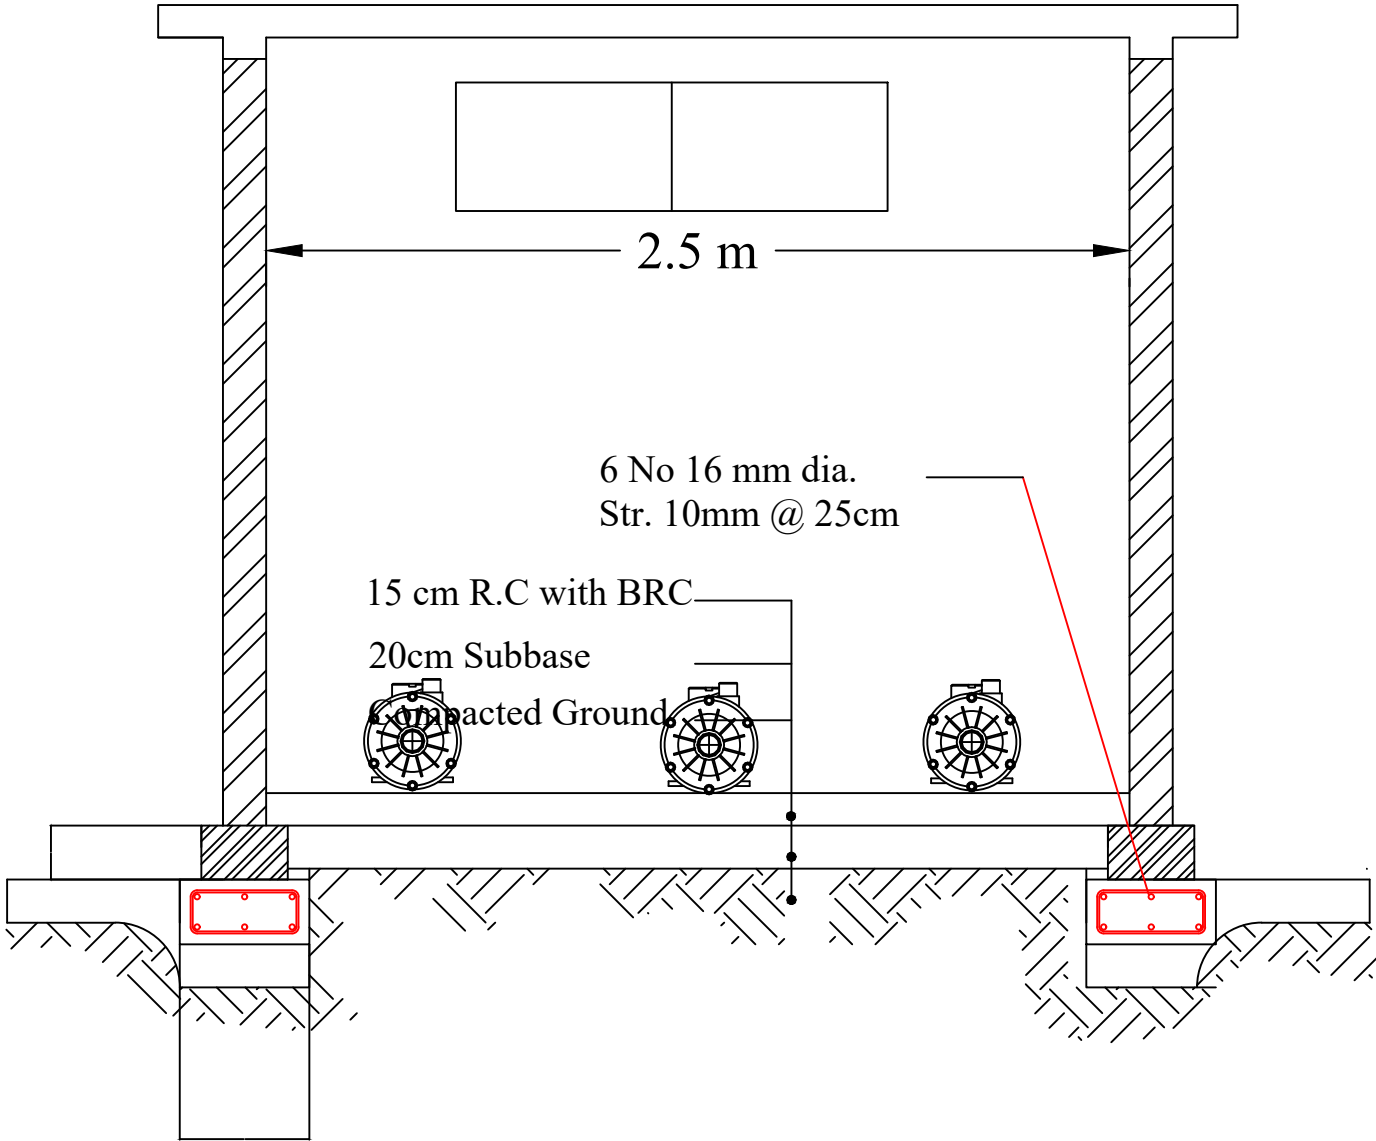


Section B-B


Details of water room

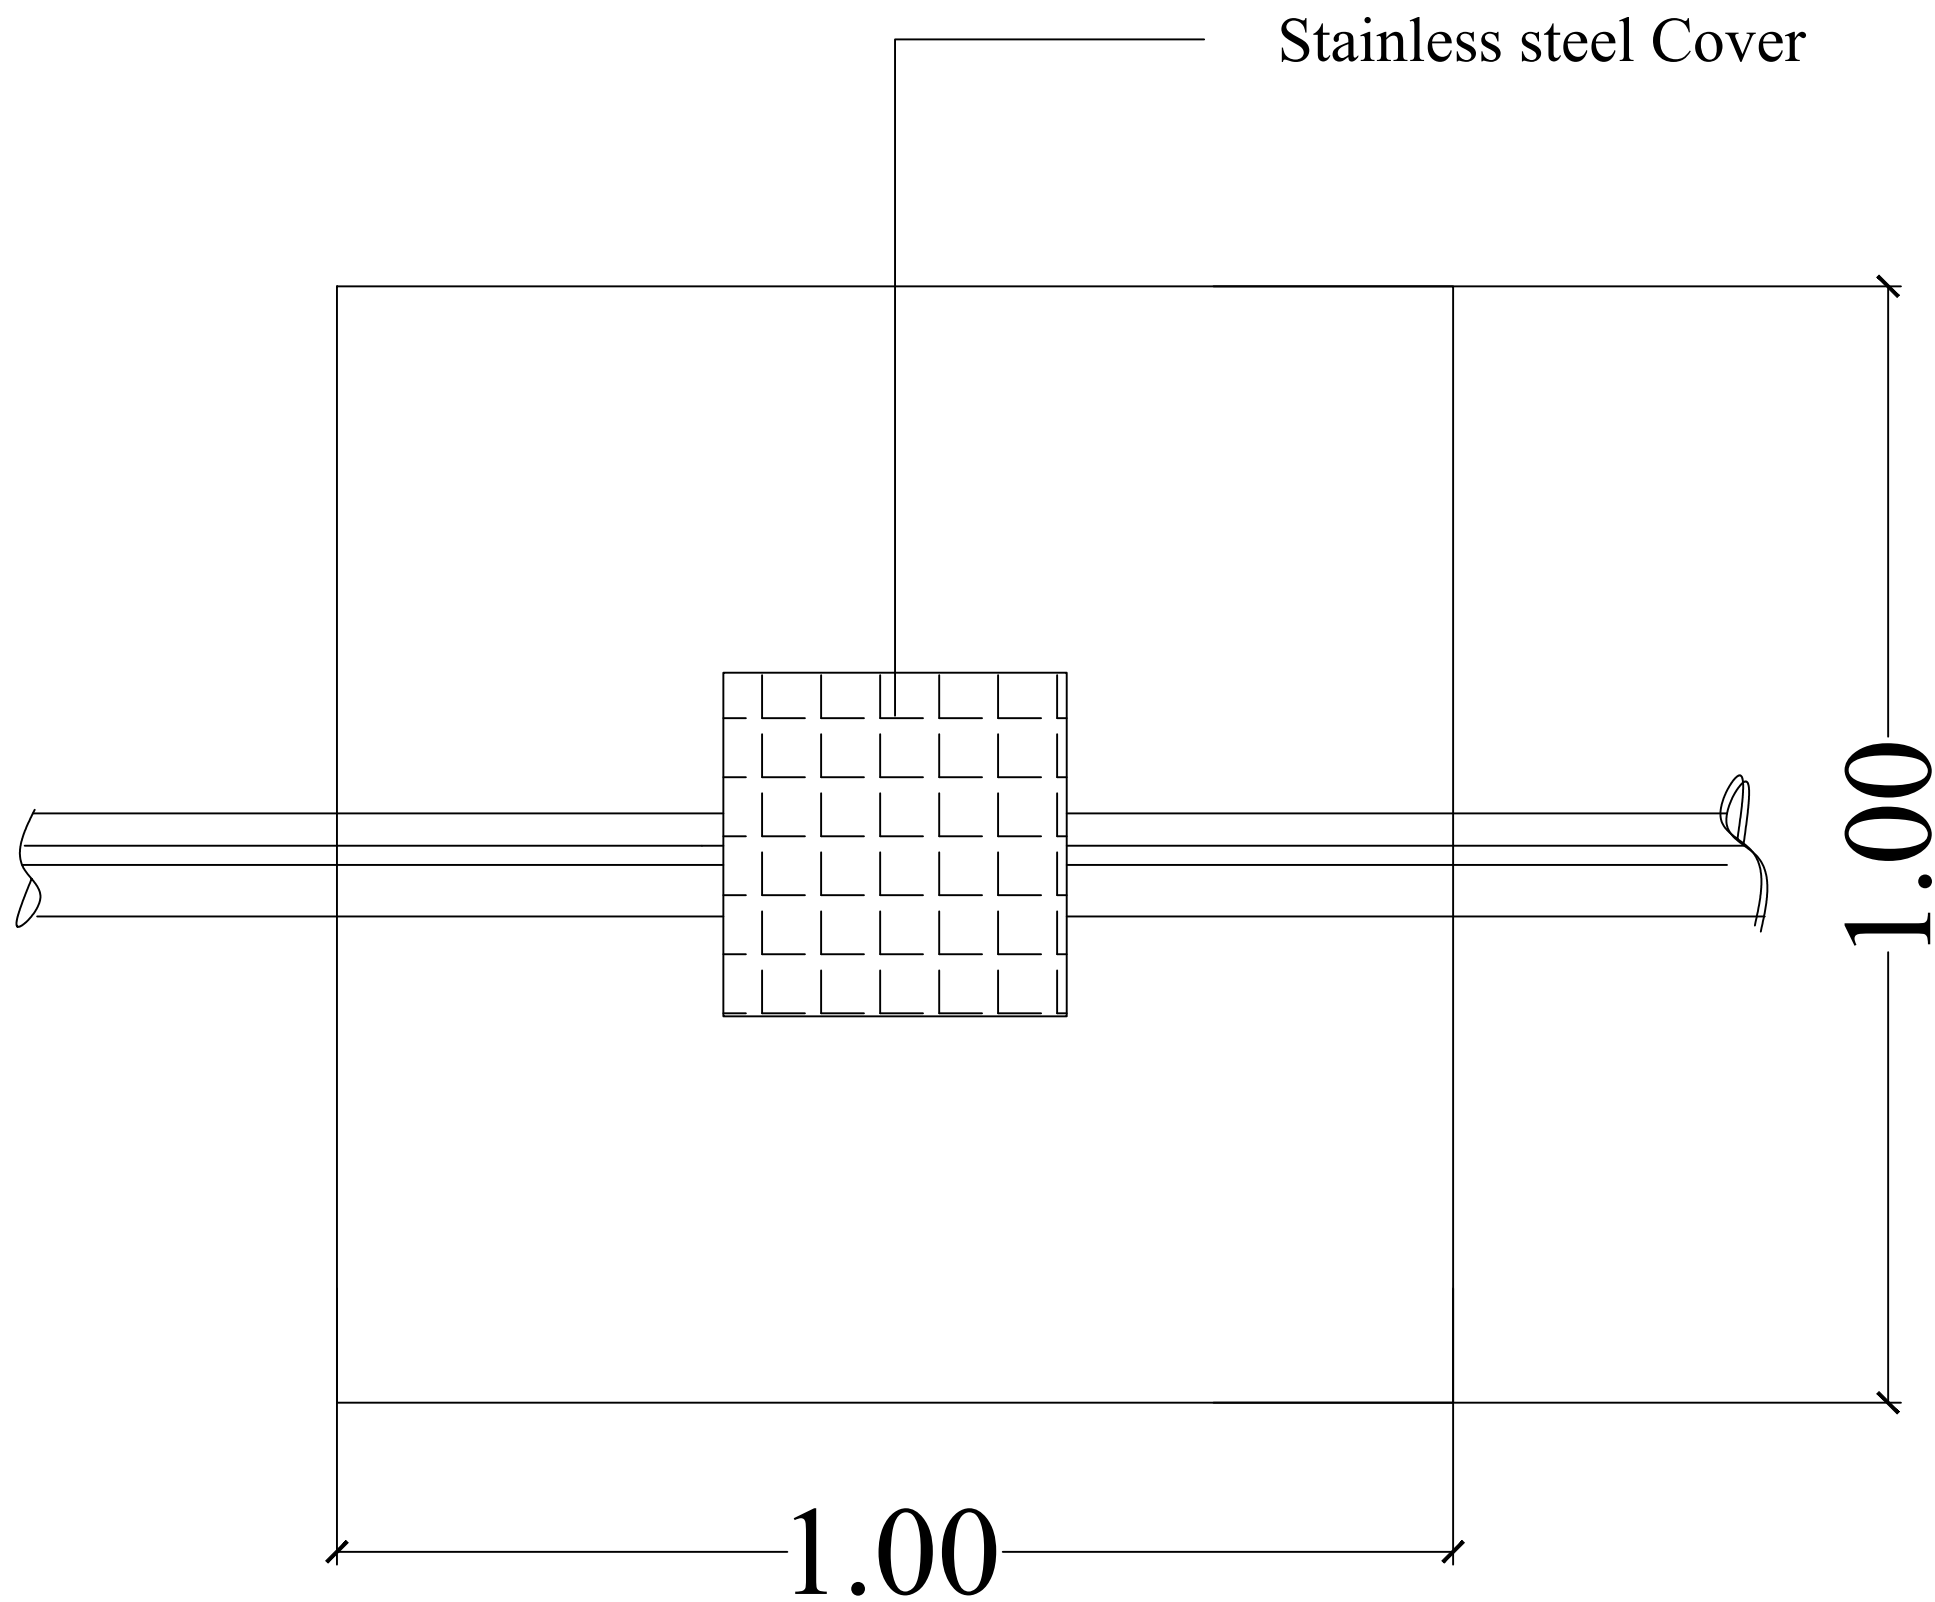

Plan of drainage manhole

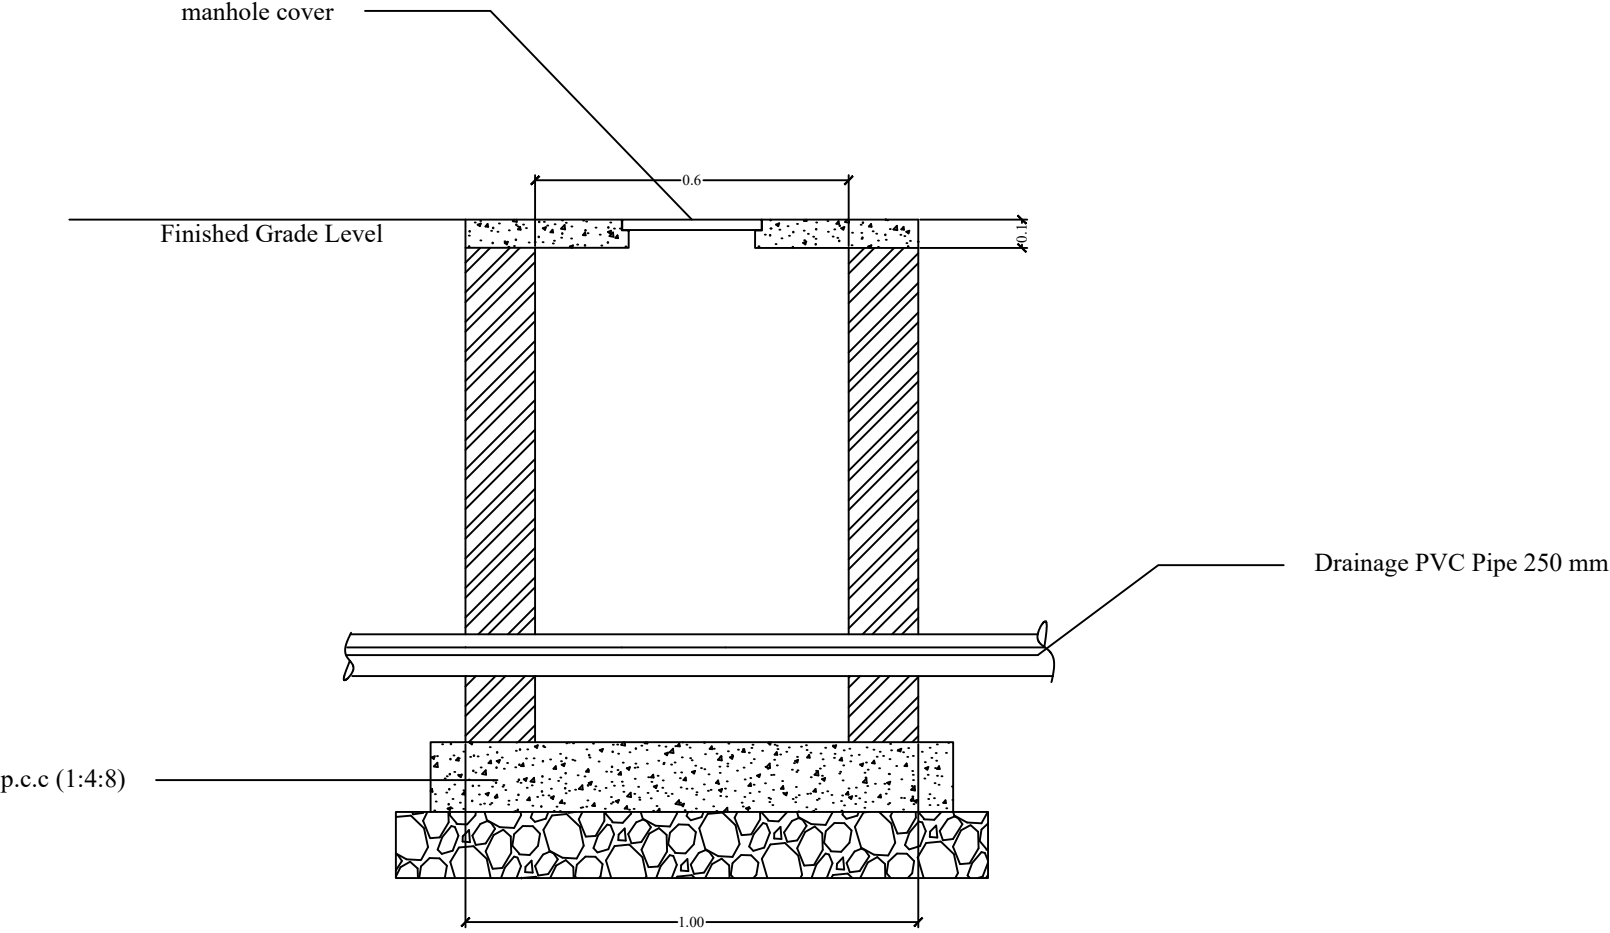


Front view Manhole

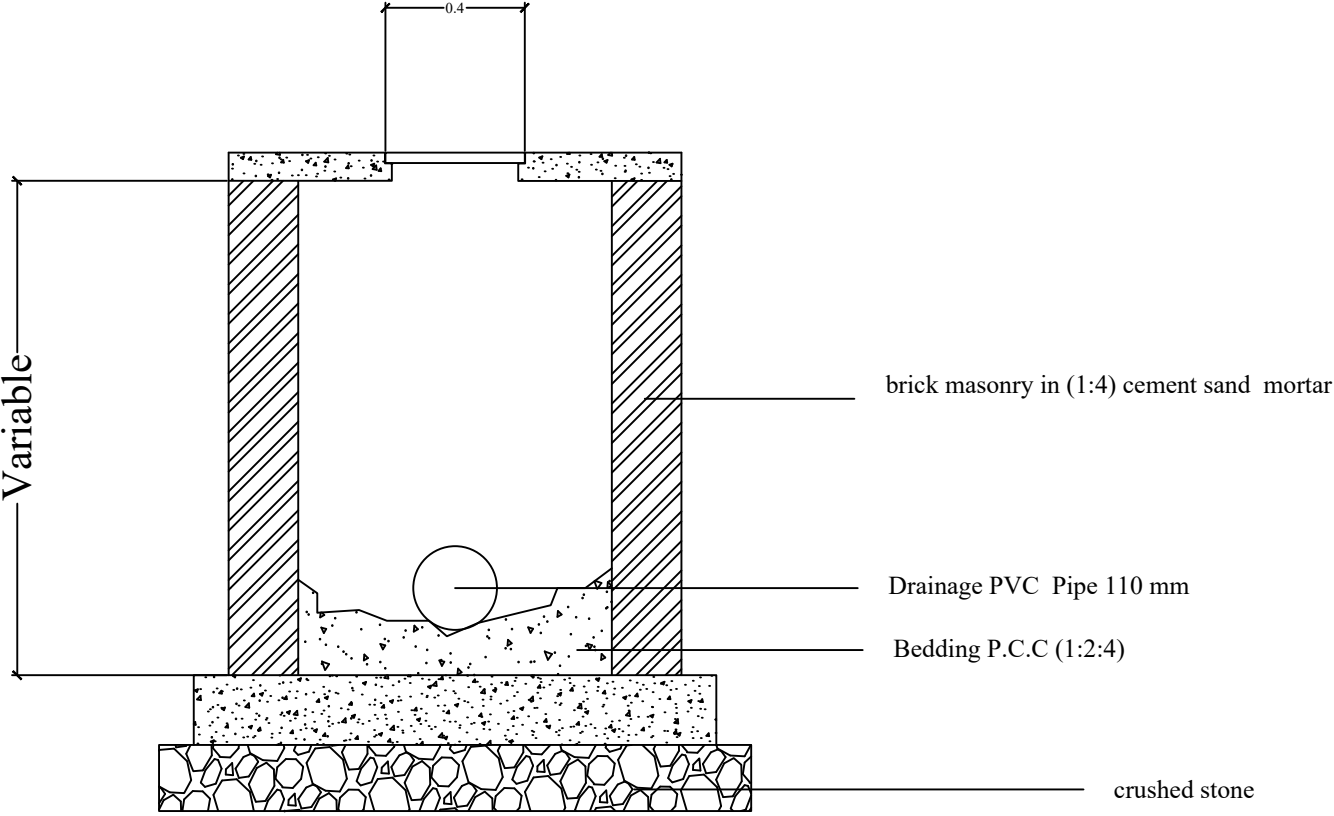


Side view Manhole

Details of Manholes

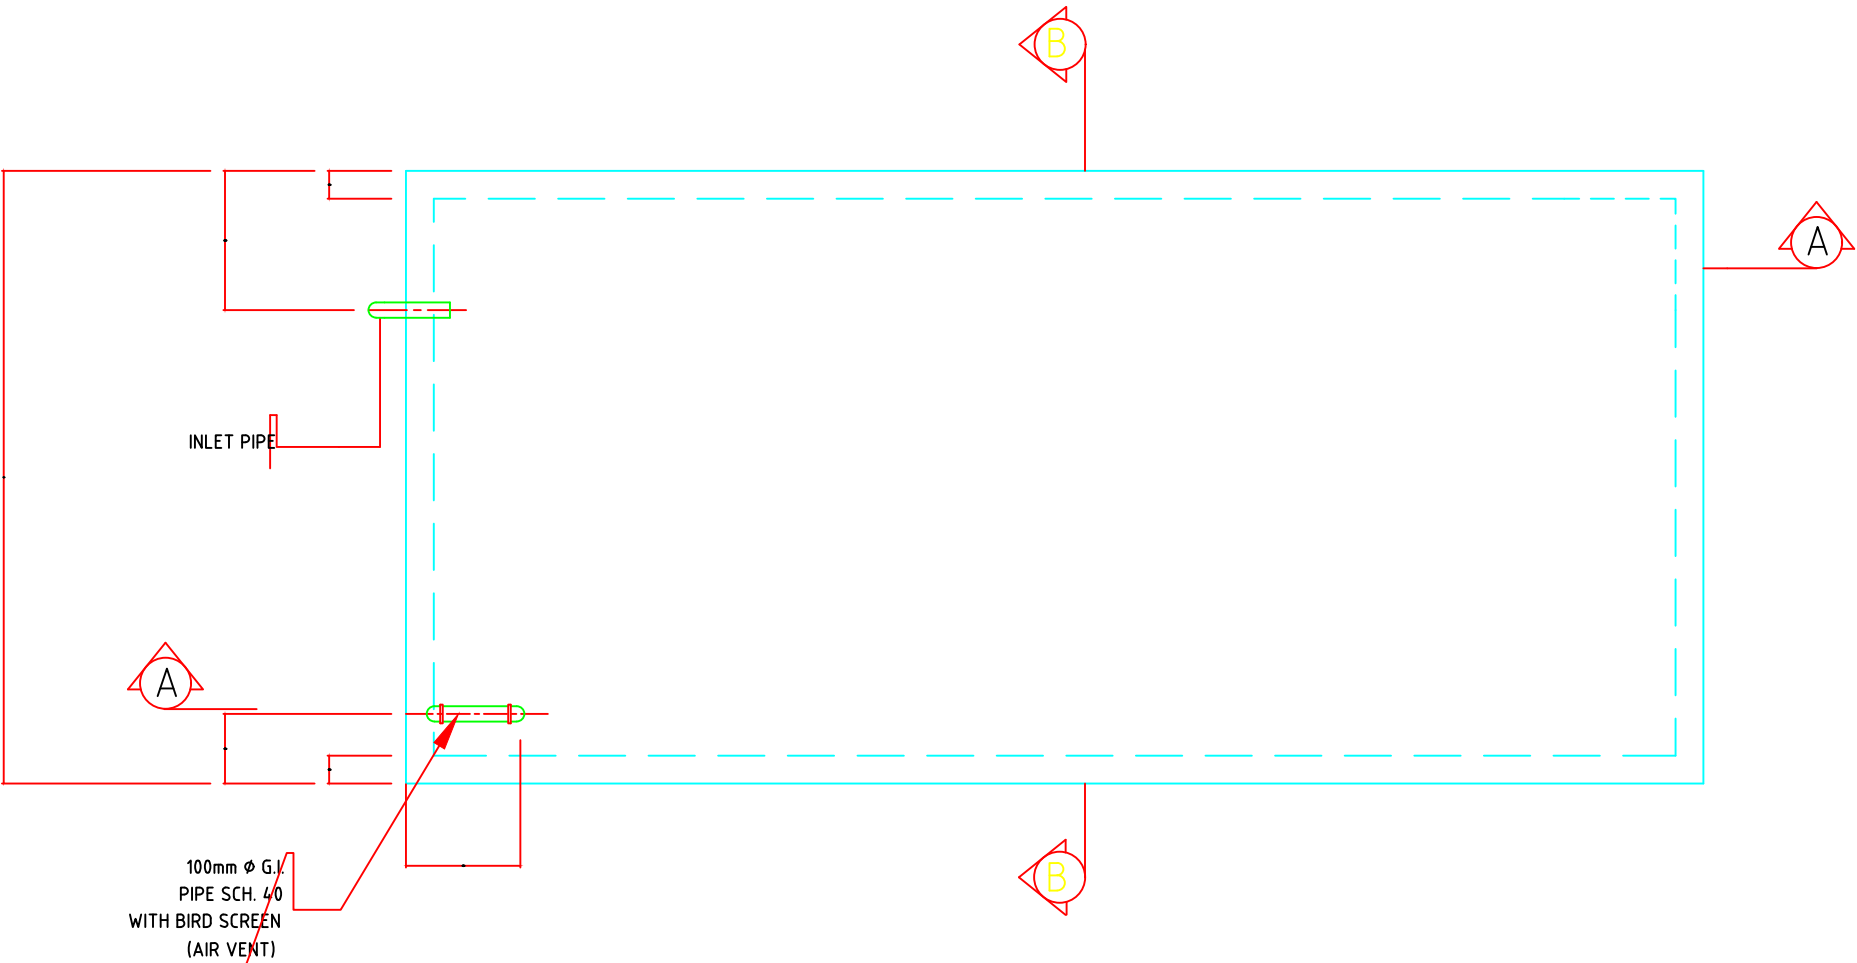

P L A N - CONCRETE WATER TANK


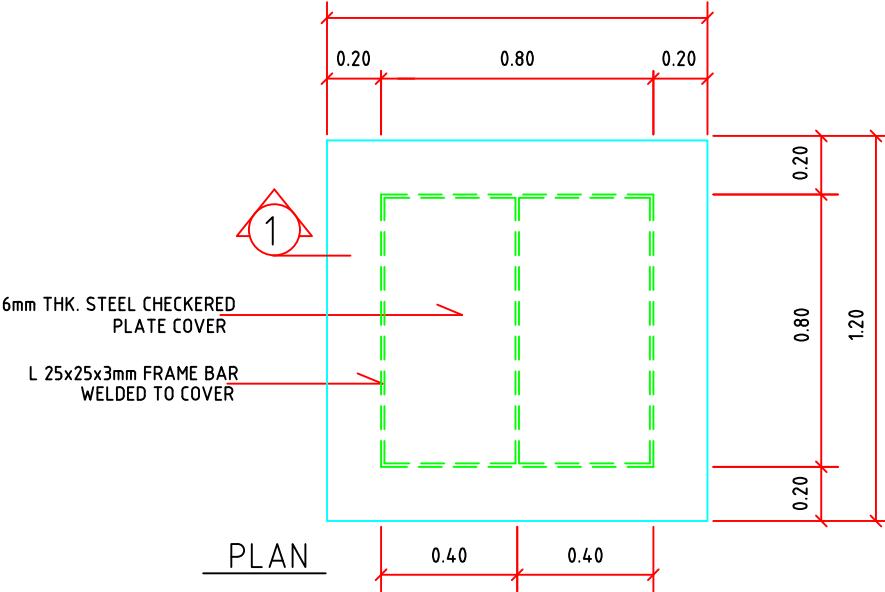


PLAN


Concrete water tank

Telsqof play ground


Drawing no.15

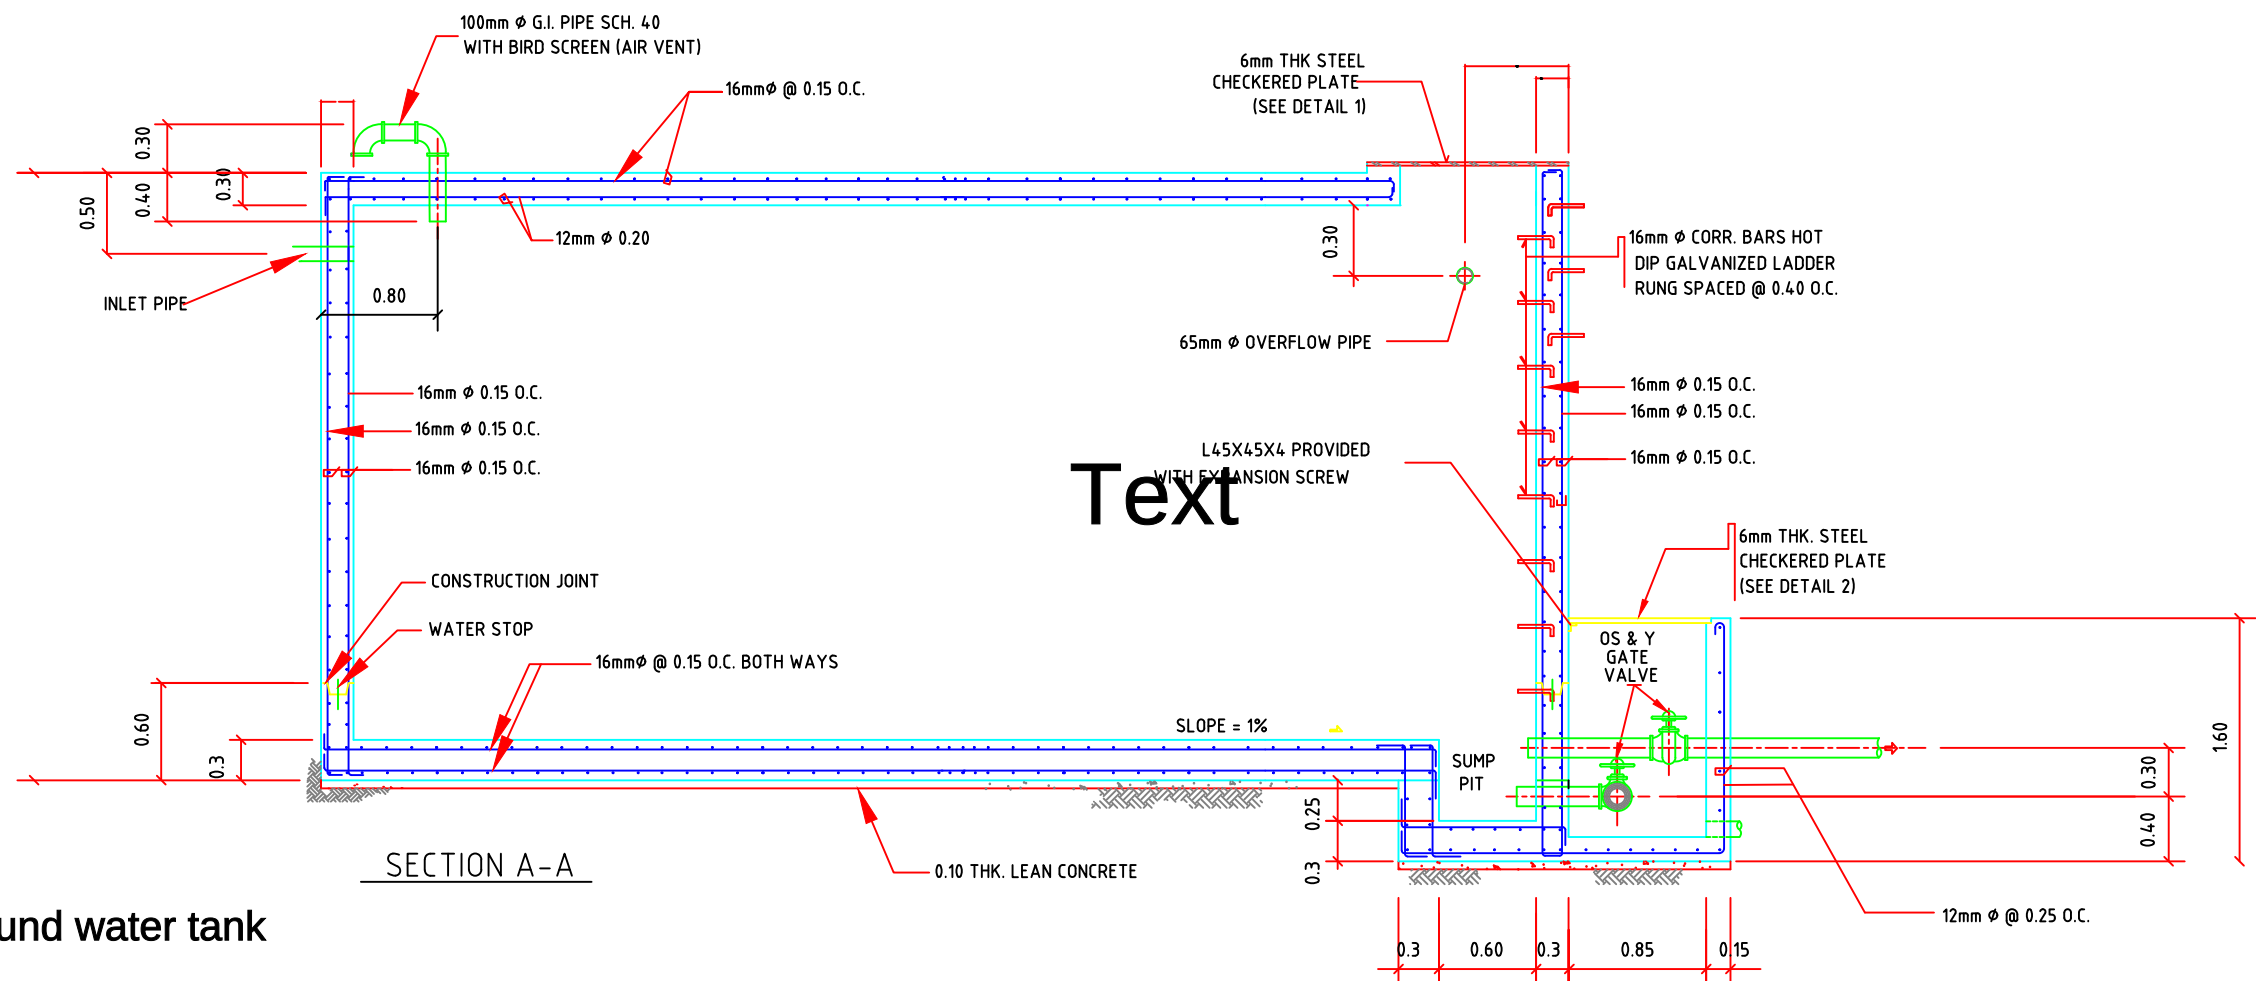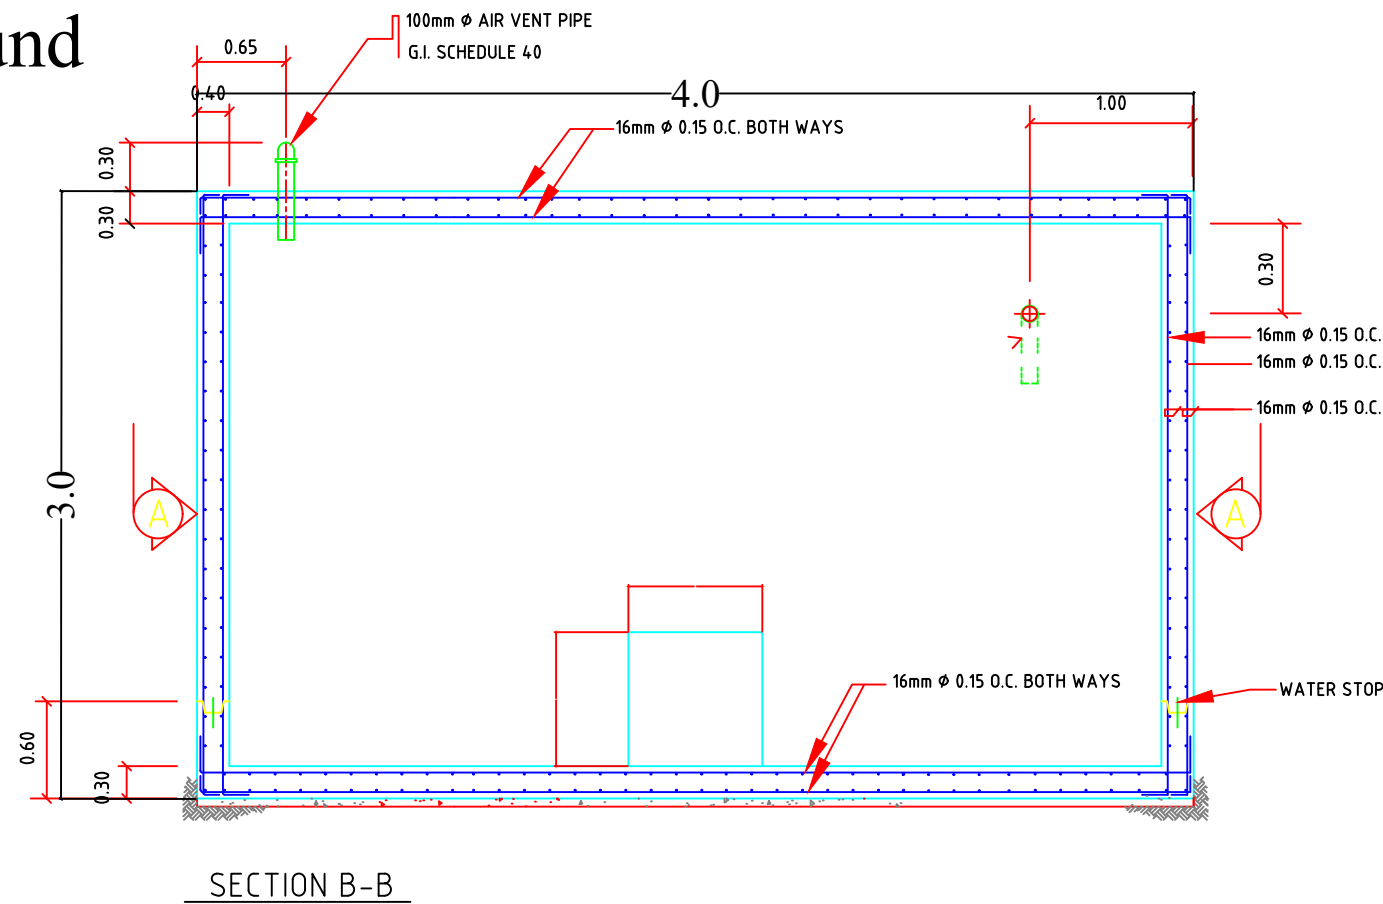


Details of underground water tank

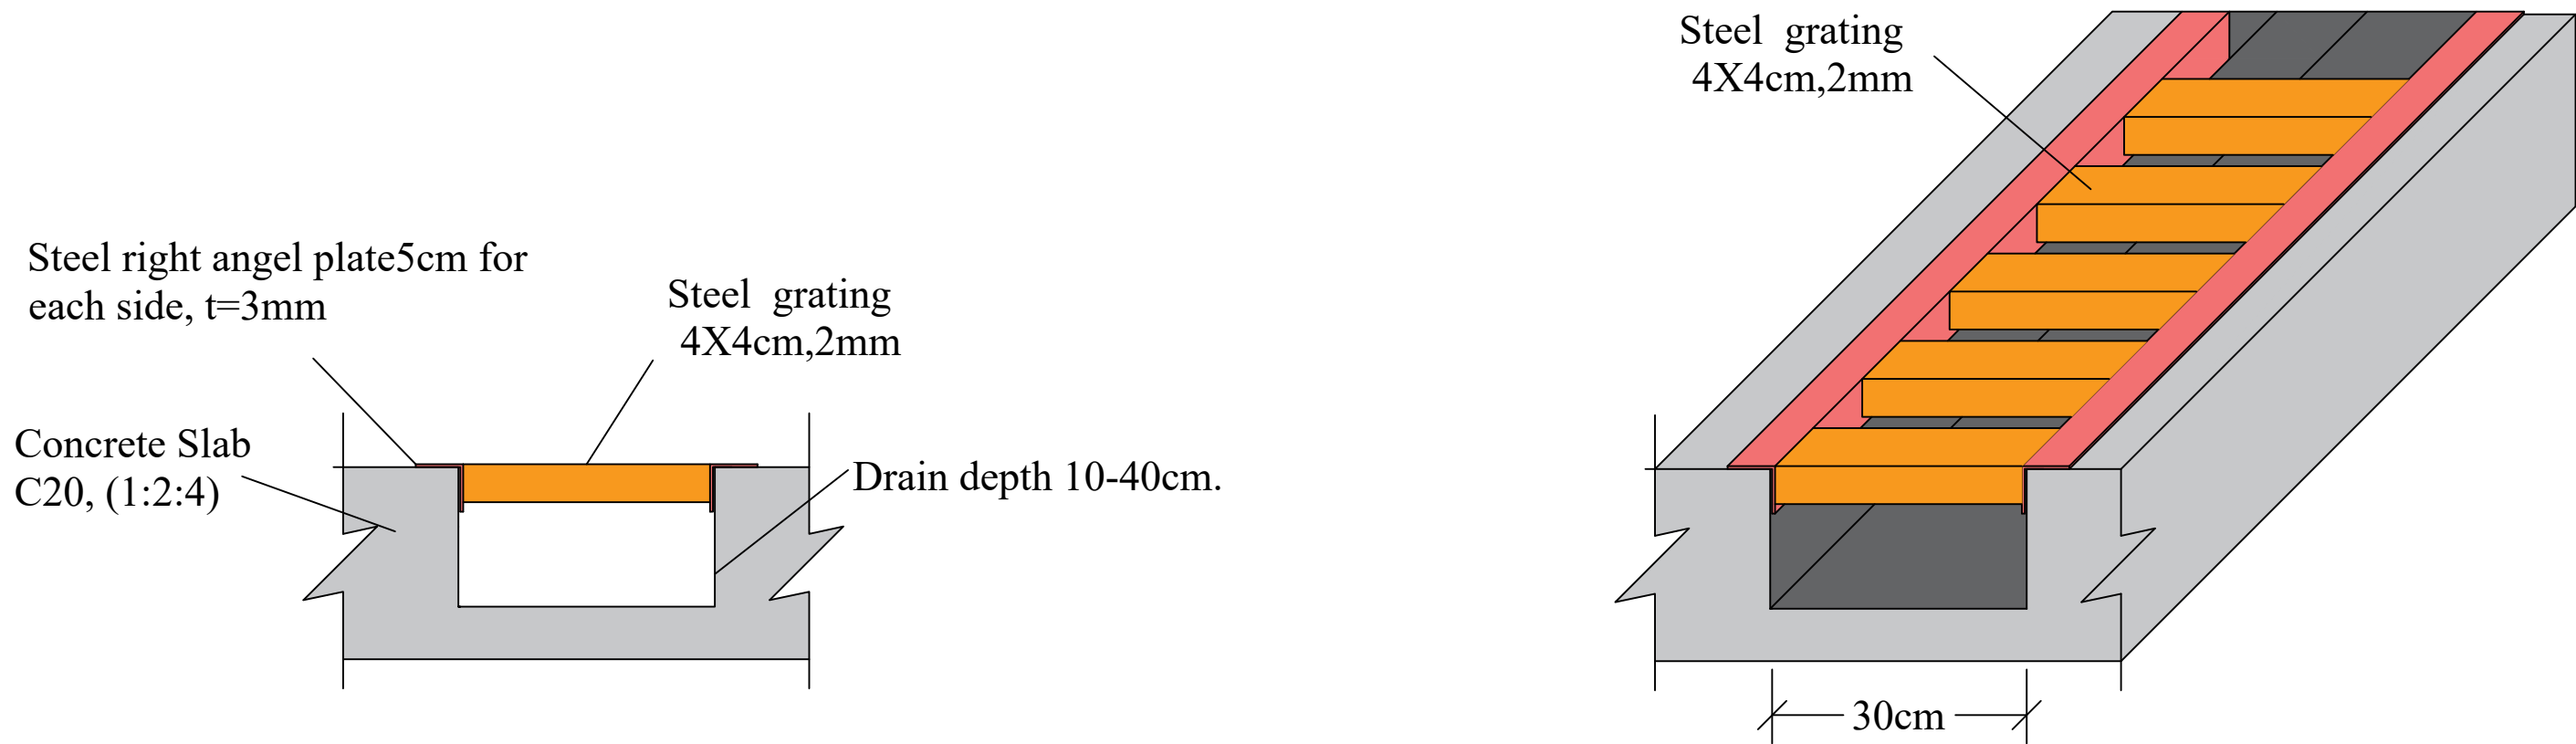

Drainage channel details

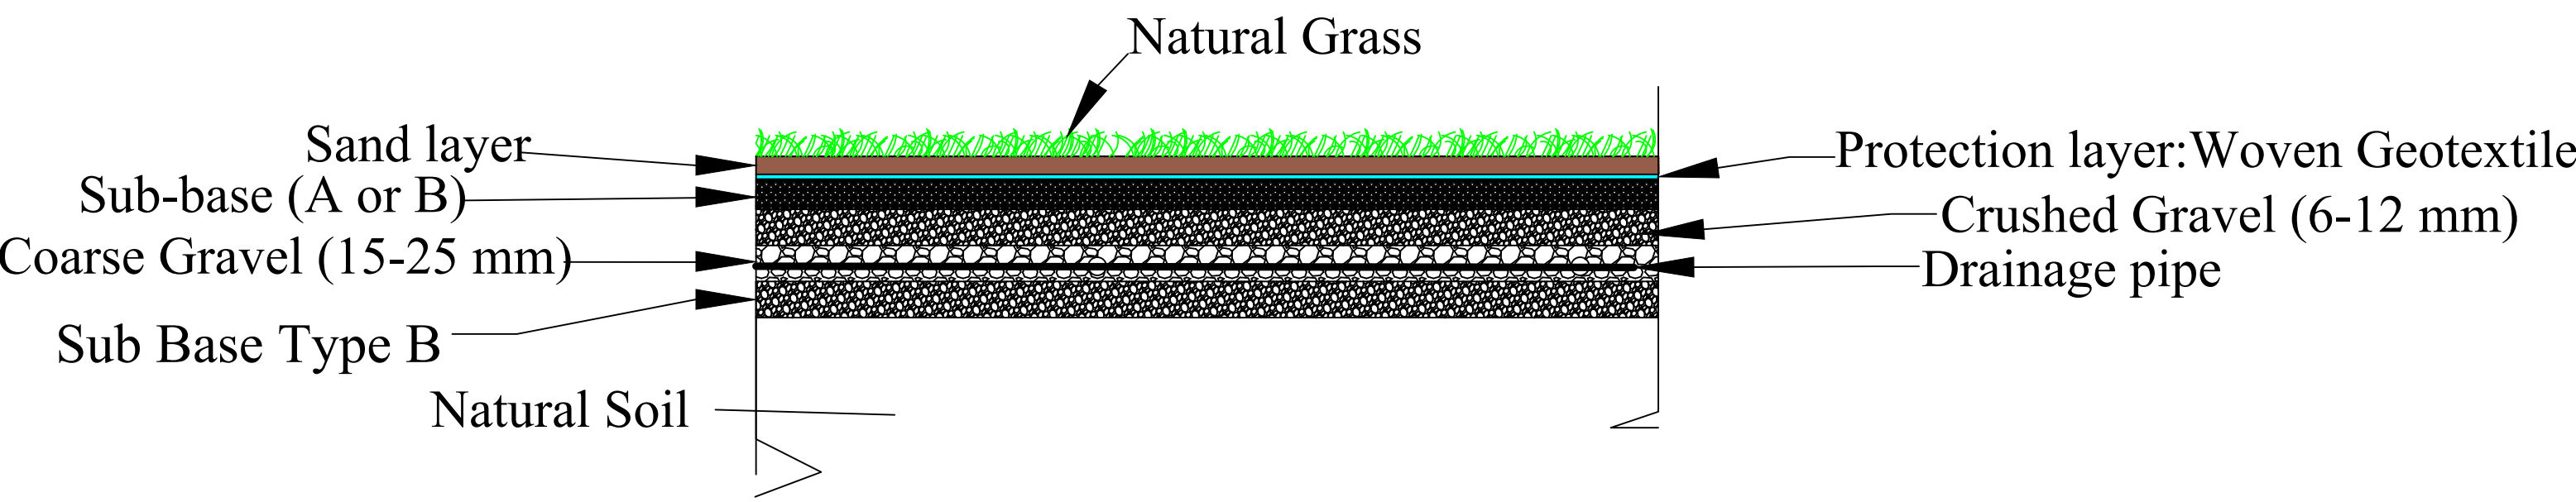


Section of backfilling

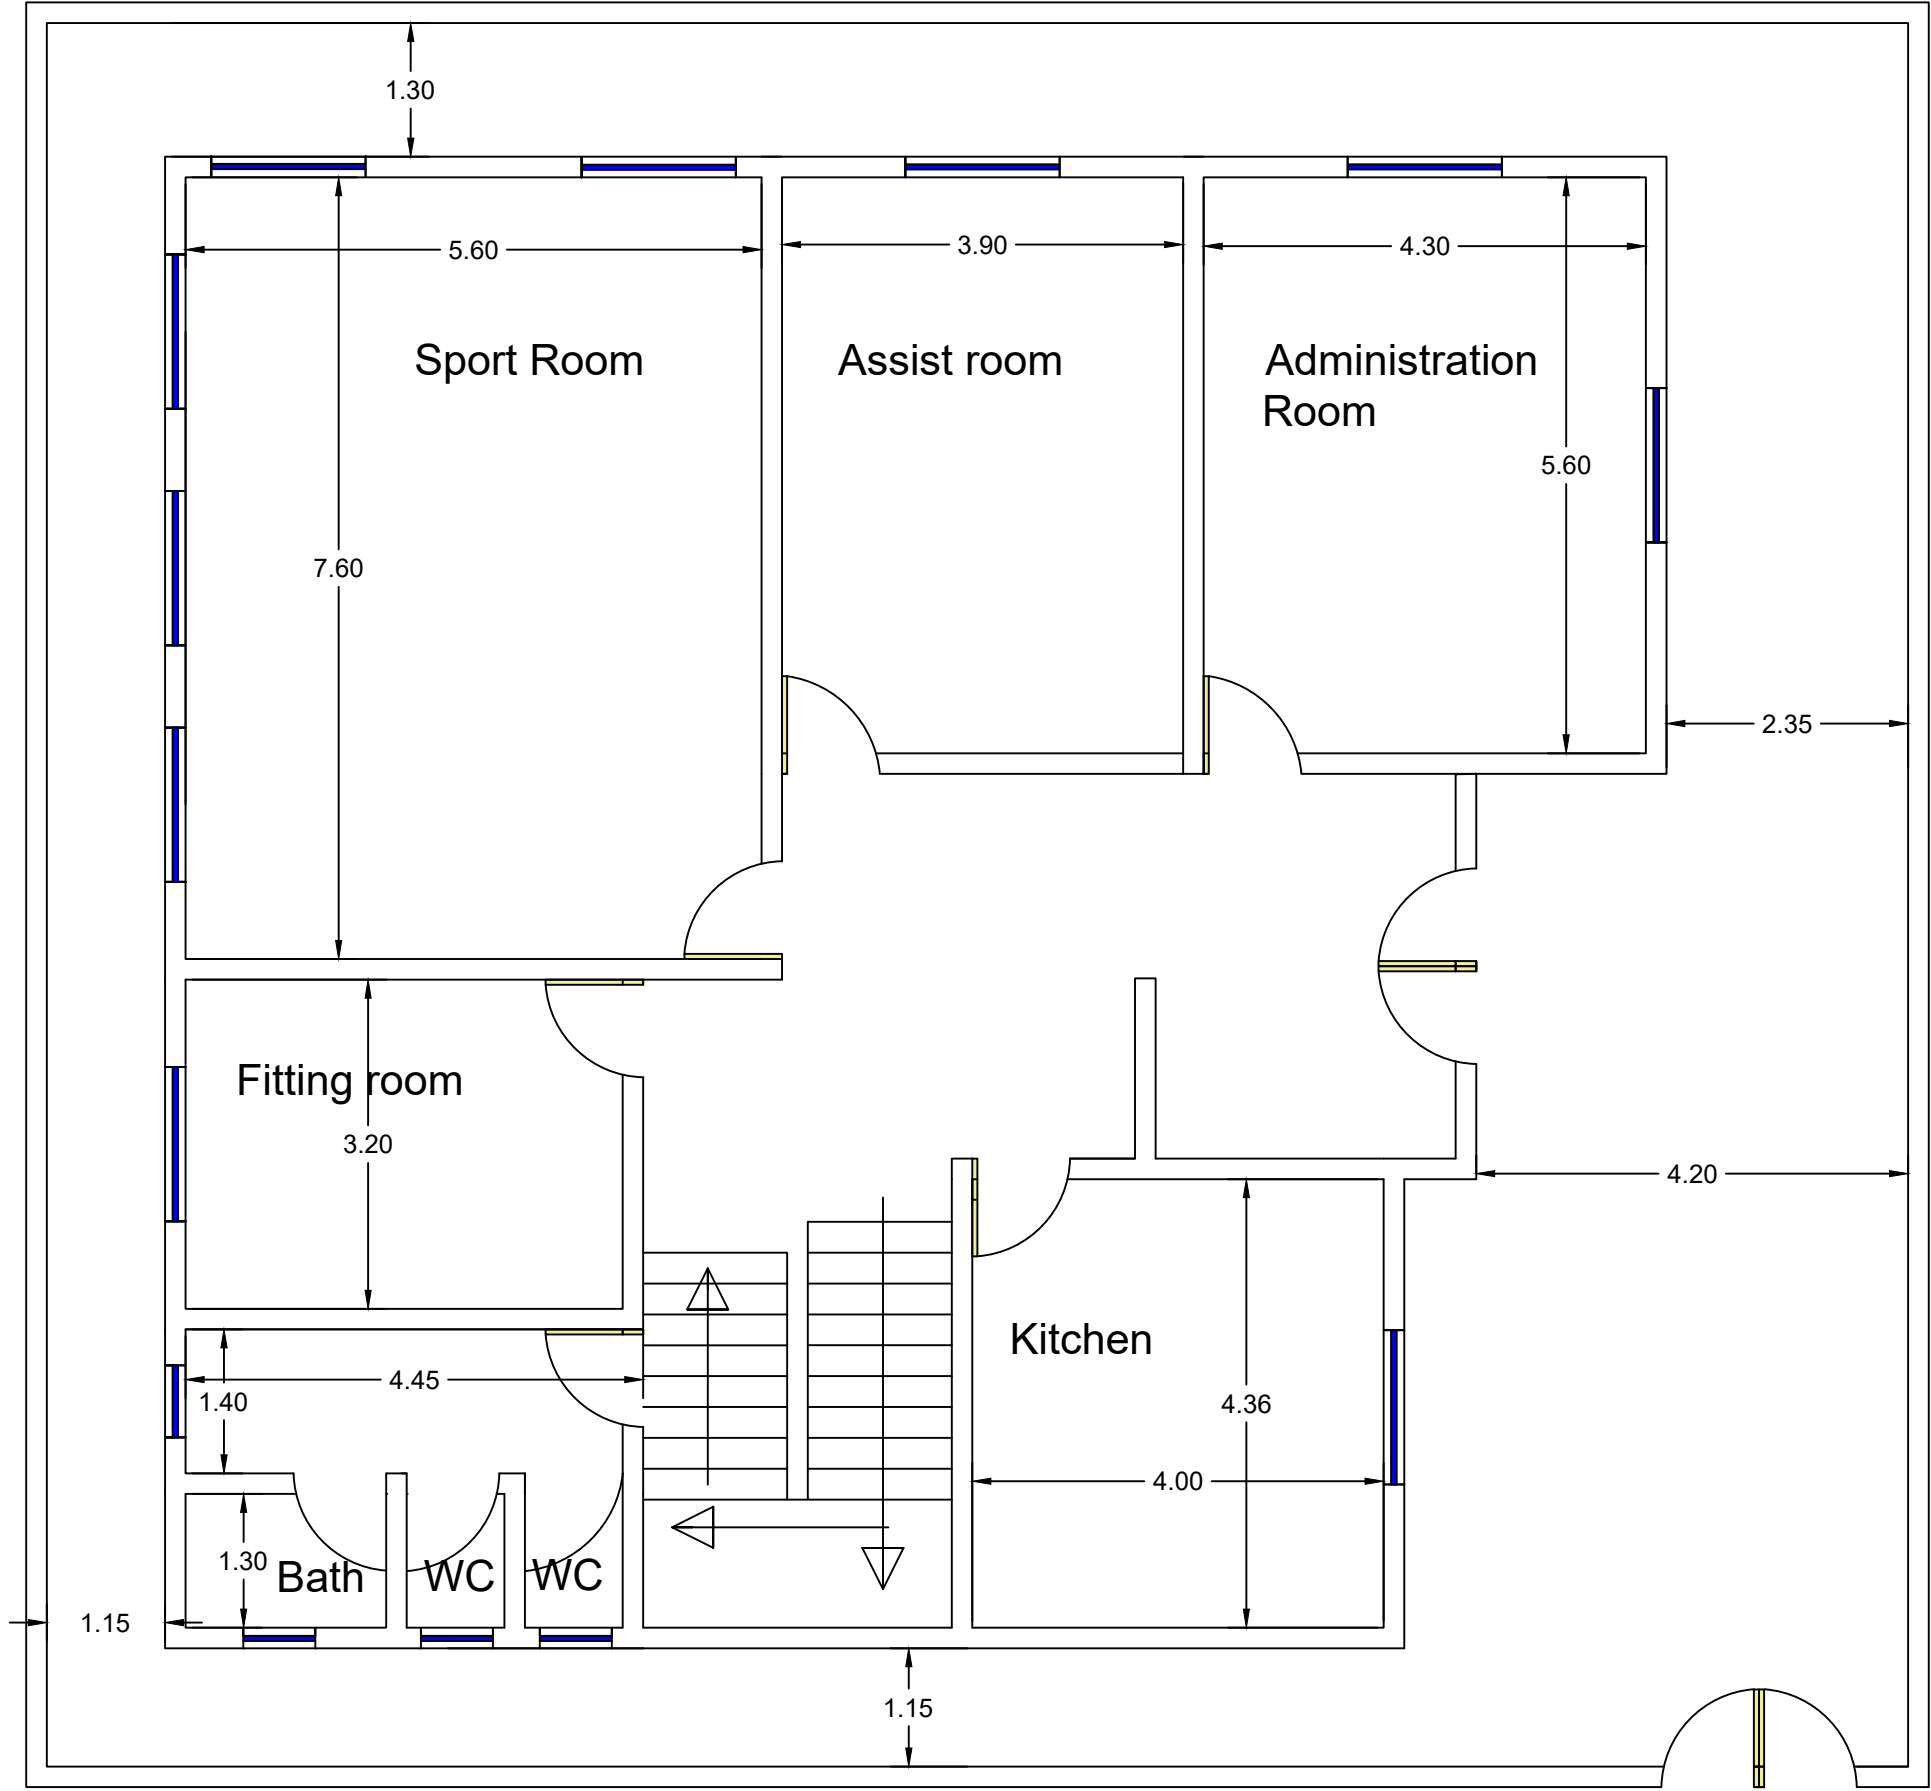

Telsqof play ground

Drawing no.19

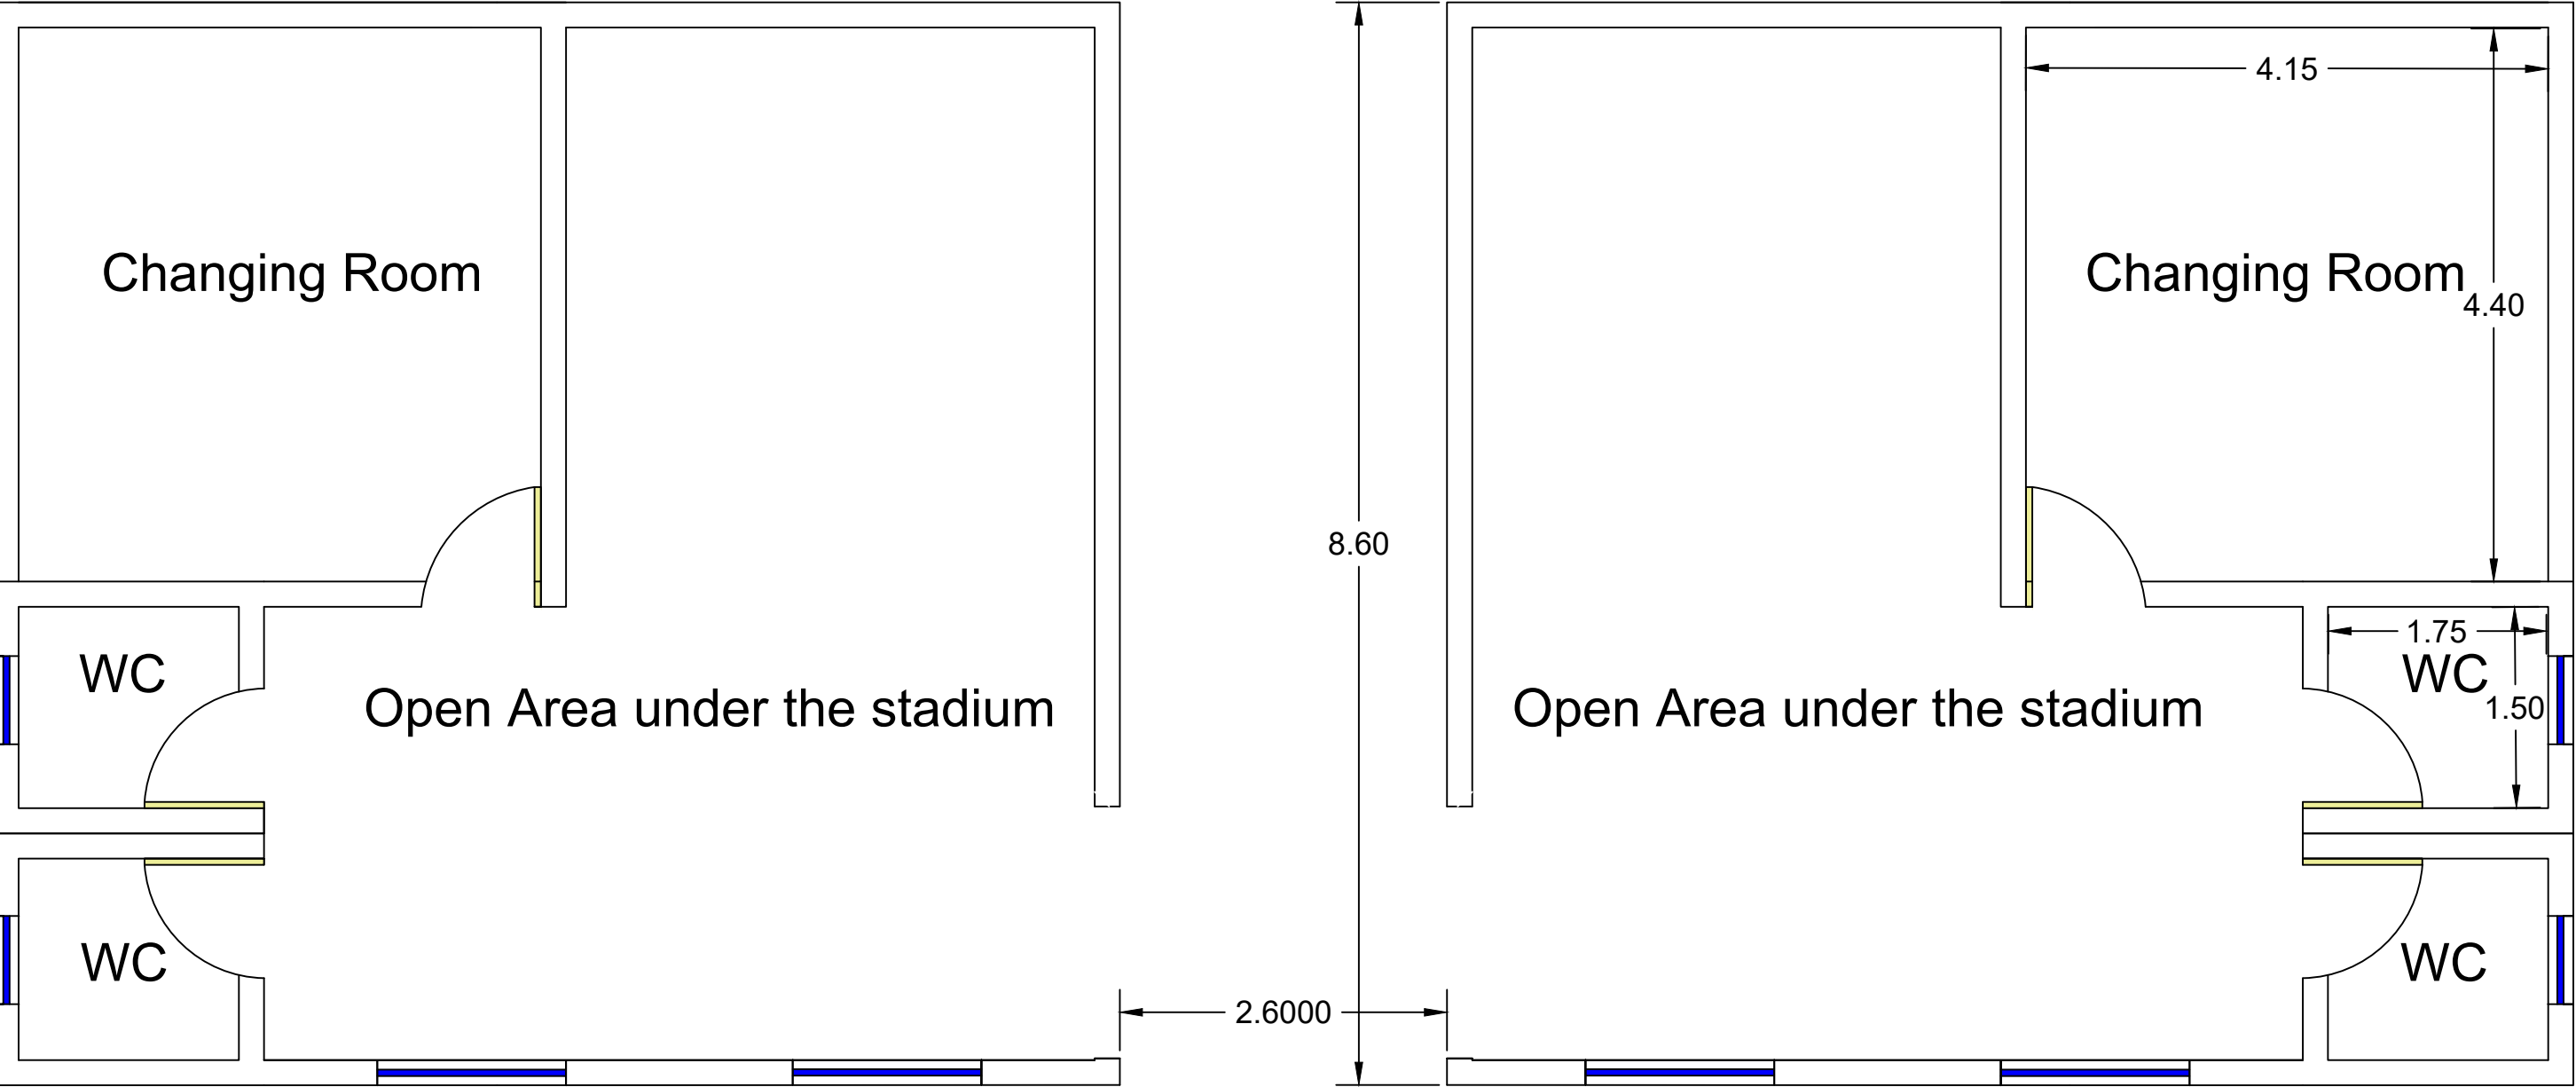

telqof stadium part details