

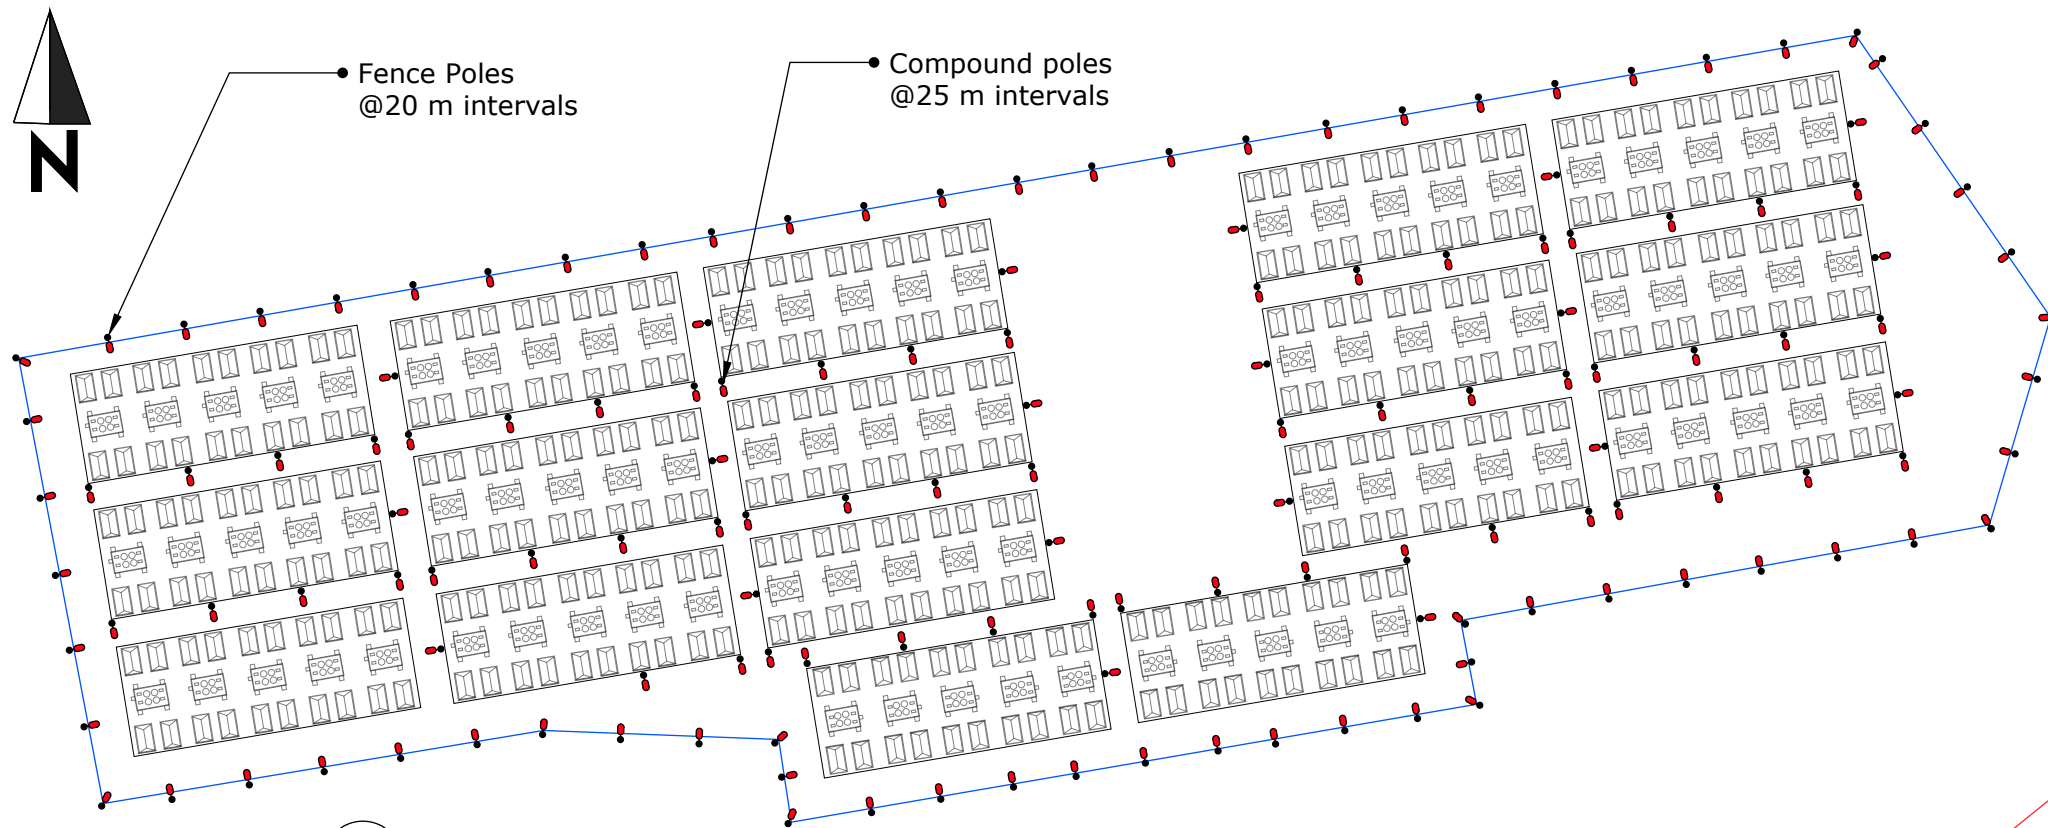


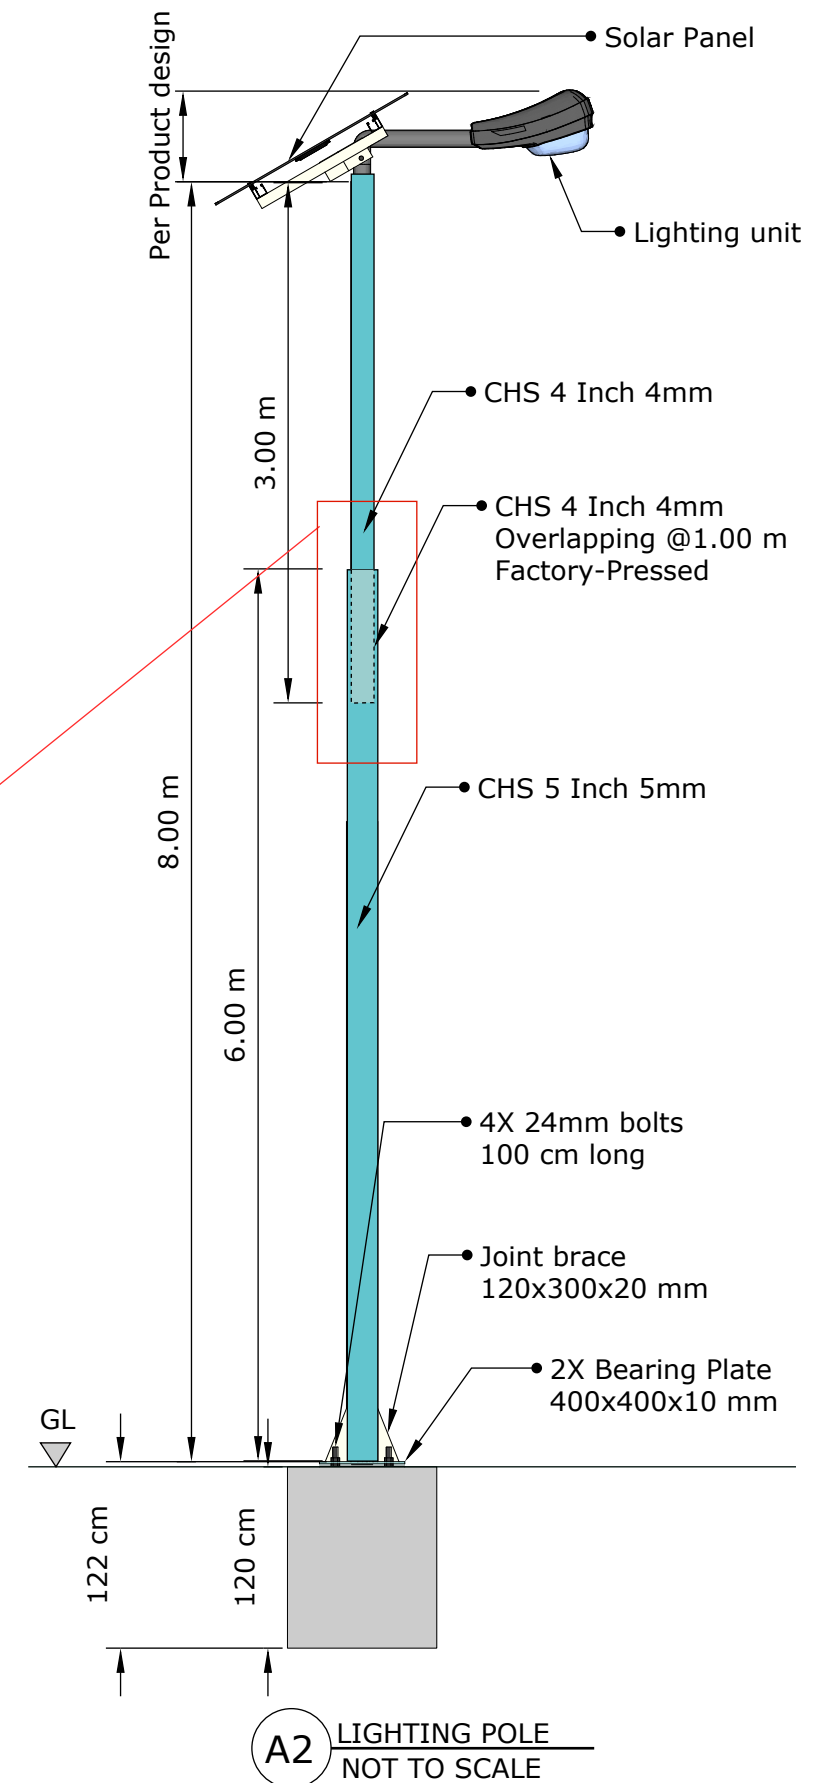

A1 SITE PLAN
NOT TO SCALE

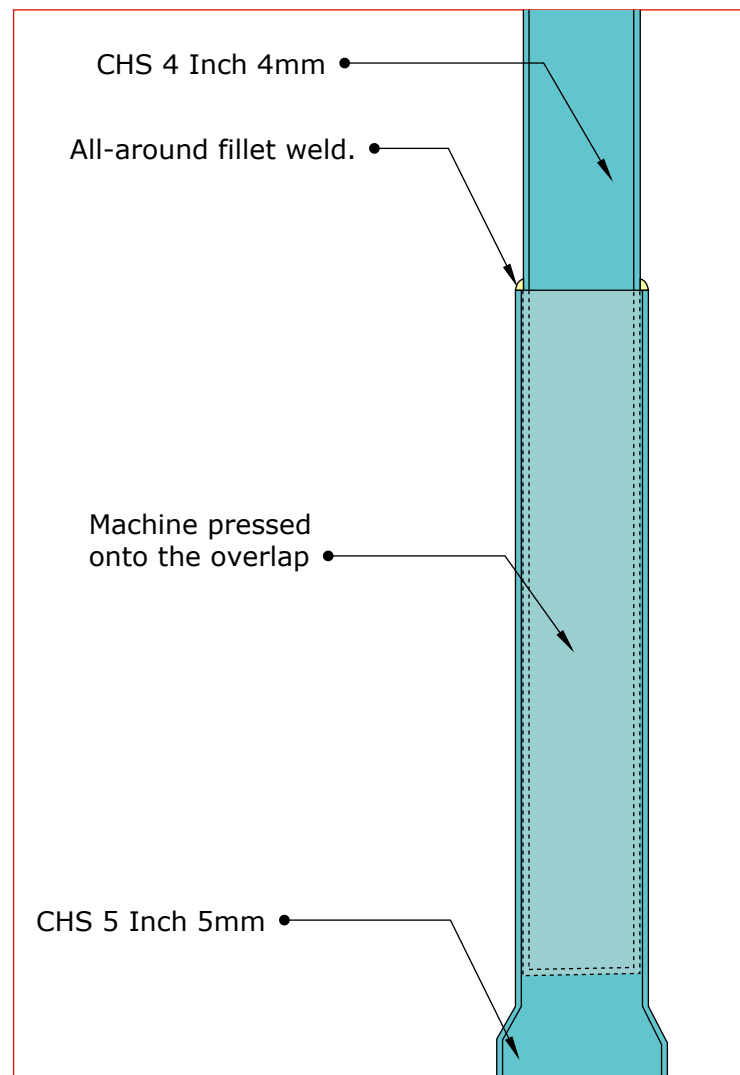

A2 LIGHTING POLE
NOT TO SCALE

BLUMONT INC.

Blueprint title: Illumination lighting project



Sheet number: 01

Sheet title: Network plan


Design lead: Omar Ali Rafeek, Moafaq H. Kanw

Approved by: Ibrahim A. Ahmed

Date: 4 FEB 2024

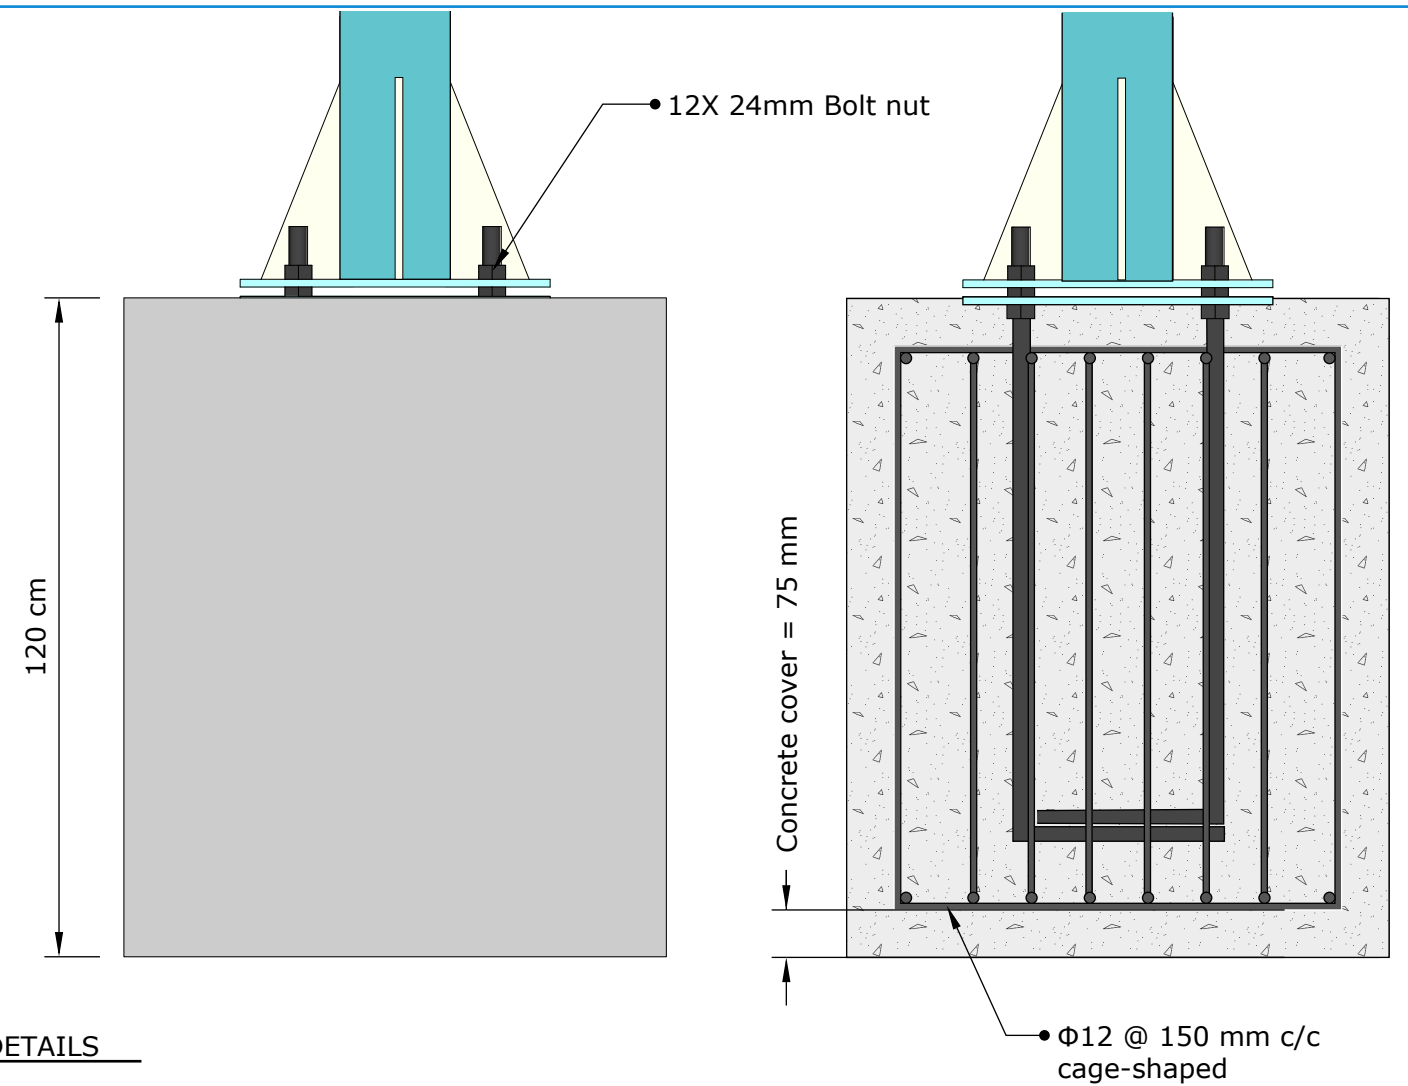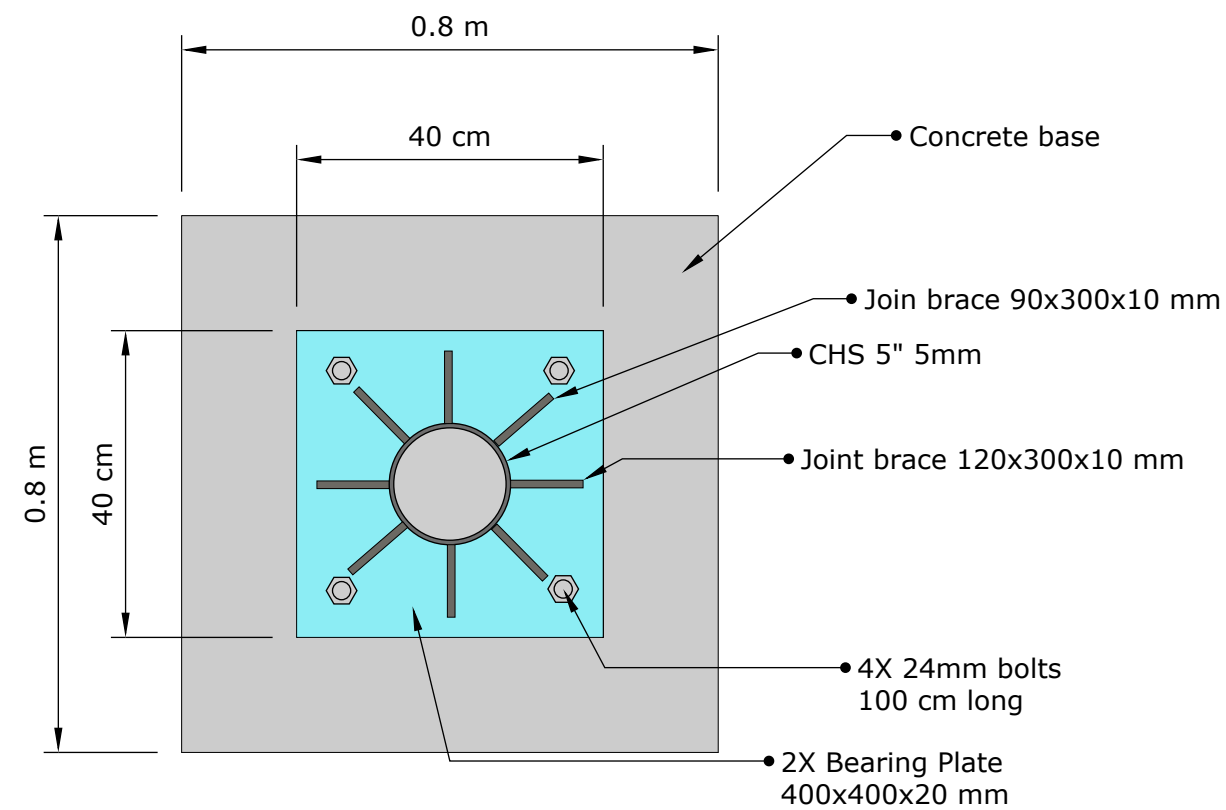

A3 CONCRETE BASE AND CONNECTION DETAILS
NOT TO SCALE

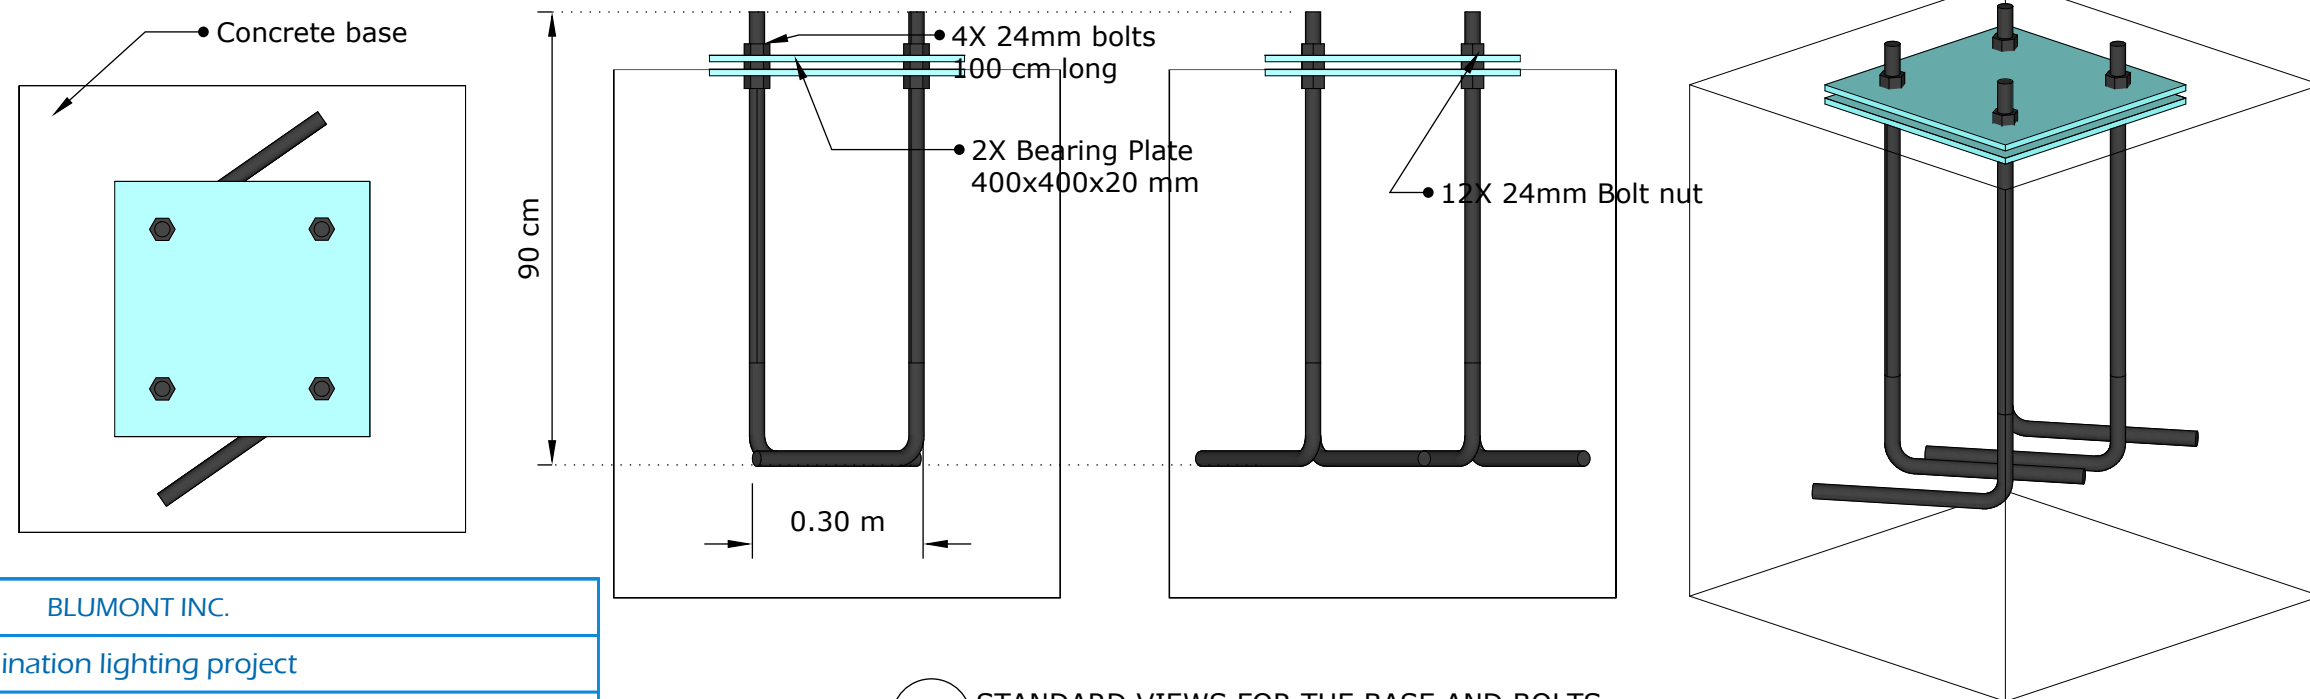

A4 STANDARD VIEWS FOR THE BASE AND BOLTS
NOT TO SCALE

BLUMONT INC.

Blueprint title: Illumination lighting project




Sheet number: 02

Sheet title: Foundation plan

Design lead: Omar Ali Rafeek, Moafaq H. Kanw

Approved by: Ibrahim A. Ahmed

Date: 4 FEB 2024

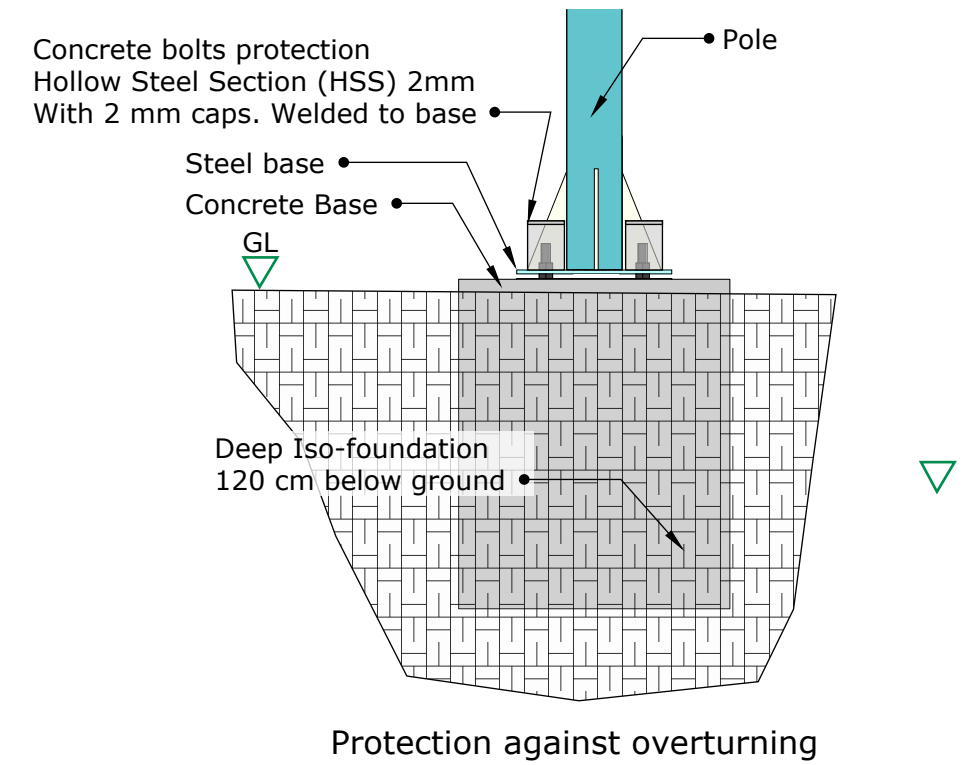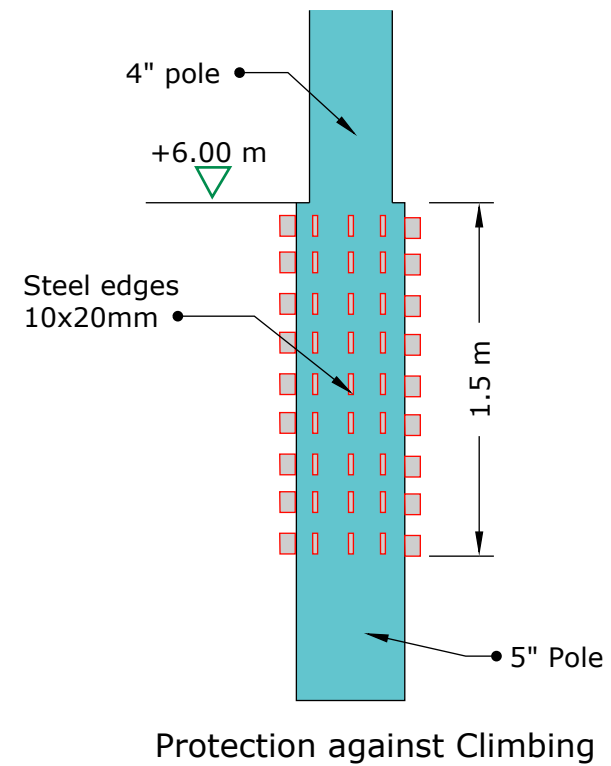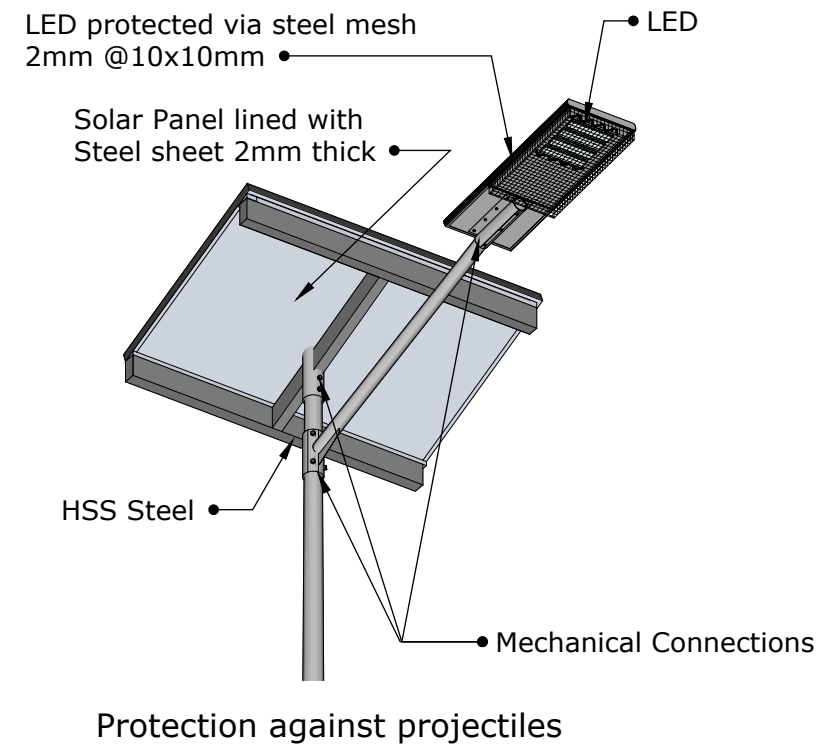

A5 PROTECTION MEASURES
NOT TO SCALE

BLUMONT INC.

Blueprint title: Illumination lighting project

Sheet number: 03

Sheet title: Protection measures

Design lead: Omar Ali Rafeek, Moafaq H. Kanw

Approved by: Ibrahim A. Ahmed

Date: 4 FEB 2024