

LEGEND

New Underground Sewage line

Existing Underground Sewage line

Existing Fence

New Fence

Job site boundaries

New CC compound

New Manholes

New Gate

Existing Gate

COMPONENTS OF THE NEW CC COMPOUND

Community Center (CC)

Case Management Room

M/F/PWD Latrines

Canopy

Walkway

Perimeter Fence

The diagram illustrates the site layout for a new community center compound. Key features include:


- New CC Compound:** A central area containing a **New CC**, **New Latrine**, **New Canopy**, and **Case Management Room**.
- Entrances:** A **Main Entrance** and an **Emergency Gate 3m** are marked with arrows.
- Boundaries and Fences:** The compound is enclosed by a **New Fence** (orange line) and a **New CC compound** (cyan line). Existing fences and gates are shown in red.
- Dimensions:** The compound is 22.0 m wide and 11.0 m deep. A 3.0 m wide emergency gate is located on the left side. A 5.50 m wide section is marked on the left. A 27.5 m dimension is shown along the top boundary. A 5.0 m dimension is marked near the main entrance.
- Surrounding Features:** To the right is an **Existing Women Recreational Center** with a **WRC Entrance** and a **Sec.** (security) area. Above the compound is an **Existing Generator** and **Expansion 2** area. A **Rough terrane** area is shown to the left of the compound.
- Manholes:** Three new manholes are indicated by square symbols with an 'X' inside.
- Job Site Boundaries:** Indicated by a purple dashed line.

01 SITE LAYOUT
A SCALE: 1:150


BLUMONT INC.

SHEET TITLE: SITE LAYOUT			SCALE: 1:150	RELATED SHEETS: 0
BLUEPRINT TITLE: COMMUNITY CENTER COMPOUND		DESIGN BY: Omar Ali		REVISIONS: 1
BLUEPRINT CODE: MEFA_2025_CCC	CONTRACT NO: SYRIA-TA-2024-XXXX	APPROVED BY: Ibrahim A. Ahmed		DATE: Aug, 11, 2025


A
1

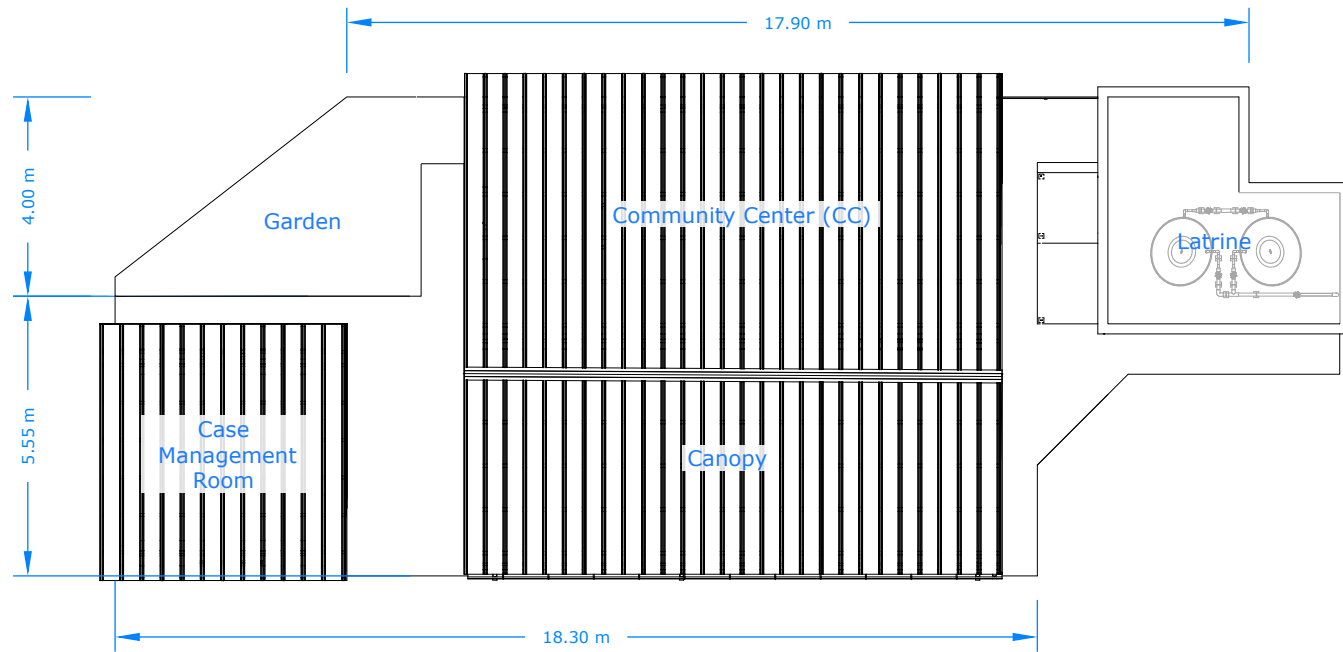


03
A CC COMPOUND TOP
SCALE: 1:150

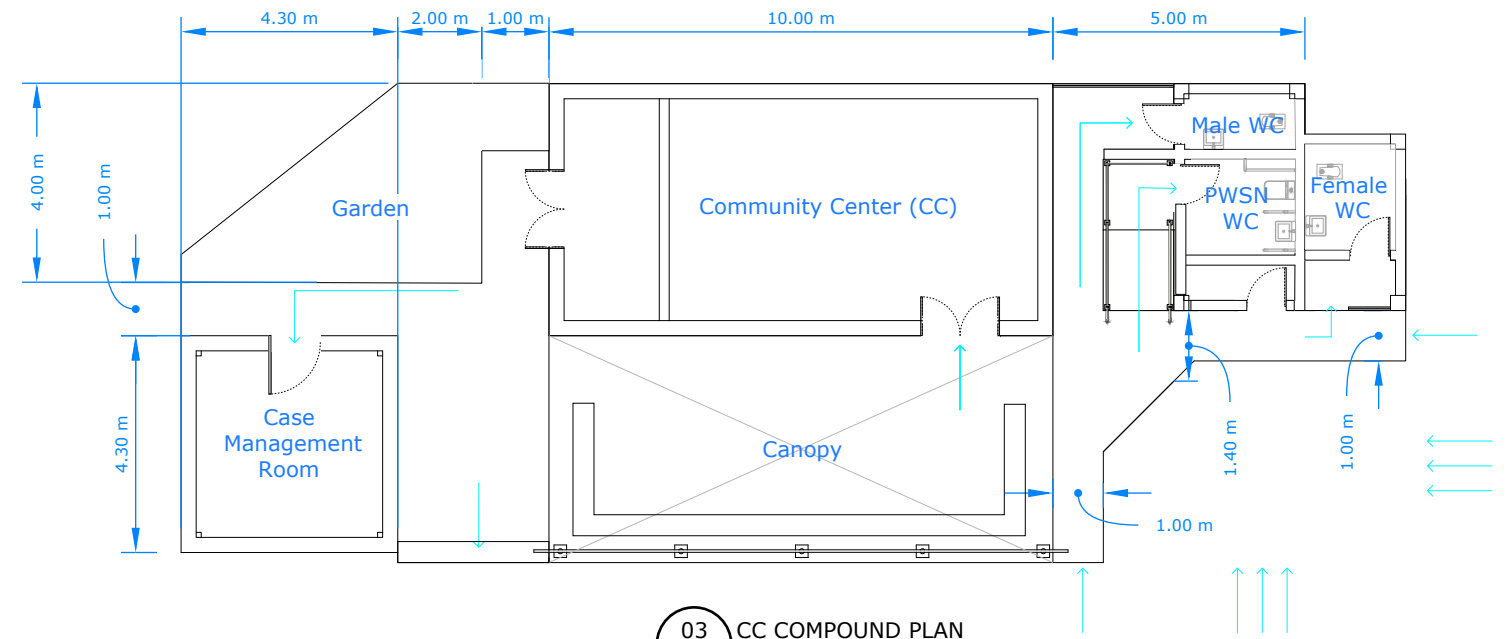

03
B CC COMPOUND PLAN
SCALE: 1:150

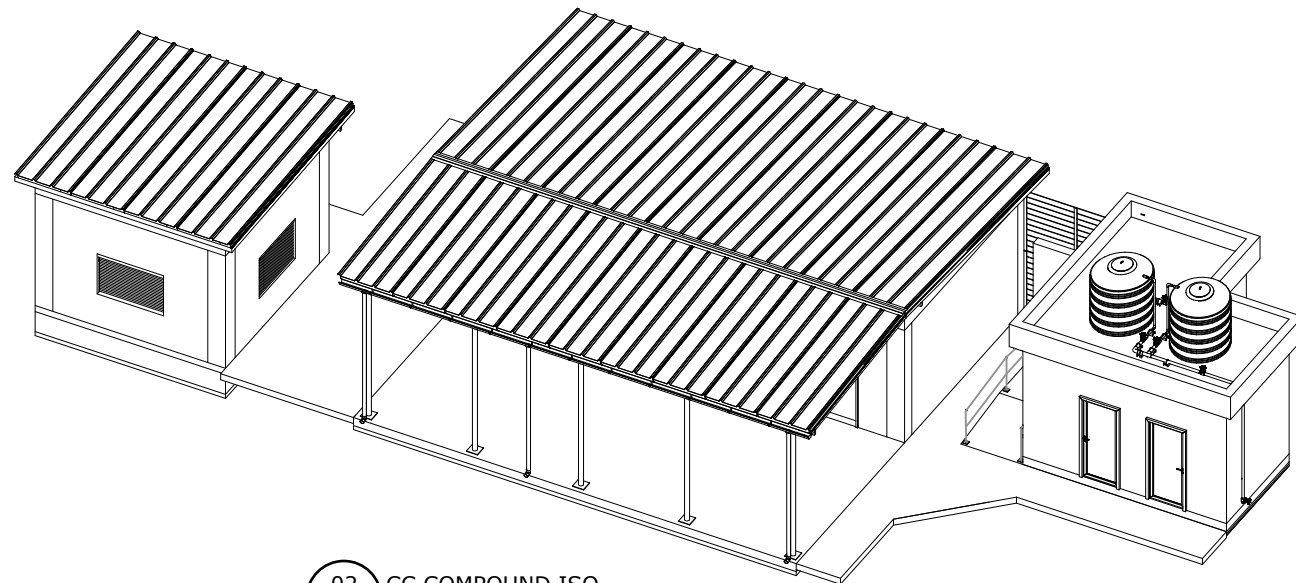


02
A CC COMPOUND ISO
SCALE: 1:150

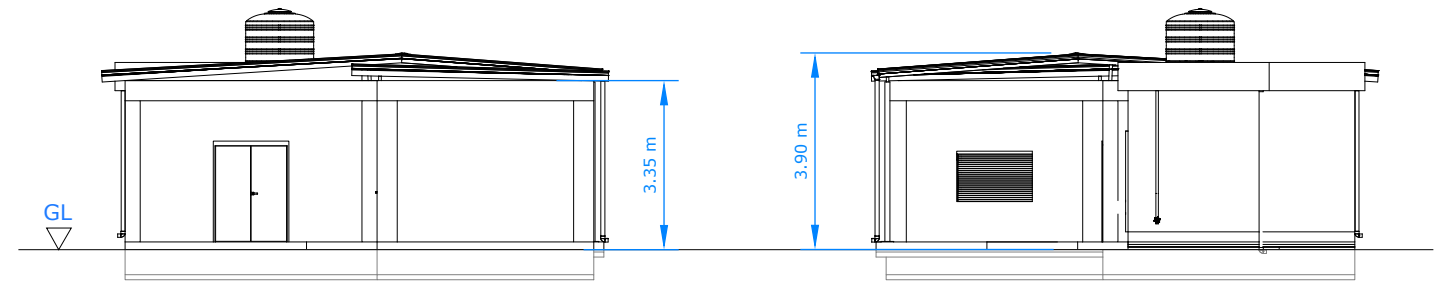

04
A CC COMPOUND NORTH
SCALE: 1:150

05
A CC COMPOUND SOUTH
SCALE: 1:150

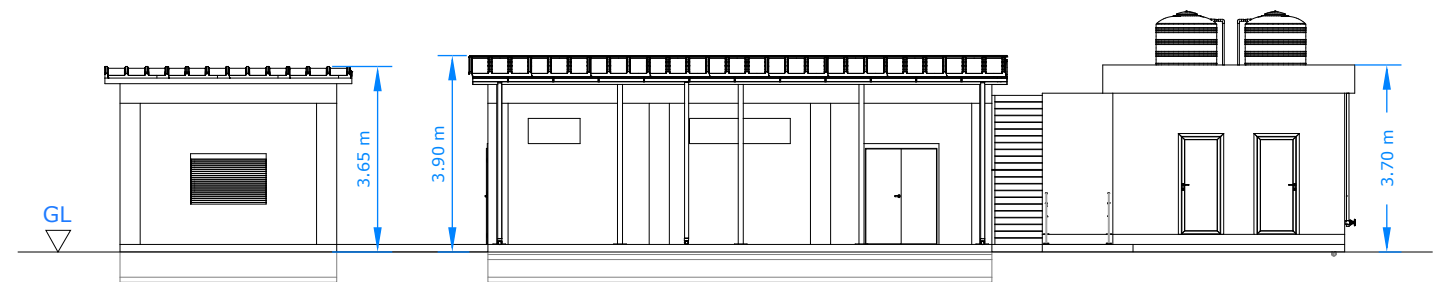

06
A CC COMPOUND WEST
SCALE: 1:150

BLUMONT INC.

SHEET TITLE: COMMUNITY CENTRE COMPOUND

SCALE: 1:150

RELATED SHEETS: 1

BLUEPRINT TITLE: COMMUNITY CENTER COMPOUND

DESIGN BY: Omar Ali

REVISIONS: 1


BLUEPRINT CODE: MEFA_2025_CCC

CONTRACT NO: SYRIA-TA-2024-XXXX


APPROVED BY: Ibrahim A. Ahmed

DATE: Aug, 11, 2025


A
2

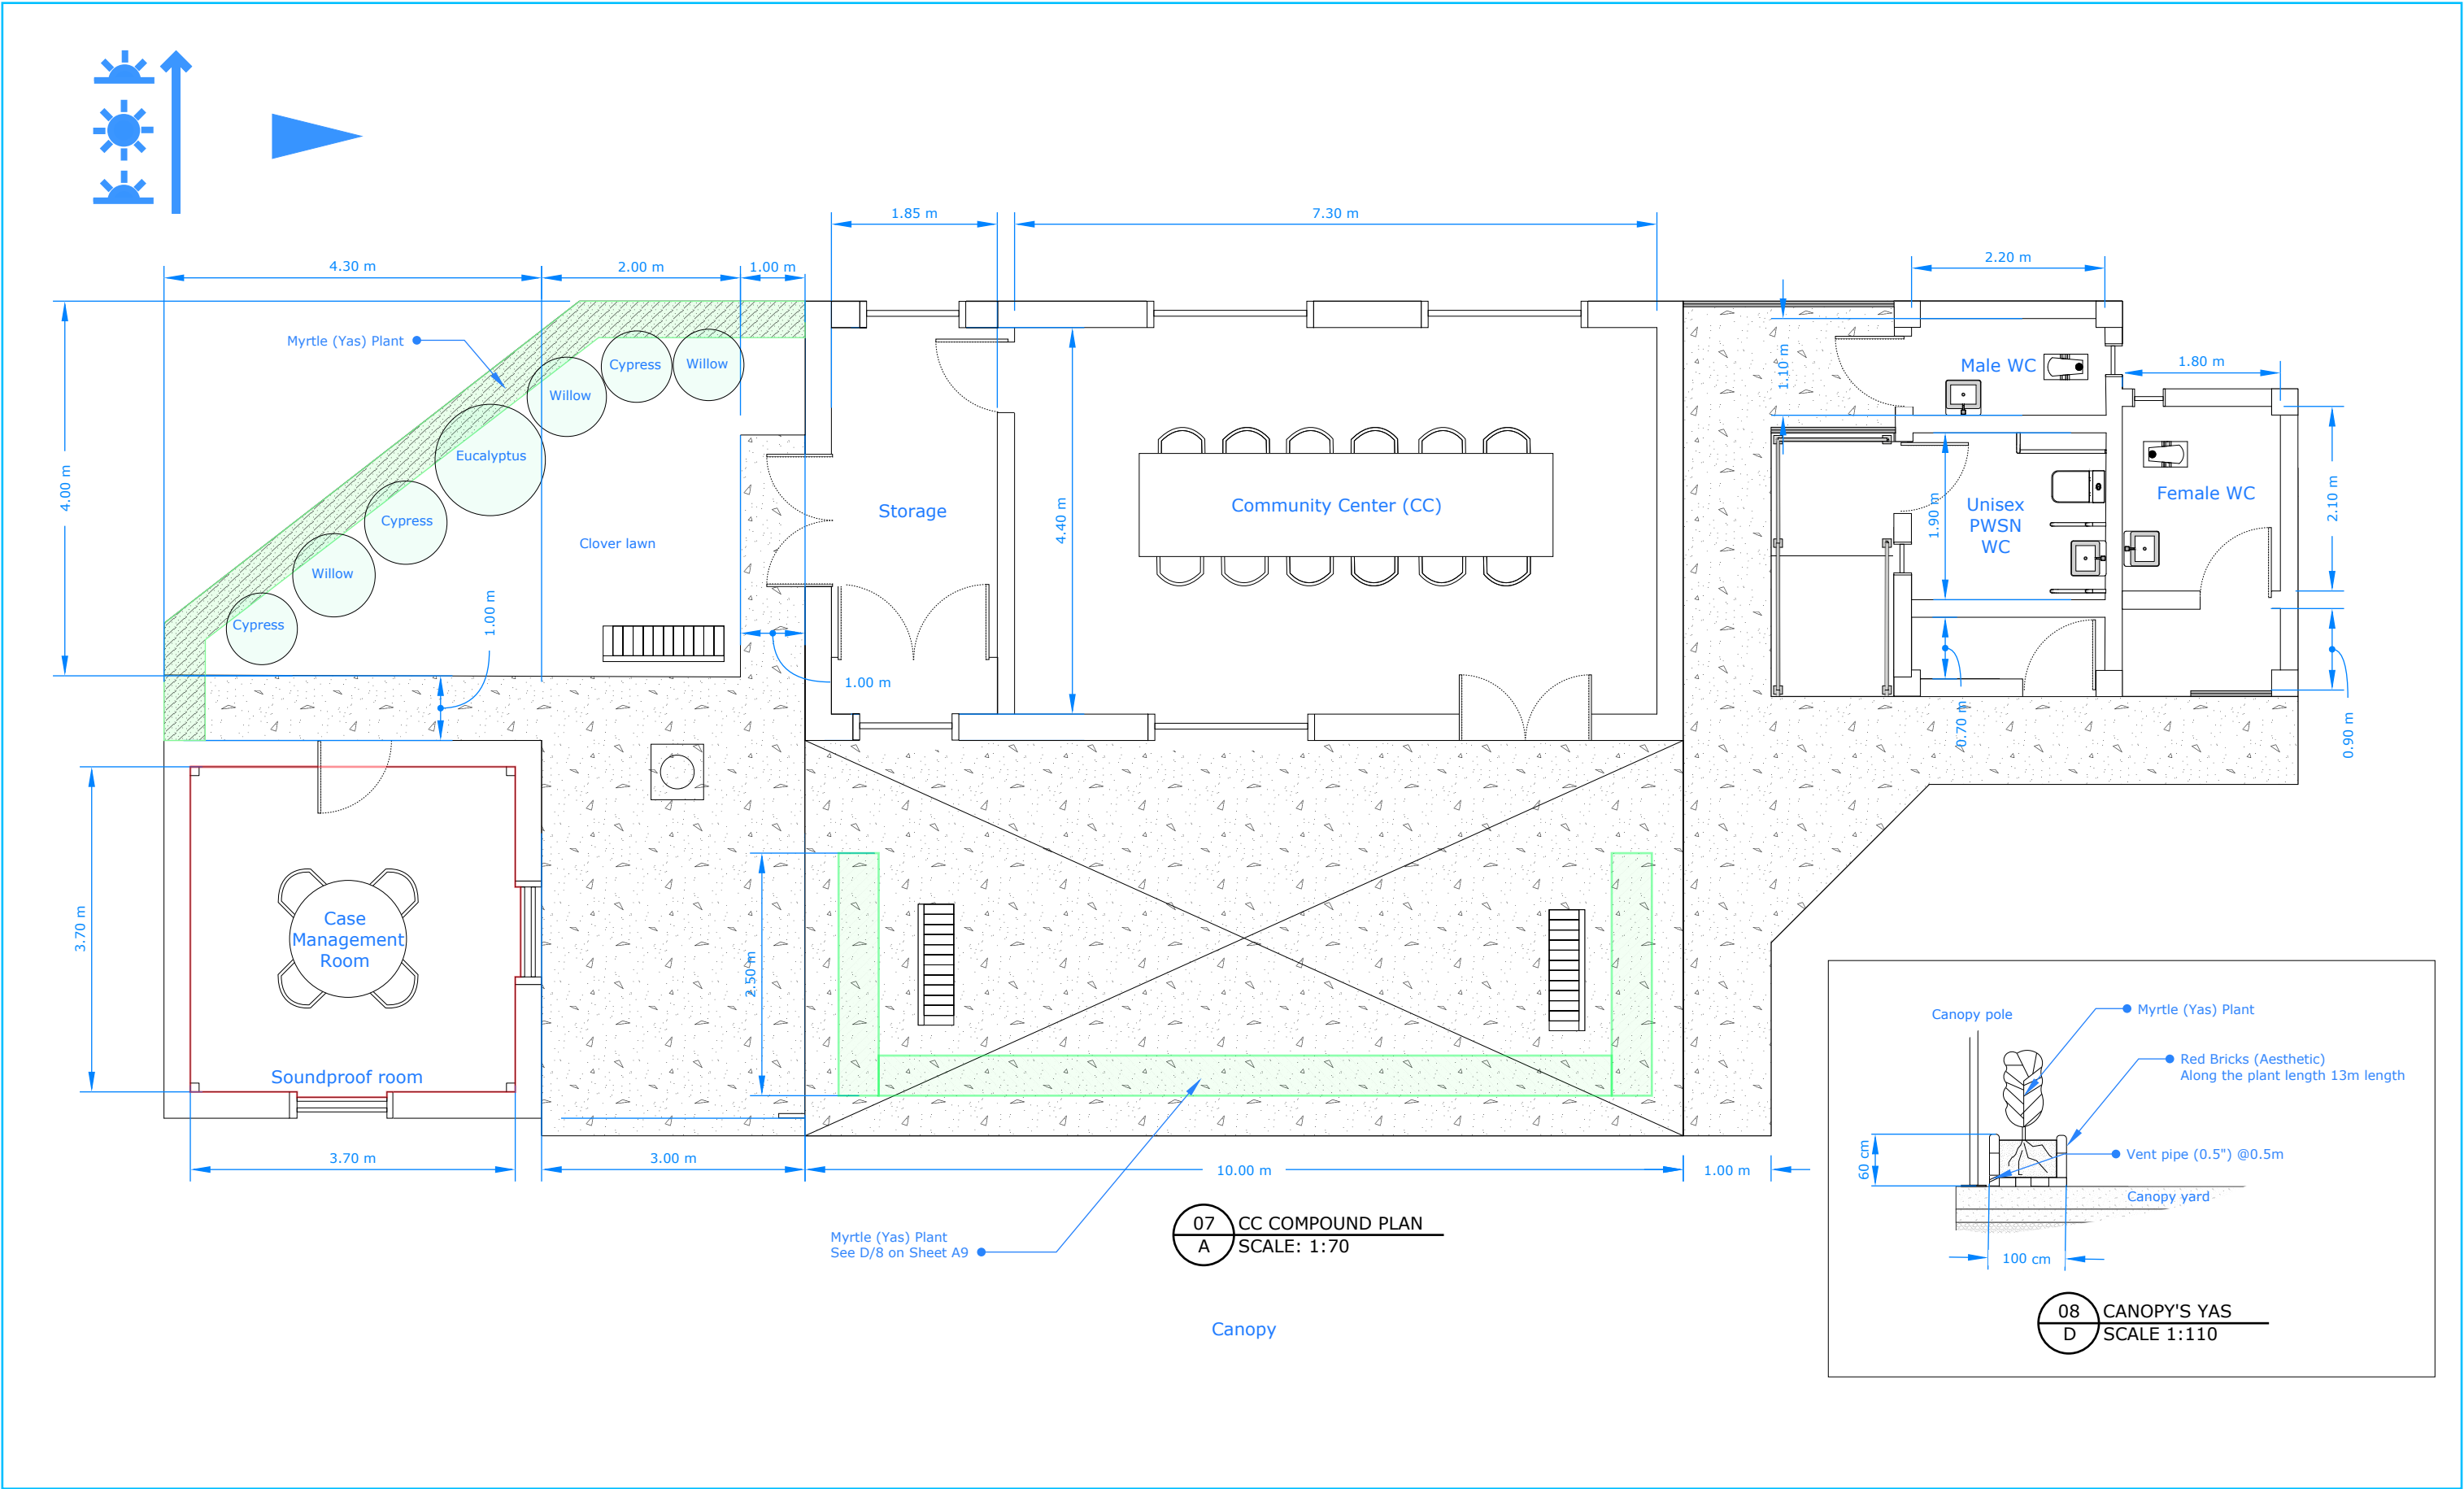


BLUMONT INC.	SHEET TITLE: COUMPOUND LAYOUT			SCALE: 1:70	RELATED SHEETS: 1
	BLUEPRINT TITLE: COMMUNITY CENTER COMPOUND		DESIGN BY: Omar Ali		REVISIONS: 1
	BLUEPRINT CODE: MEFA_2025_CCC	CONTRACT NO: SYRIA-TA-2024-XXXX	APPROVED BY: Ibrahim A. Ahmed		DATE: Aug, 11, 2025

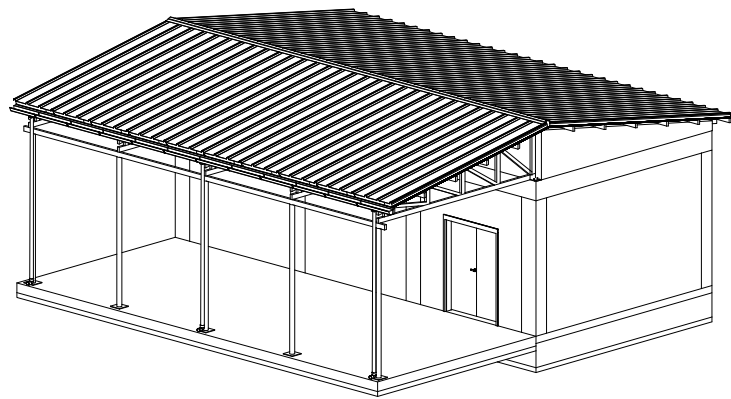


08 CC COMPOUND ISO
A SCALE: 1:150

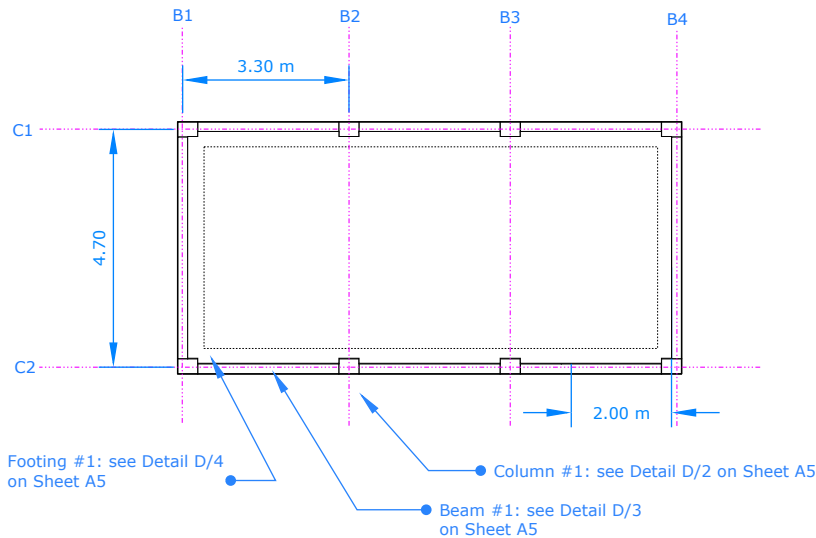


09 CC COMPOUND CONCRETE PLAN
A SCALE: 1:150

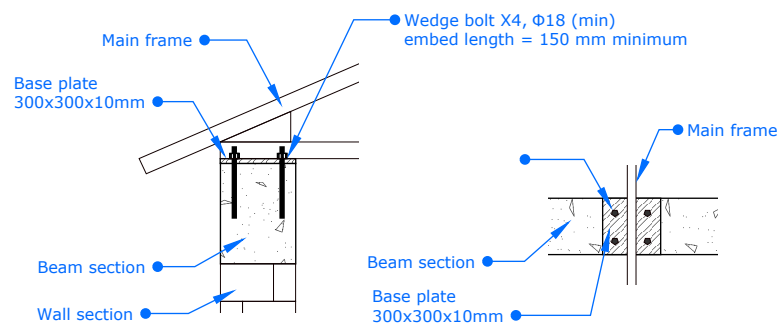


01 ANCHOR STATION
D NOT TO SCALE

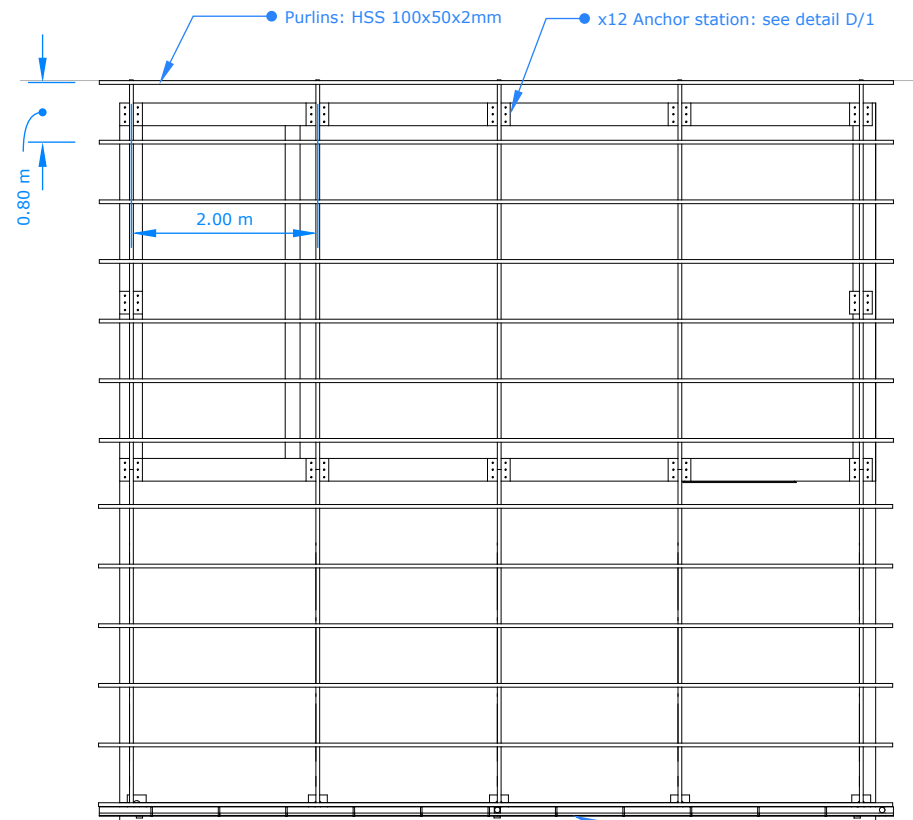


10 CCC ROOF STEEL PLAN
A SCALE: 1:100

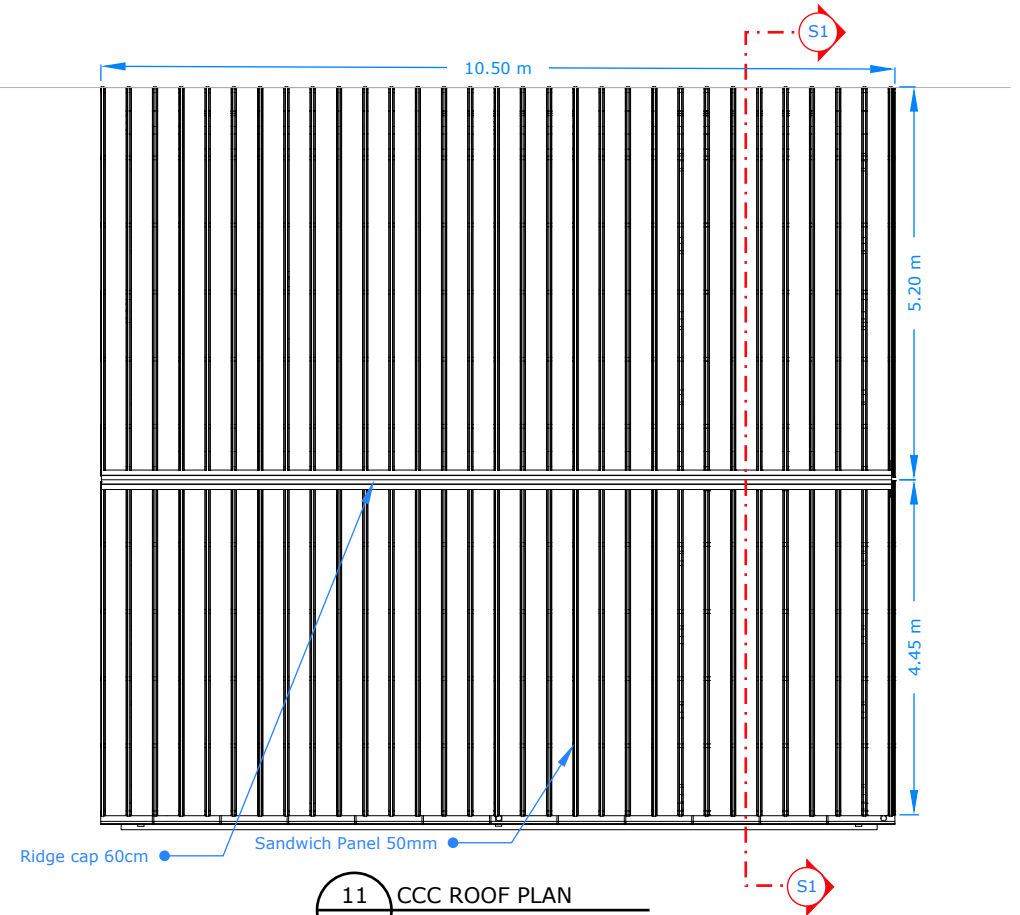

11 CCC ROOF PLAN
A SCALE: 1:100

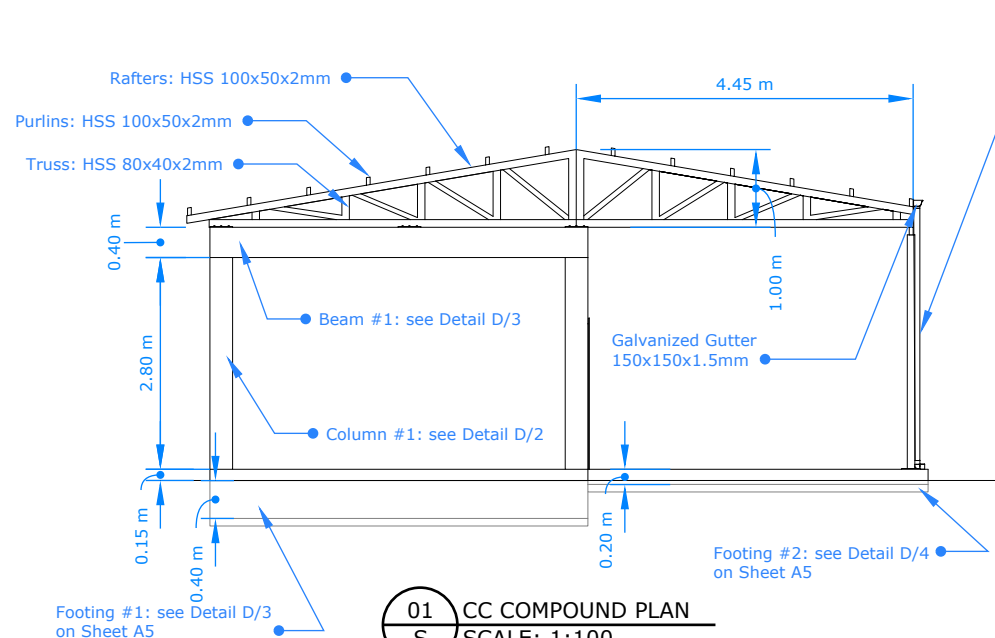

01 CC COMPOUND PLAN
S SCALE: 1:100

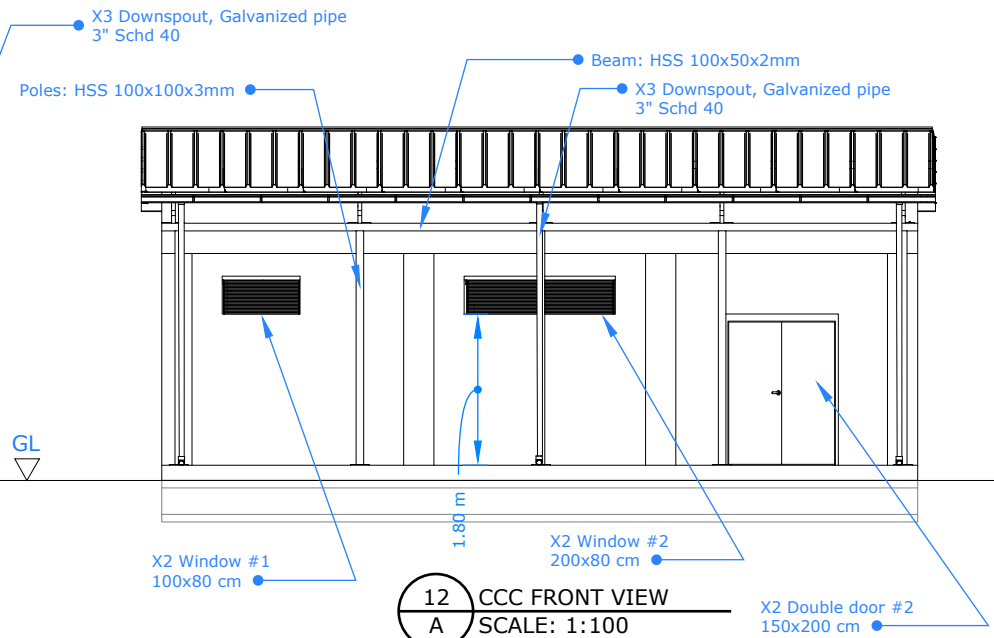

12 CCC FRONT VIEW
A SCALE: 1:100

BLUMONT INC.

SHEET TITLE: COMMUNITY CENTER BUILDING DESIGN

SCALE: MSC.

RELATED SHEETS: 1,2,3

BLUEPRINT TITLE: COMMUNITY CENTER COMPOUND

DESIGN BY: Omar Ali

REVISIONS: 1






BLUEPRINT CODE: MEFA_2025_CCC

CONTRACT NO: SYRIA-TA-2024-XXXX

APPROVED BY: Ibrahim A. Ahmed

DATE: Aug, 11, 2025

A
4

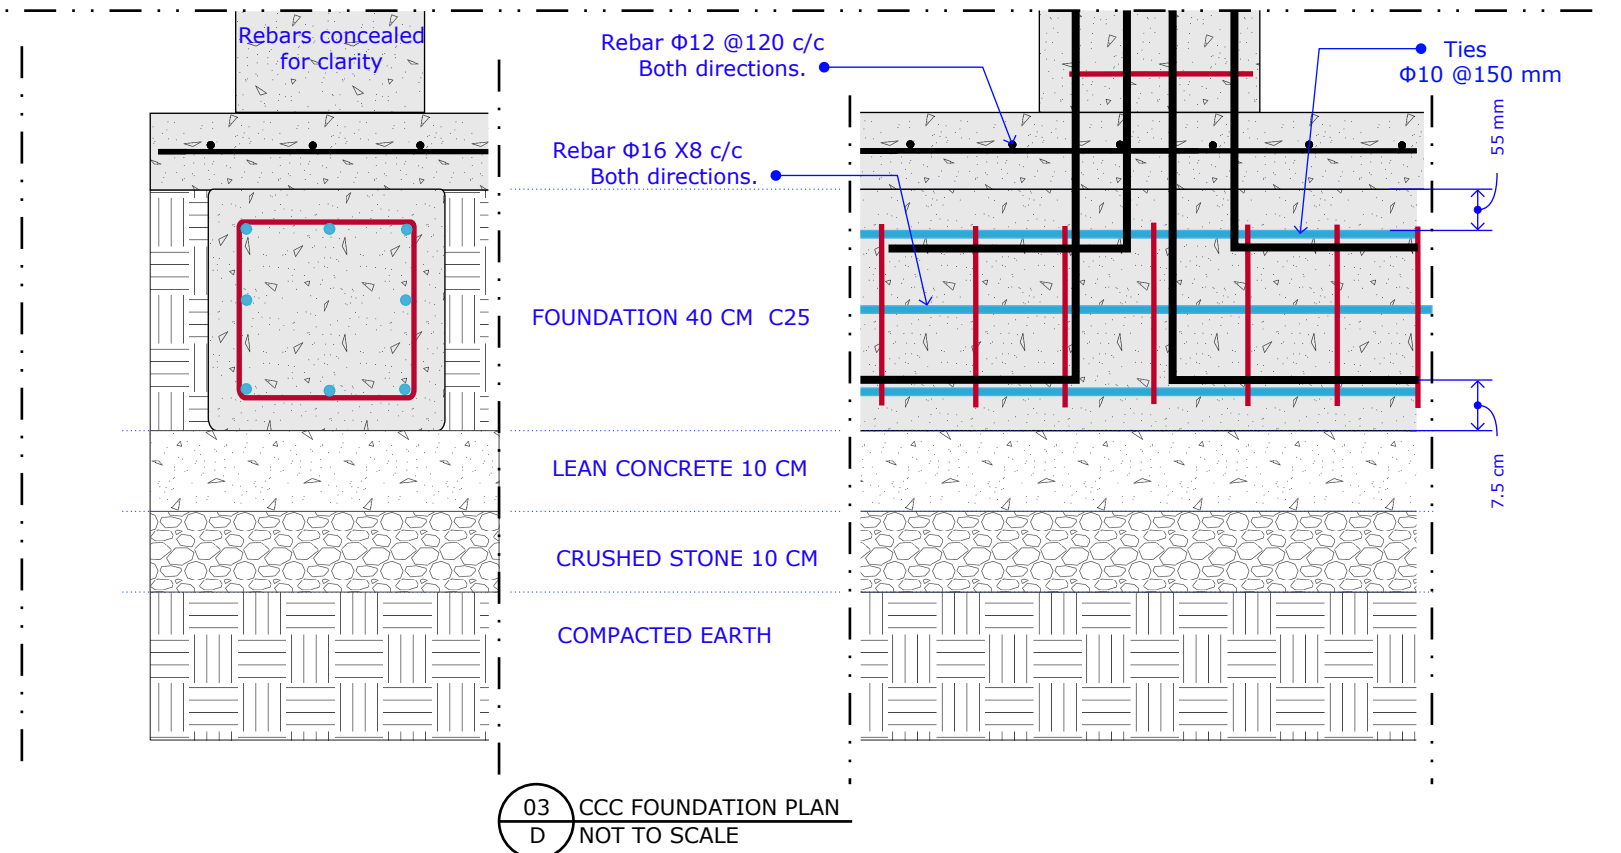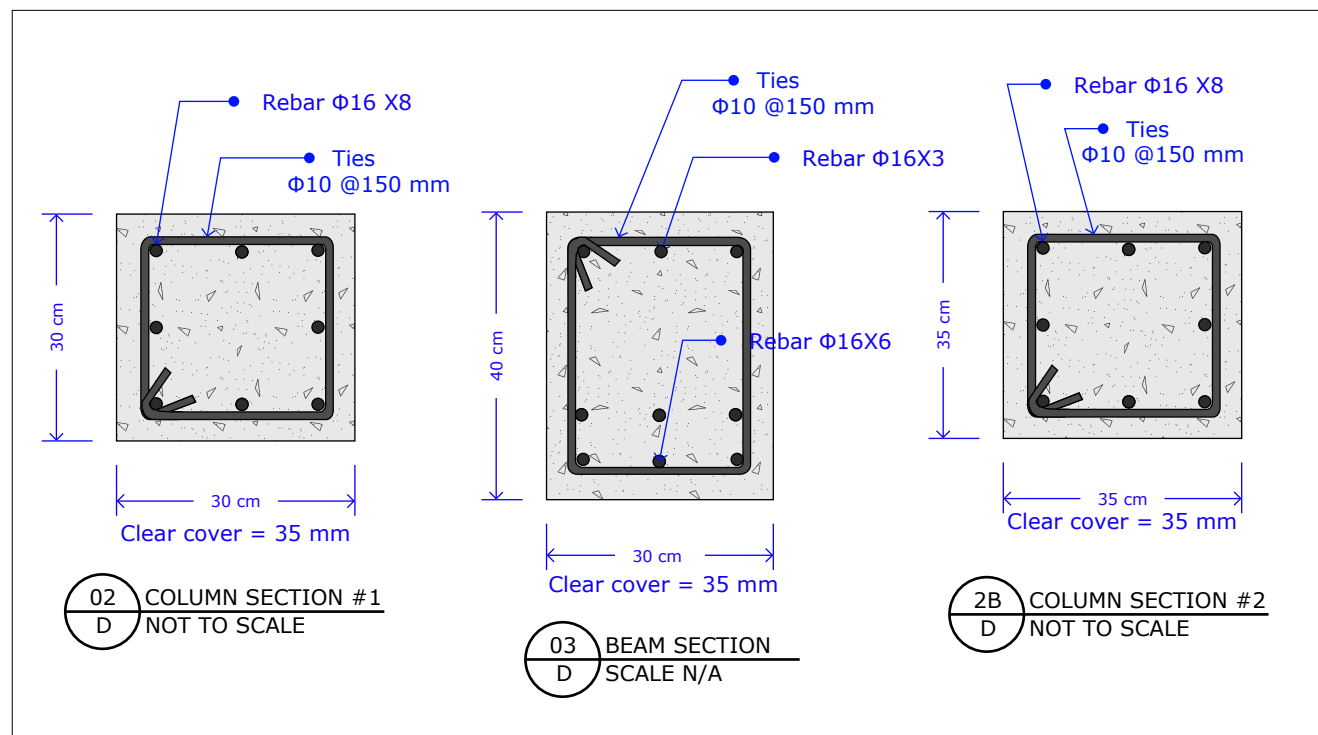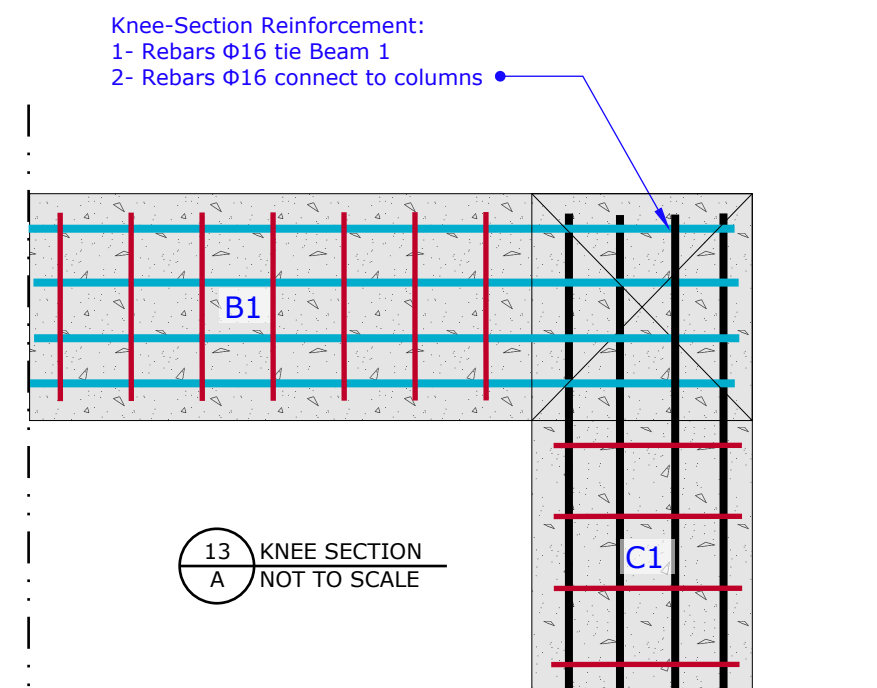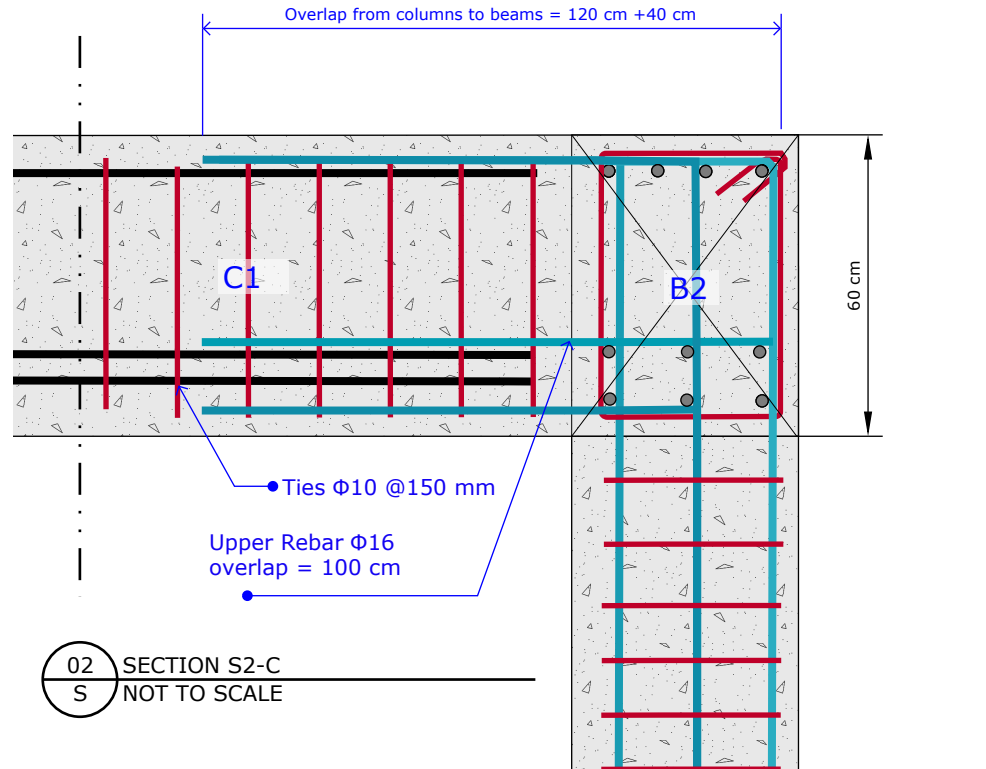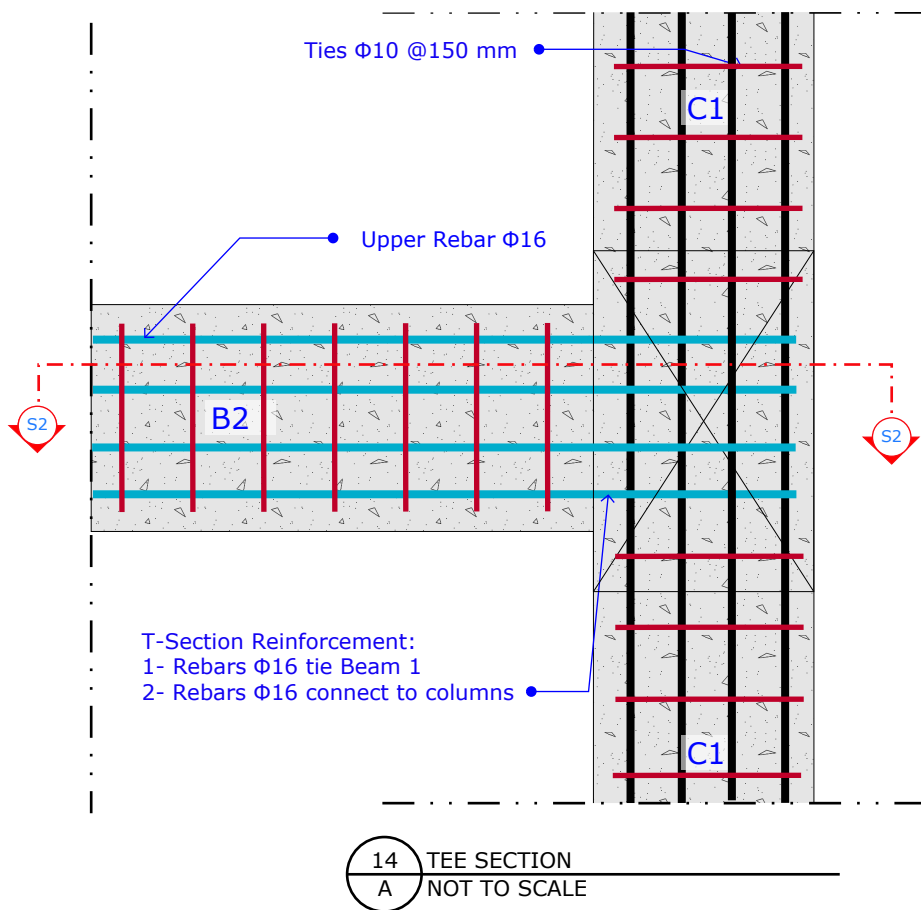

BLUMONT INC.

SHEET TITLE: STRUCTURAL CONCRETE DETAILS

NOT TO SCALE

RELATED SHEETS: 1,2,3

BLUEPRINT TITLE: COMMUNITY CENTER COMPOUND

DESIGN BY: Omar Ali

REVISIONS: 1


BLUEPRINT CODE: MEFA_2025_CCC

CONTRACT NO: SYRIA-TA-2024-XXXX


APPROVED BY: Ibrahim A. Ahmed

DATE: Aug, 11, 2025


A
5

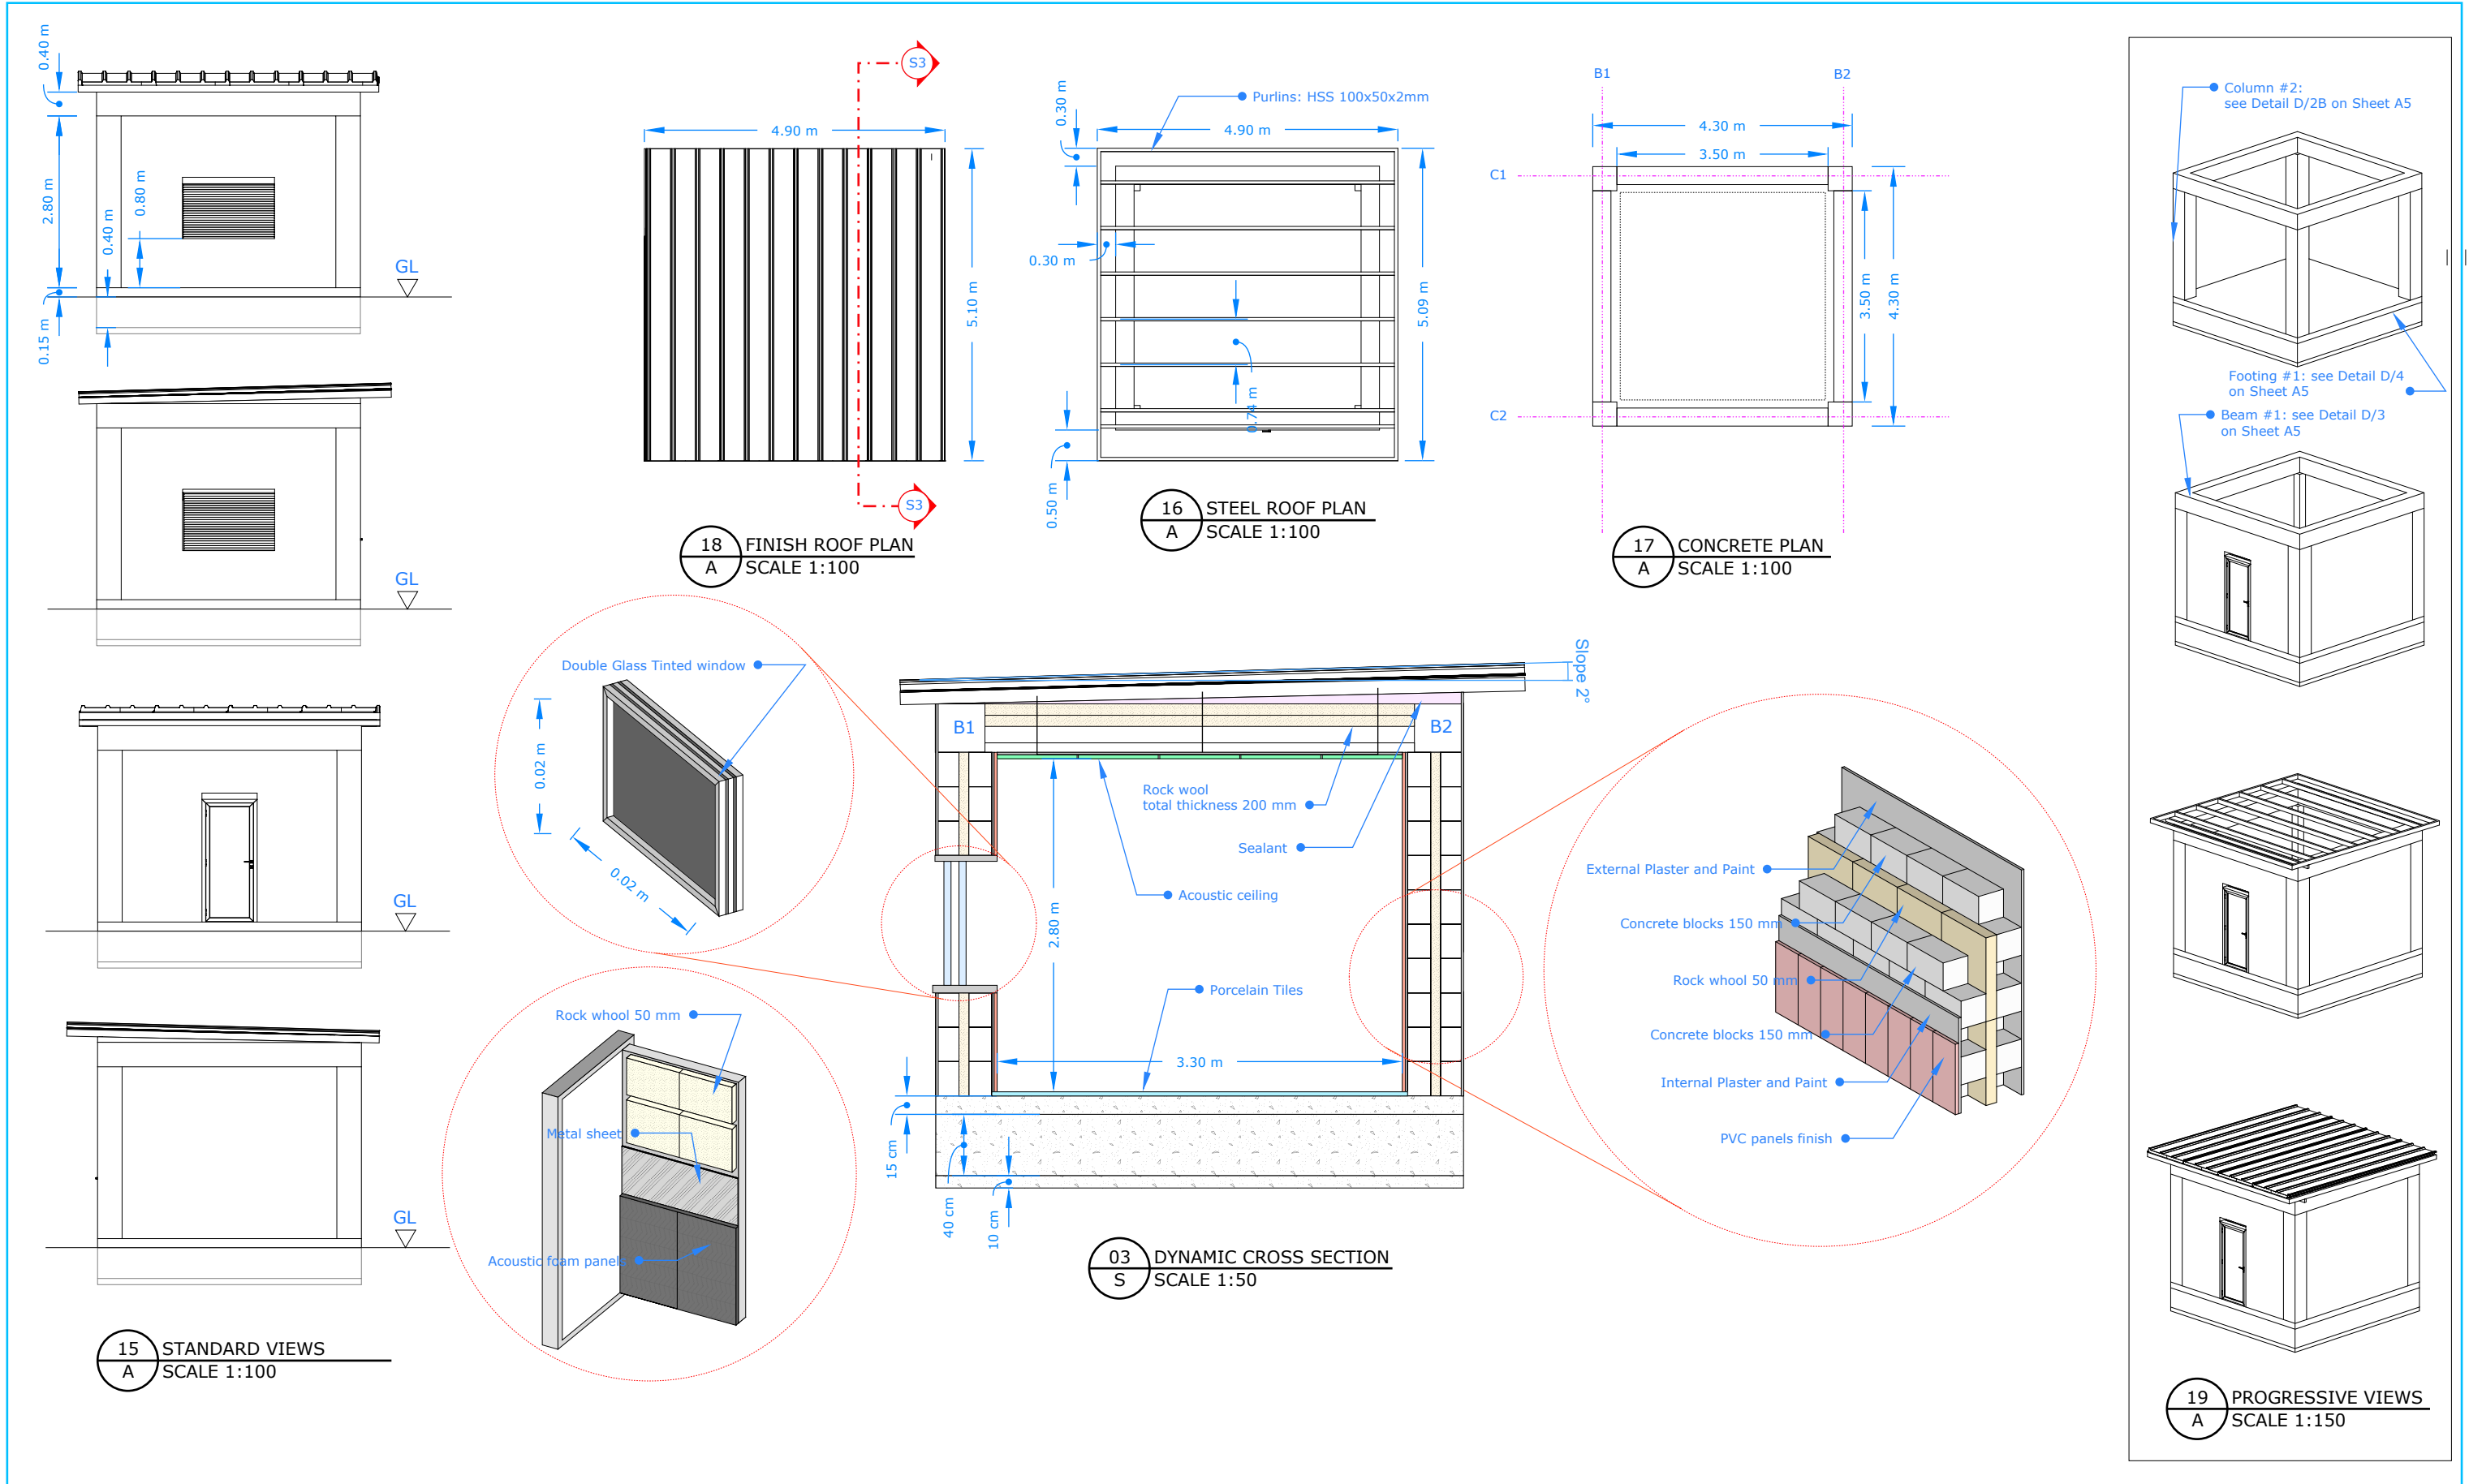


BLUMONT INC.	SHEET TITLE: CASE MANAGMENT ROOM DESIGN		SCALE: 1:100, MSC.	RELATED SHEETS: 1,2,3
	BLUEPRINT TITLE: COMMUNITY CENTER COMPOUND		DESIGN BY: Omar Ali	REVISIONS: 1
	BLUEPRINT CODE: MEFA_2025_CCC	CONTRACT NO: SYRIA-TA-2024-XXXX	APPROVED BY: Ibrahim A. Ahmed	DATE: Aug, 11, 2025

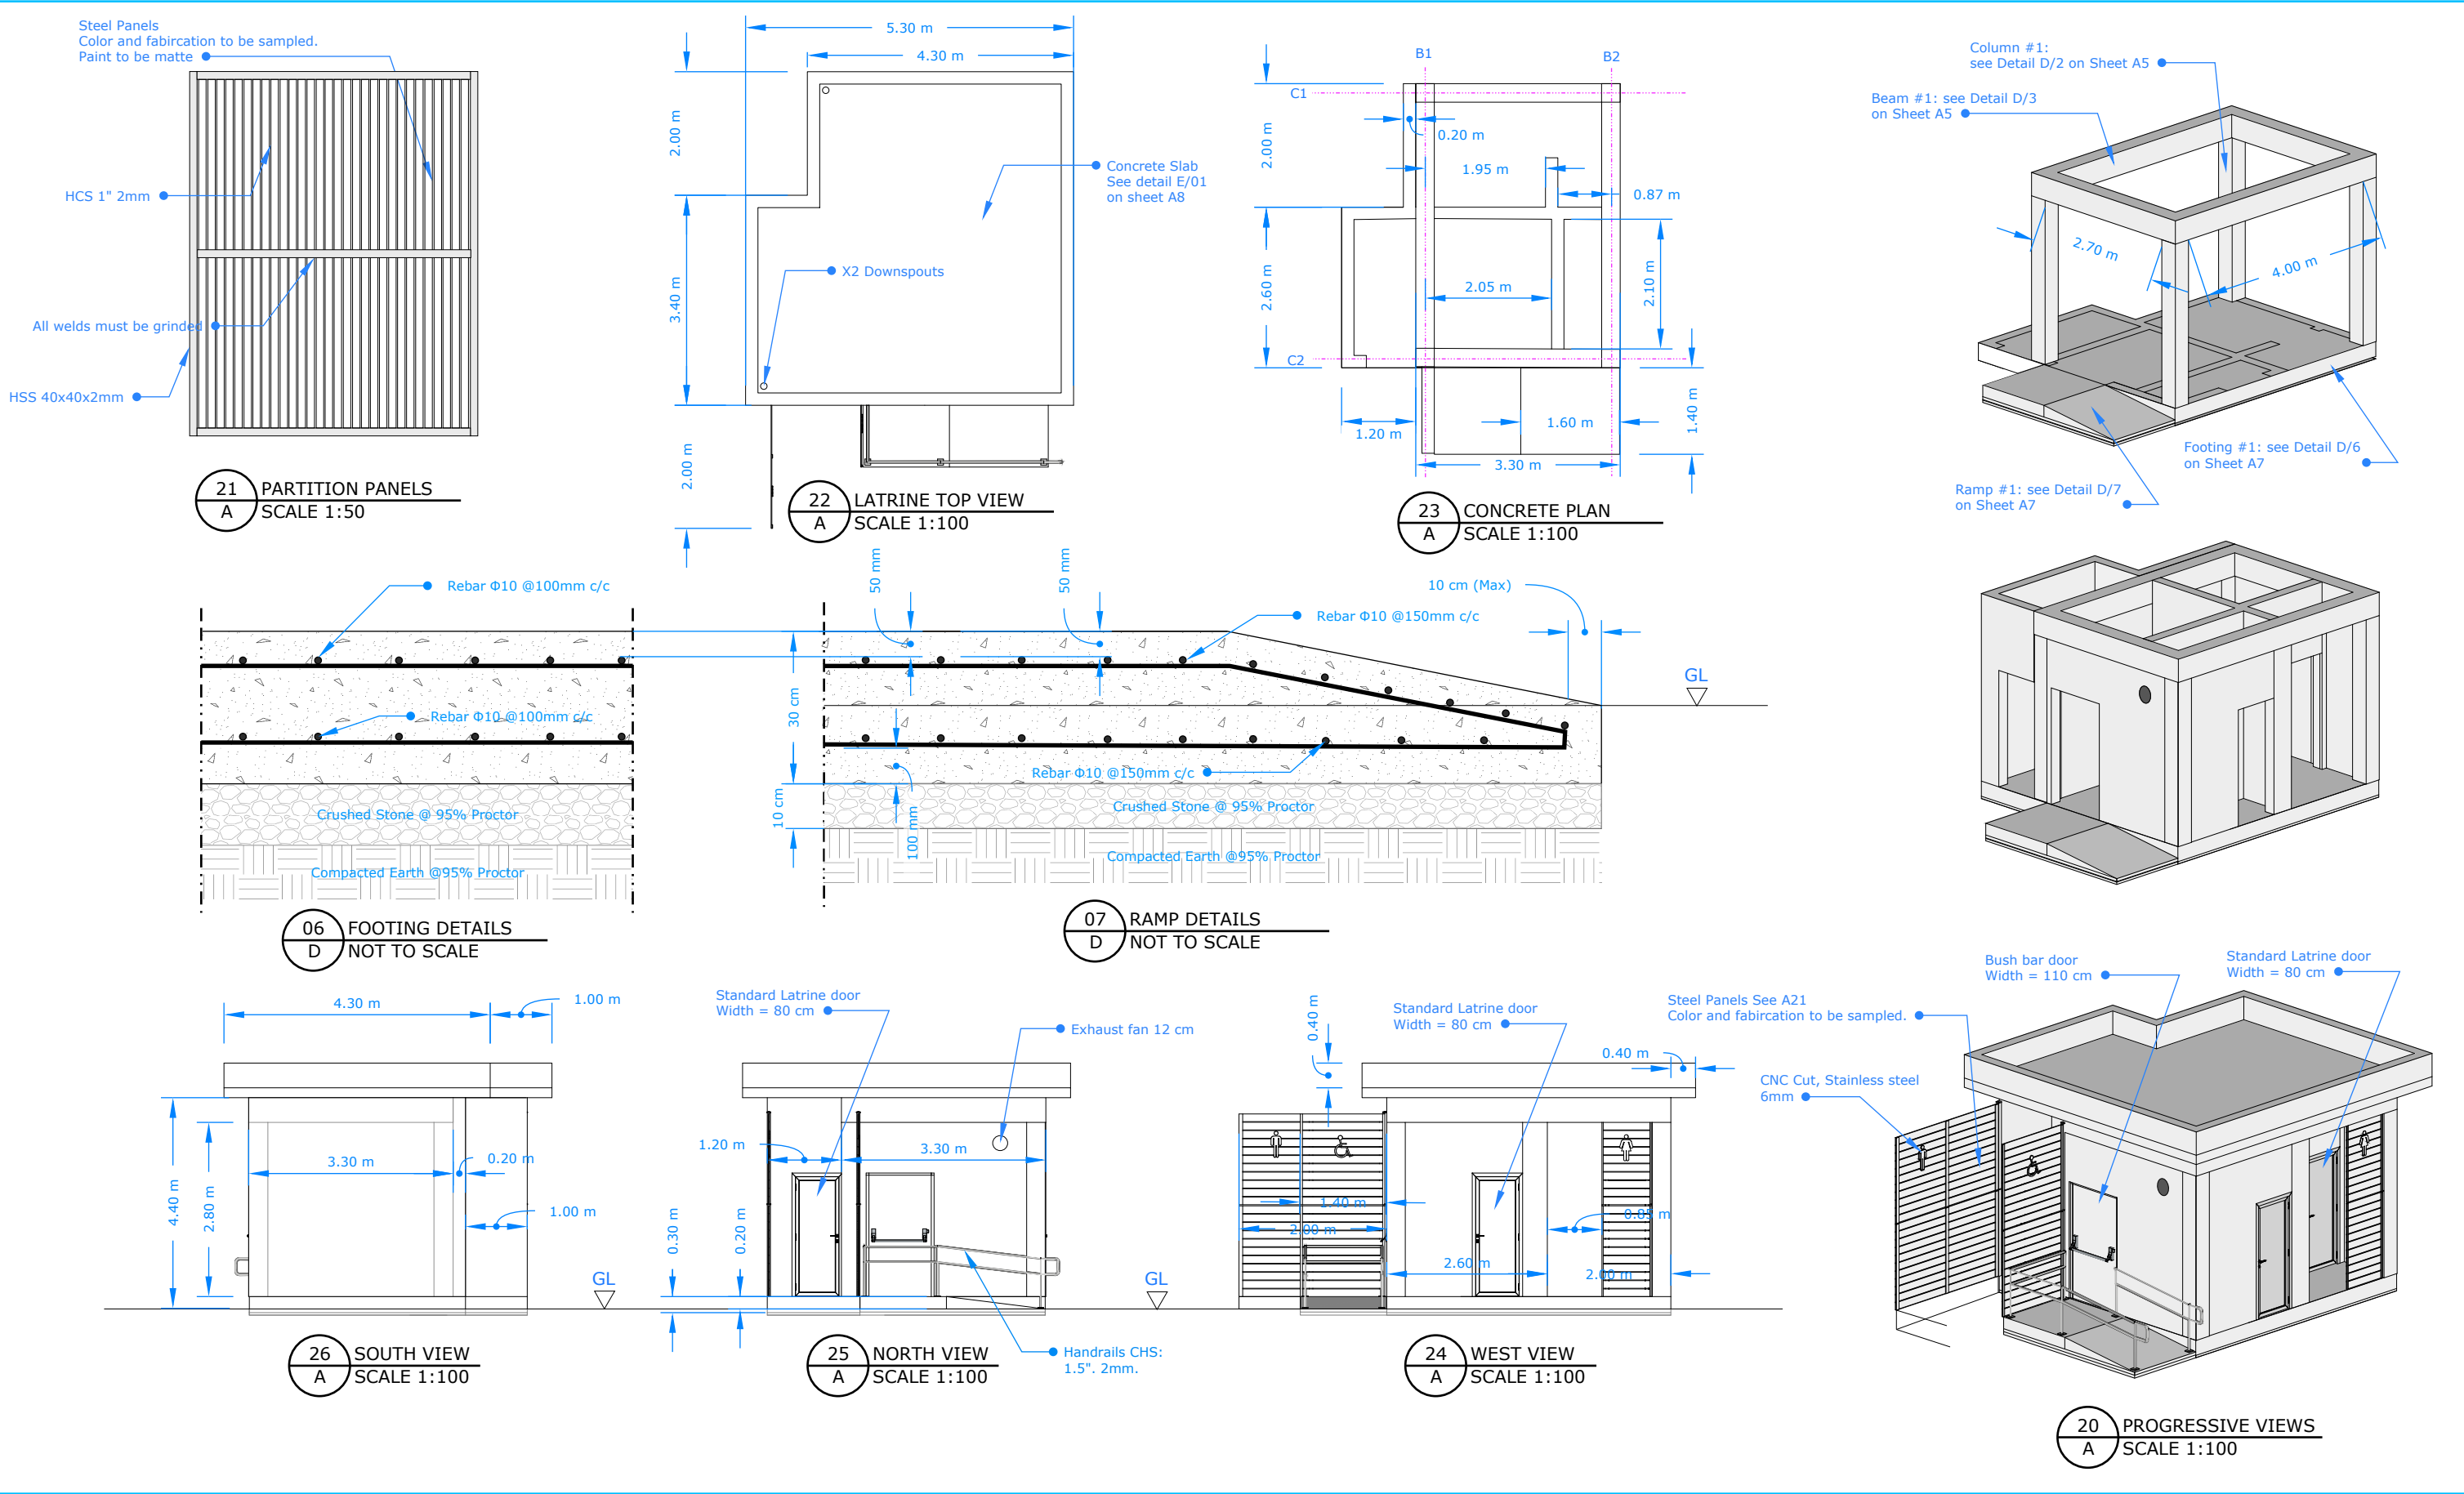


BLUMONT INC.	SHEET TITLE: COUMPOUND LATRINE DESIGN			SCALE: 1:100	RELATED SHEETS: 1,2,3
	BLUEPRINT TITLE: COMMUNITY CENTER COMPOUND		DESIGN BY: Omar Ali		REVISIONS: 1
	BLUEPRINT CODE: MEFA_2025_CCC	CONTRACT NO: SYRIA-TA-2024-XXXX	APPROVED BY: Ibrahim A. Ahmed		DATE: Aug, 11, 2025

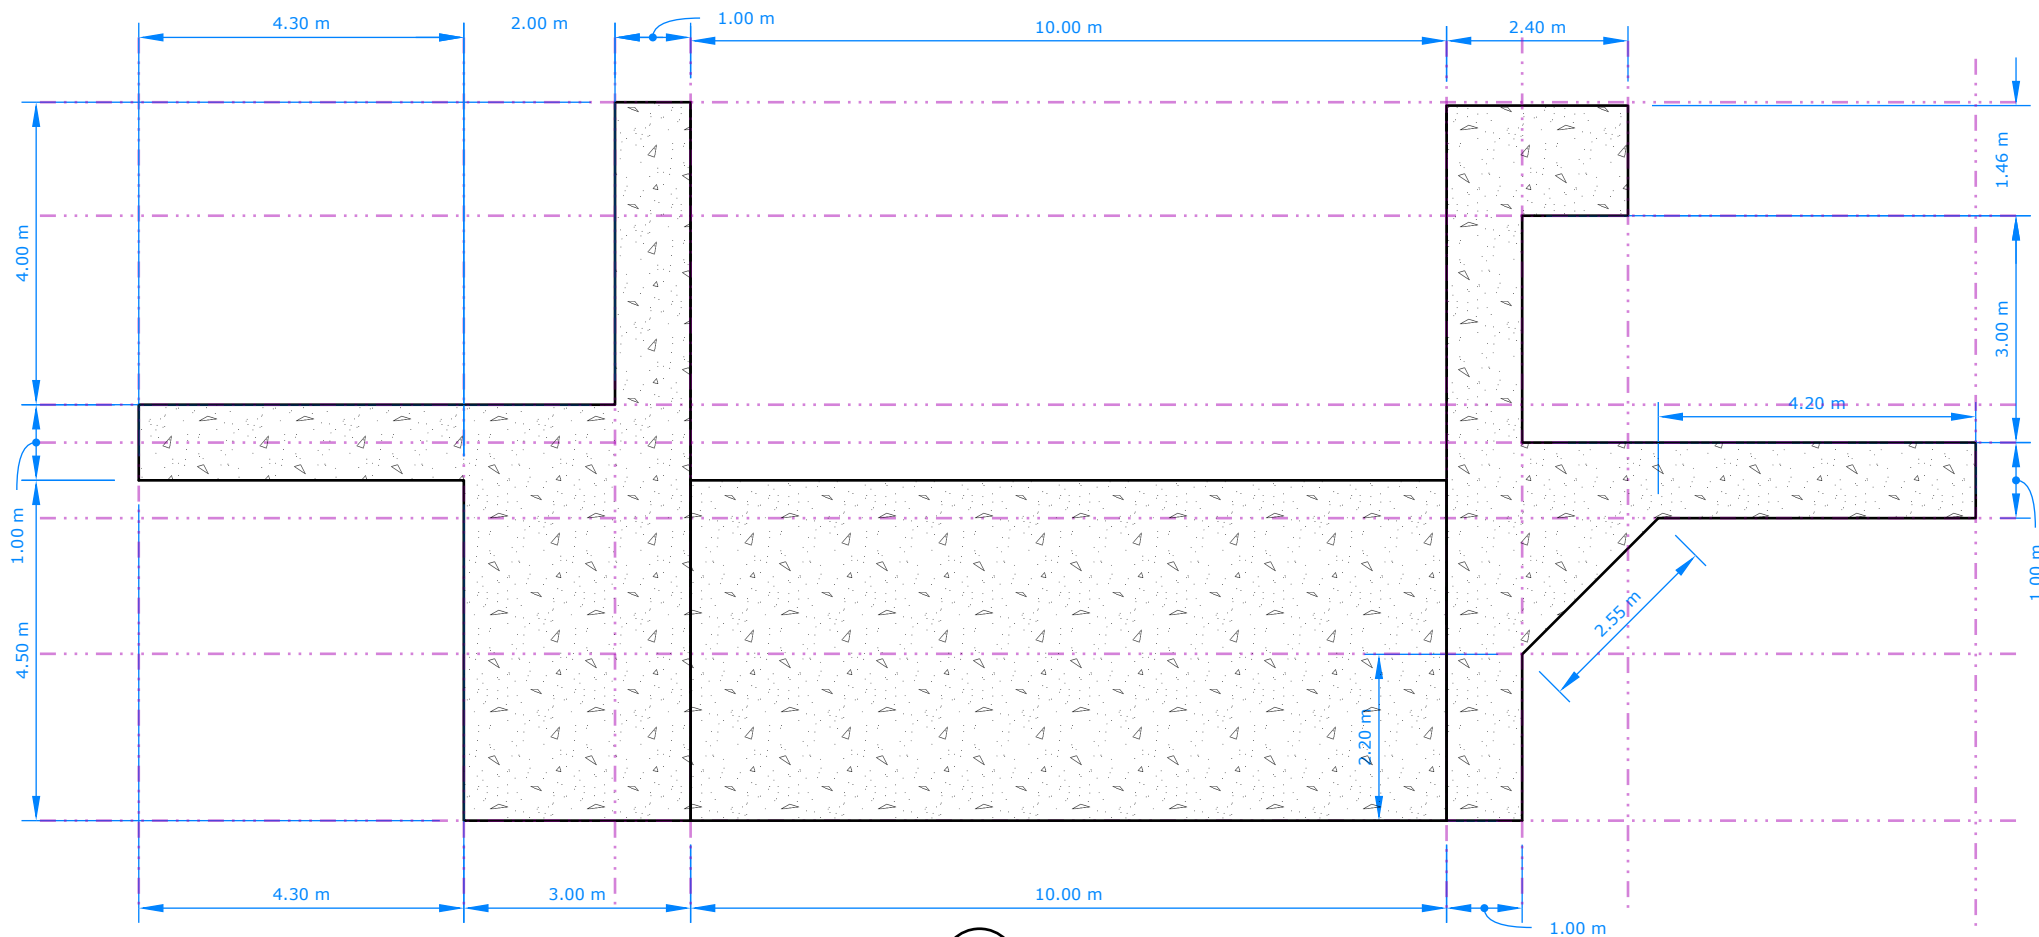


28
A
WALKWAY PLAN
SCALE 1:100

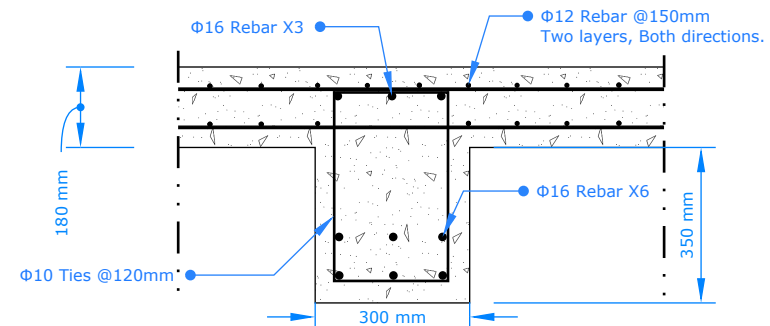


01
E
LAATRINE SLAB
NOT TO SCALE

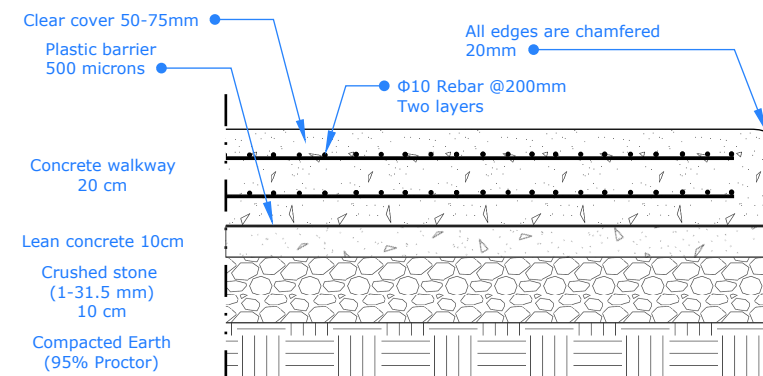


27
A
WALKWAY DETAILS
NOT TO SCALE

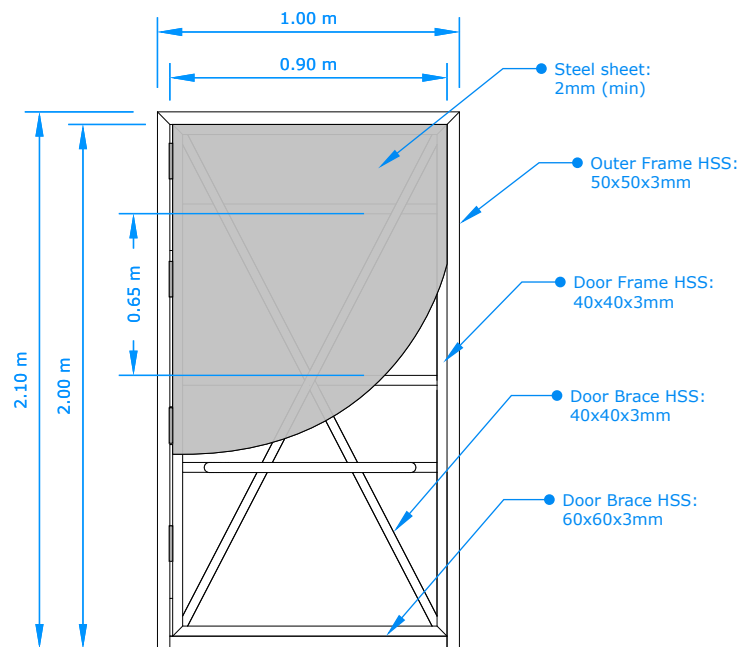


03
B0
STANDARD DOOR
SCALE 1:30

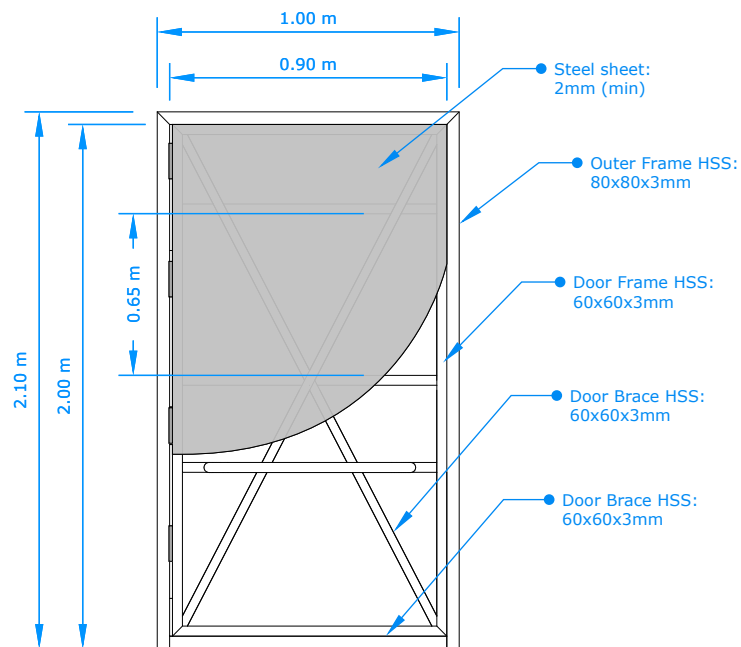

03
B
CASE MANAGEMENT DOOR
SCALE 1:30

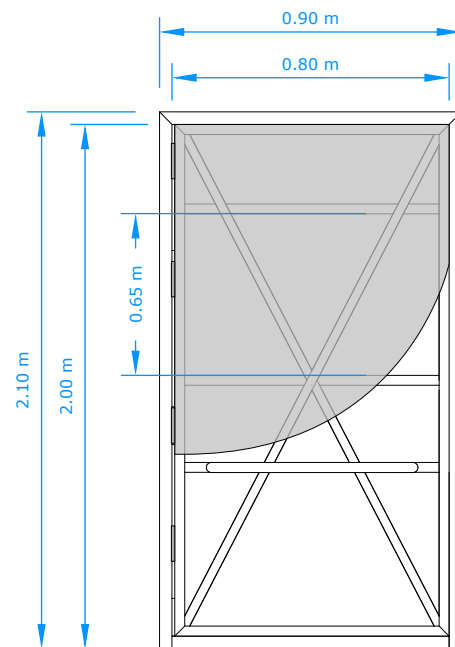

02
B
WC / STORAGE DOOR
SCALE 1:30

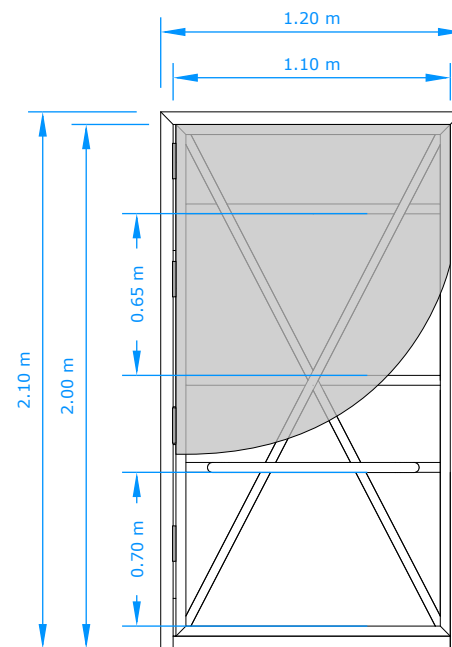

01
B
PWSN WC DOOR
SCALE 1:30

BLUMONT INC.

SHEET TITLE: WALKWAY AND DOORS DEISGNS

SCALE: 1:100, 1:30

RELATED SHEETS: 1,2,3

BLUEPRINT TITLE: COMMUNITY CENTER COMPOUND

DESIGN BY: Omar Ali

REVISIONS: 1


BLUEPRINT CODE: MEFA_2025_CCC

CONTRACT NO: SYRIA-TA-2024-XXXX

APPROVED BY: Ibrahim A. Ahmed


DATE: Aug, 11, 2025

A
8

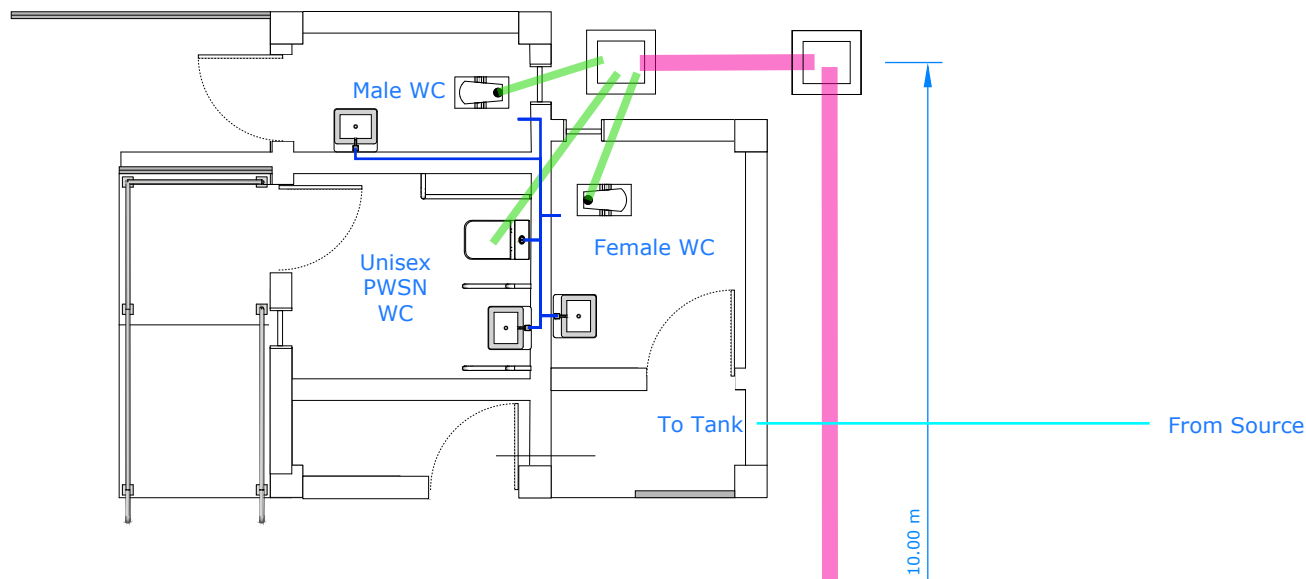

30 PLUMBING PLAN
A SCALE 1:70

PIPE SCHEDULE	
PIPE TYPES	Schedule
1" PVC Cold water PPR In-wall	SCH40
3/4" PVC Cold water PPR In-wall	SCH40
4" UPVC Blackwater line	SCH80
6" UPVC Blackwater line	SCH80

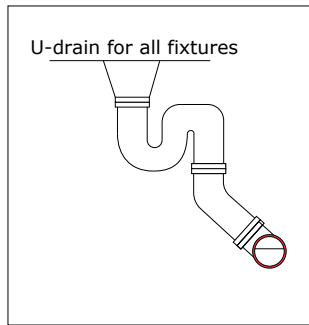


Plumbing notes:

Slope of all pipes must be 2.08% no larger nor smaller slope is permitted.


All connection angel must be below 30 Degrees.

Sewer pipes are PVC pipes that conforms to ASTM D 3034, ASTM D 1784 and cell Class 12454 B. Sewer pipes to be tested according to UBPPA UNI-B-6.

Wastewater sewer system is designed according to the American Society of Plumbing Engineers (ASPE) and the international plumbing code (IPC).

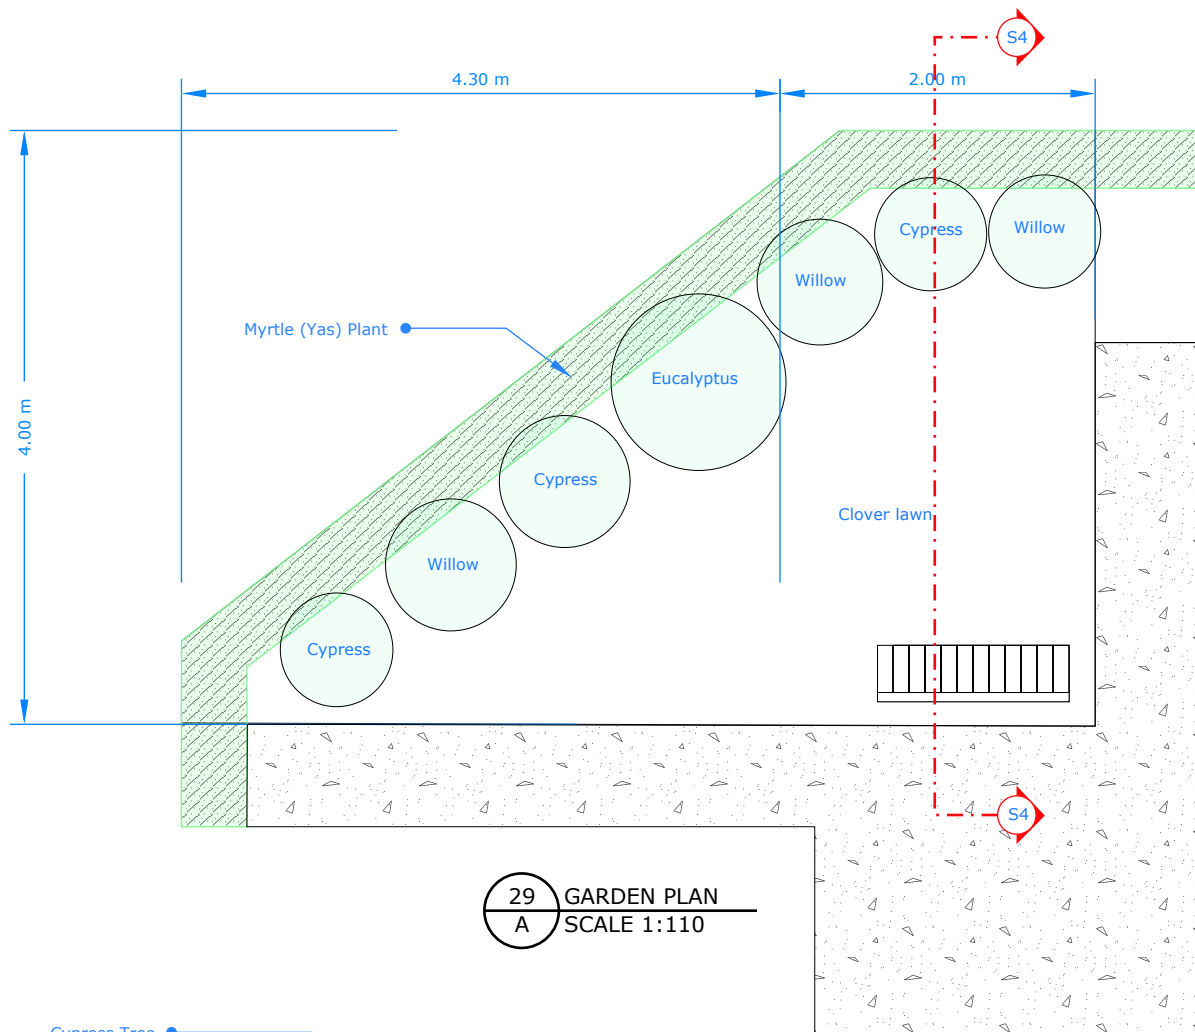

29 GARDEN PLAN
A SCALE 1:110

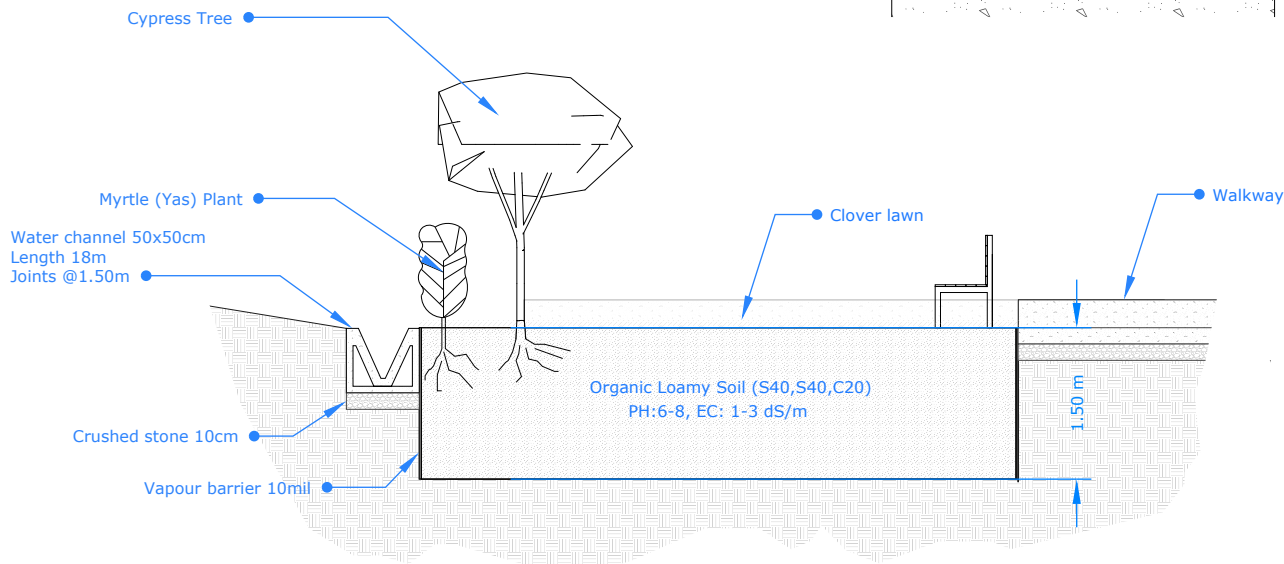

04 GARDEN SECTION
S SCALE 1:110

BLUMONT INC.

SHEET TITLE: COUMPOUND LAYOUT

SCALE: 1:70

RELATED SHEETS: 1,2,3

BLUEPRINT TITLE: COMMUNITY CENTER COMPOUND

DESIGN BY: Omar Ali




REVISIONS: 1

BLUEPRINT CODE: MEFA_2025_CCC

CONTRACT NO: SYRIA-TA-2024-XXXX

APPROVED BY: Ibrahim A. Ahmed

DATE: Aug, 11, 2025

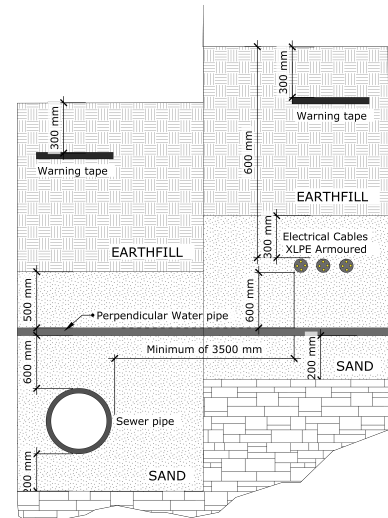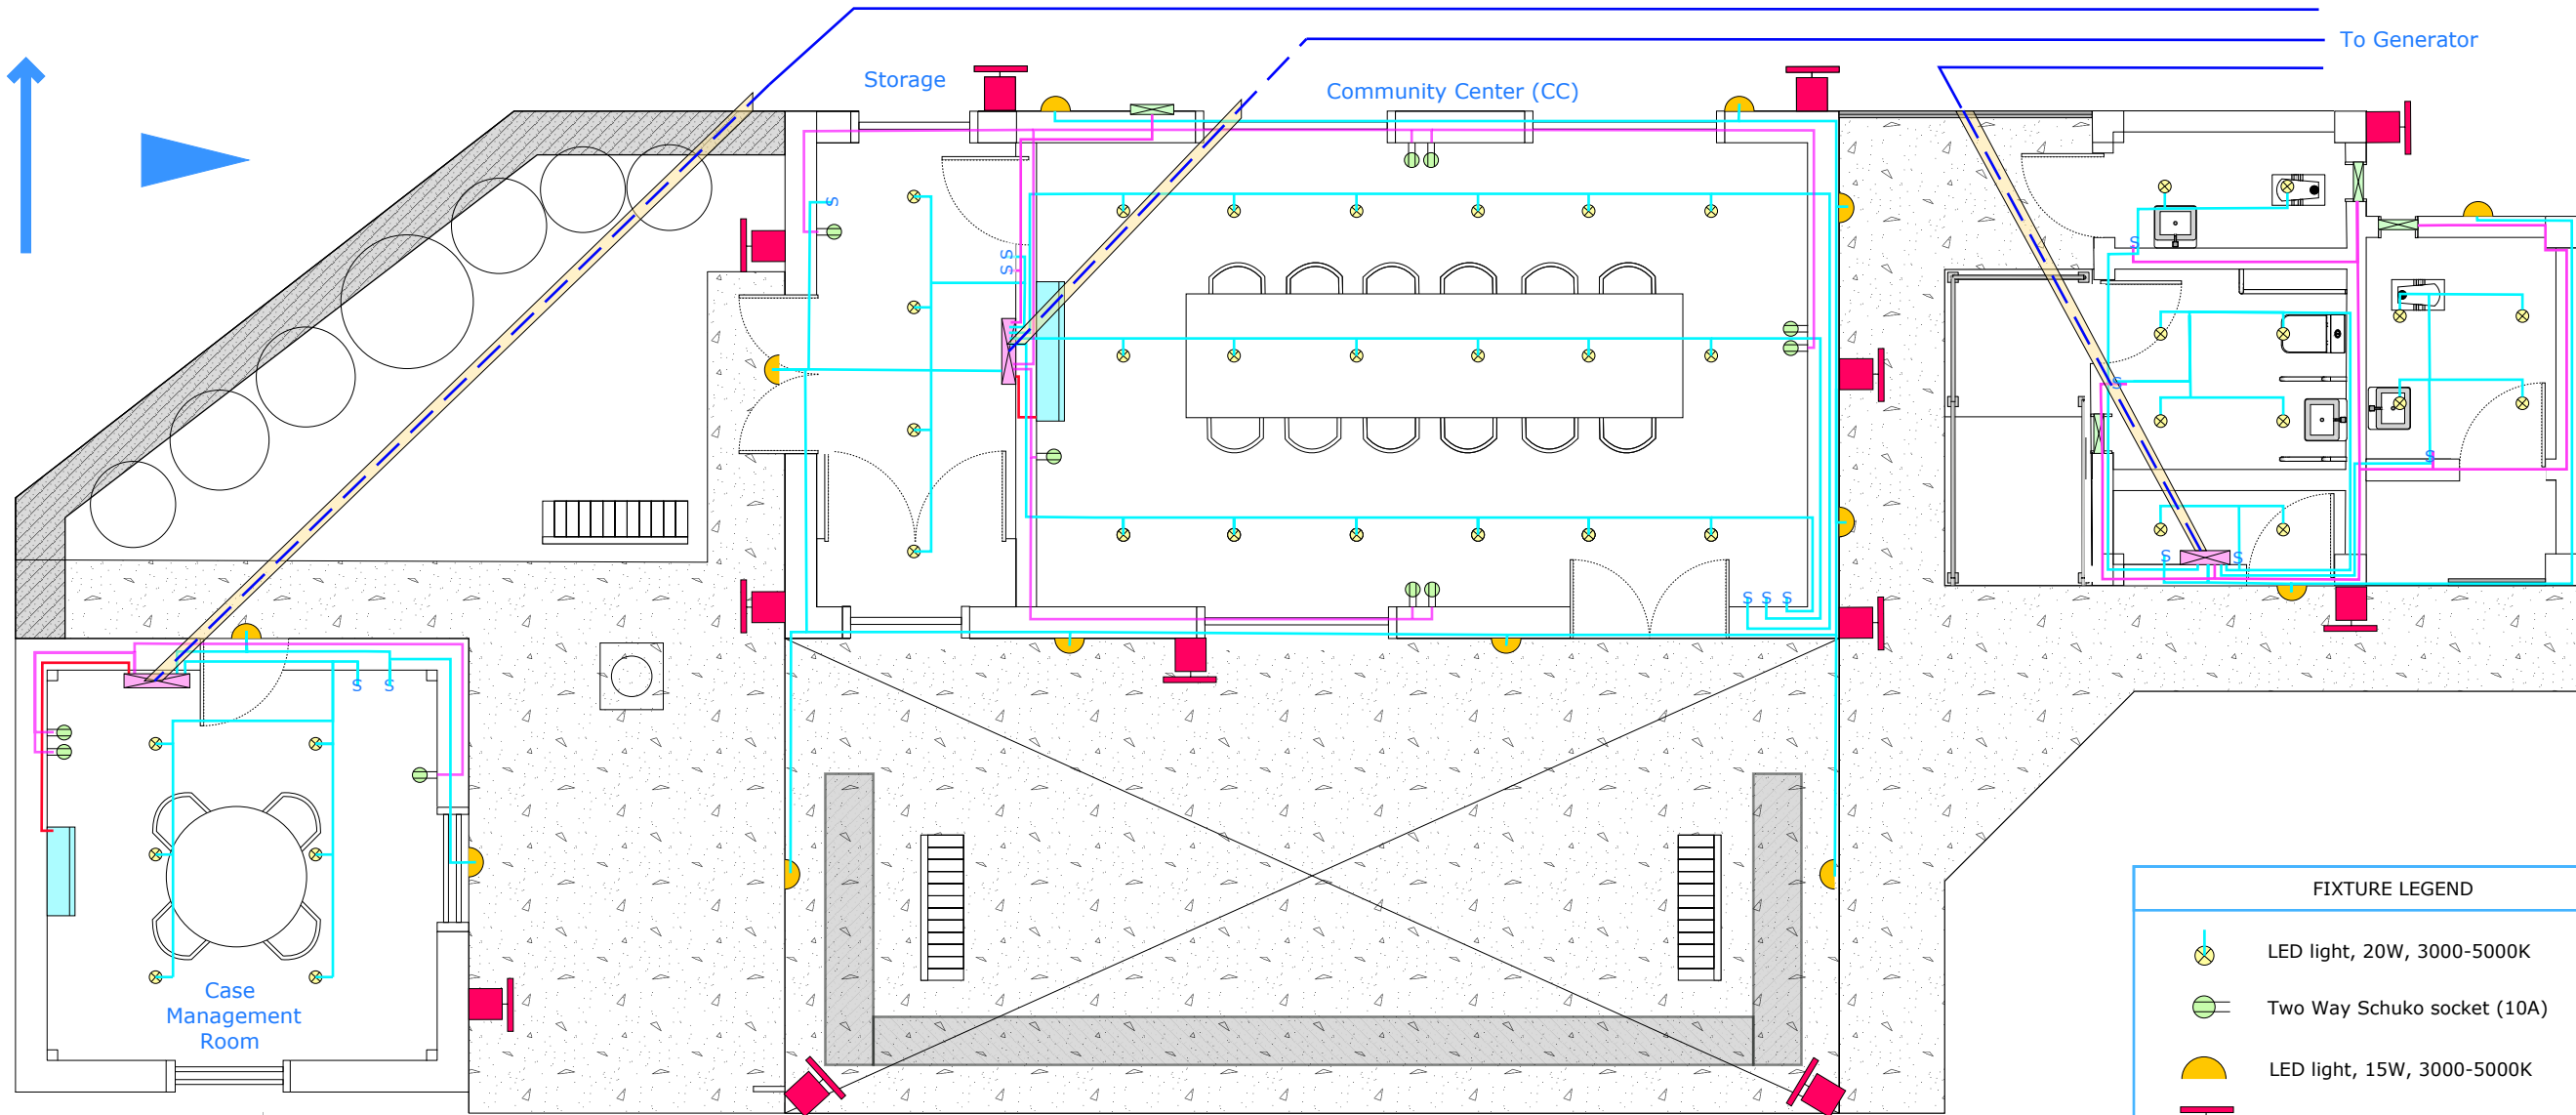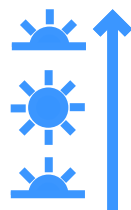

01 ELECTRICAL PLAN
E SCALE: 1:70

CABLE LEGEND	
—	In-wall or in ceiling cable (1.5x2mm ²)
—	In-wall or in ceiling cable (2x4mm ²)
—	In-wall or in ceiling cable (2x2.5mm ²)
—	Buried cable Cu, PVC, NYA (4x6mm ²)

FIXTURE LEGEND	
	LED light, 20W, 3000-5000K
	Two Way Schuko socket (10A)
	LED light, 15W, 3000-5000K
	Solar Flood light, 400W, 3000-6000K
	Interior Distribution Panel (in-wall)
	24000 BTU Split AC.
	12000 BTU Split AC.
	Exhaust Fan, 15 Inch
	In-Concrete 4" UPVC Pipe

02 INFRASTRUCTURAL SPACEING
E NOT TO SCALE

BLUMONT INC.

SHEET TITLE: ELECTRICAL POWER PLAN

SCALE: 1:70

RELATED SHEETS: 1

BLUEPRINT TITLE: COMMUNITY CENTER COMPOUND

DESIGN BY: Omar Ali

REVISIONS: 1


BLUEPRINT CODE: MEFA_2025_CCC

CONTRACT NO: SYRIA-TA-2024-XXXX


APPROVED BY: Ibrahim A. Ahmed

DATE: Aug, 11, 2025

A
10

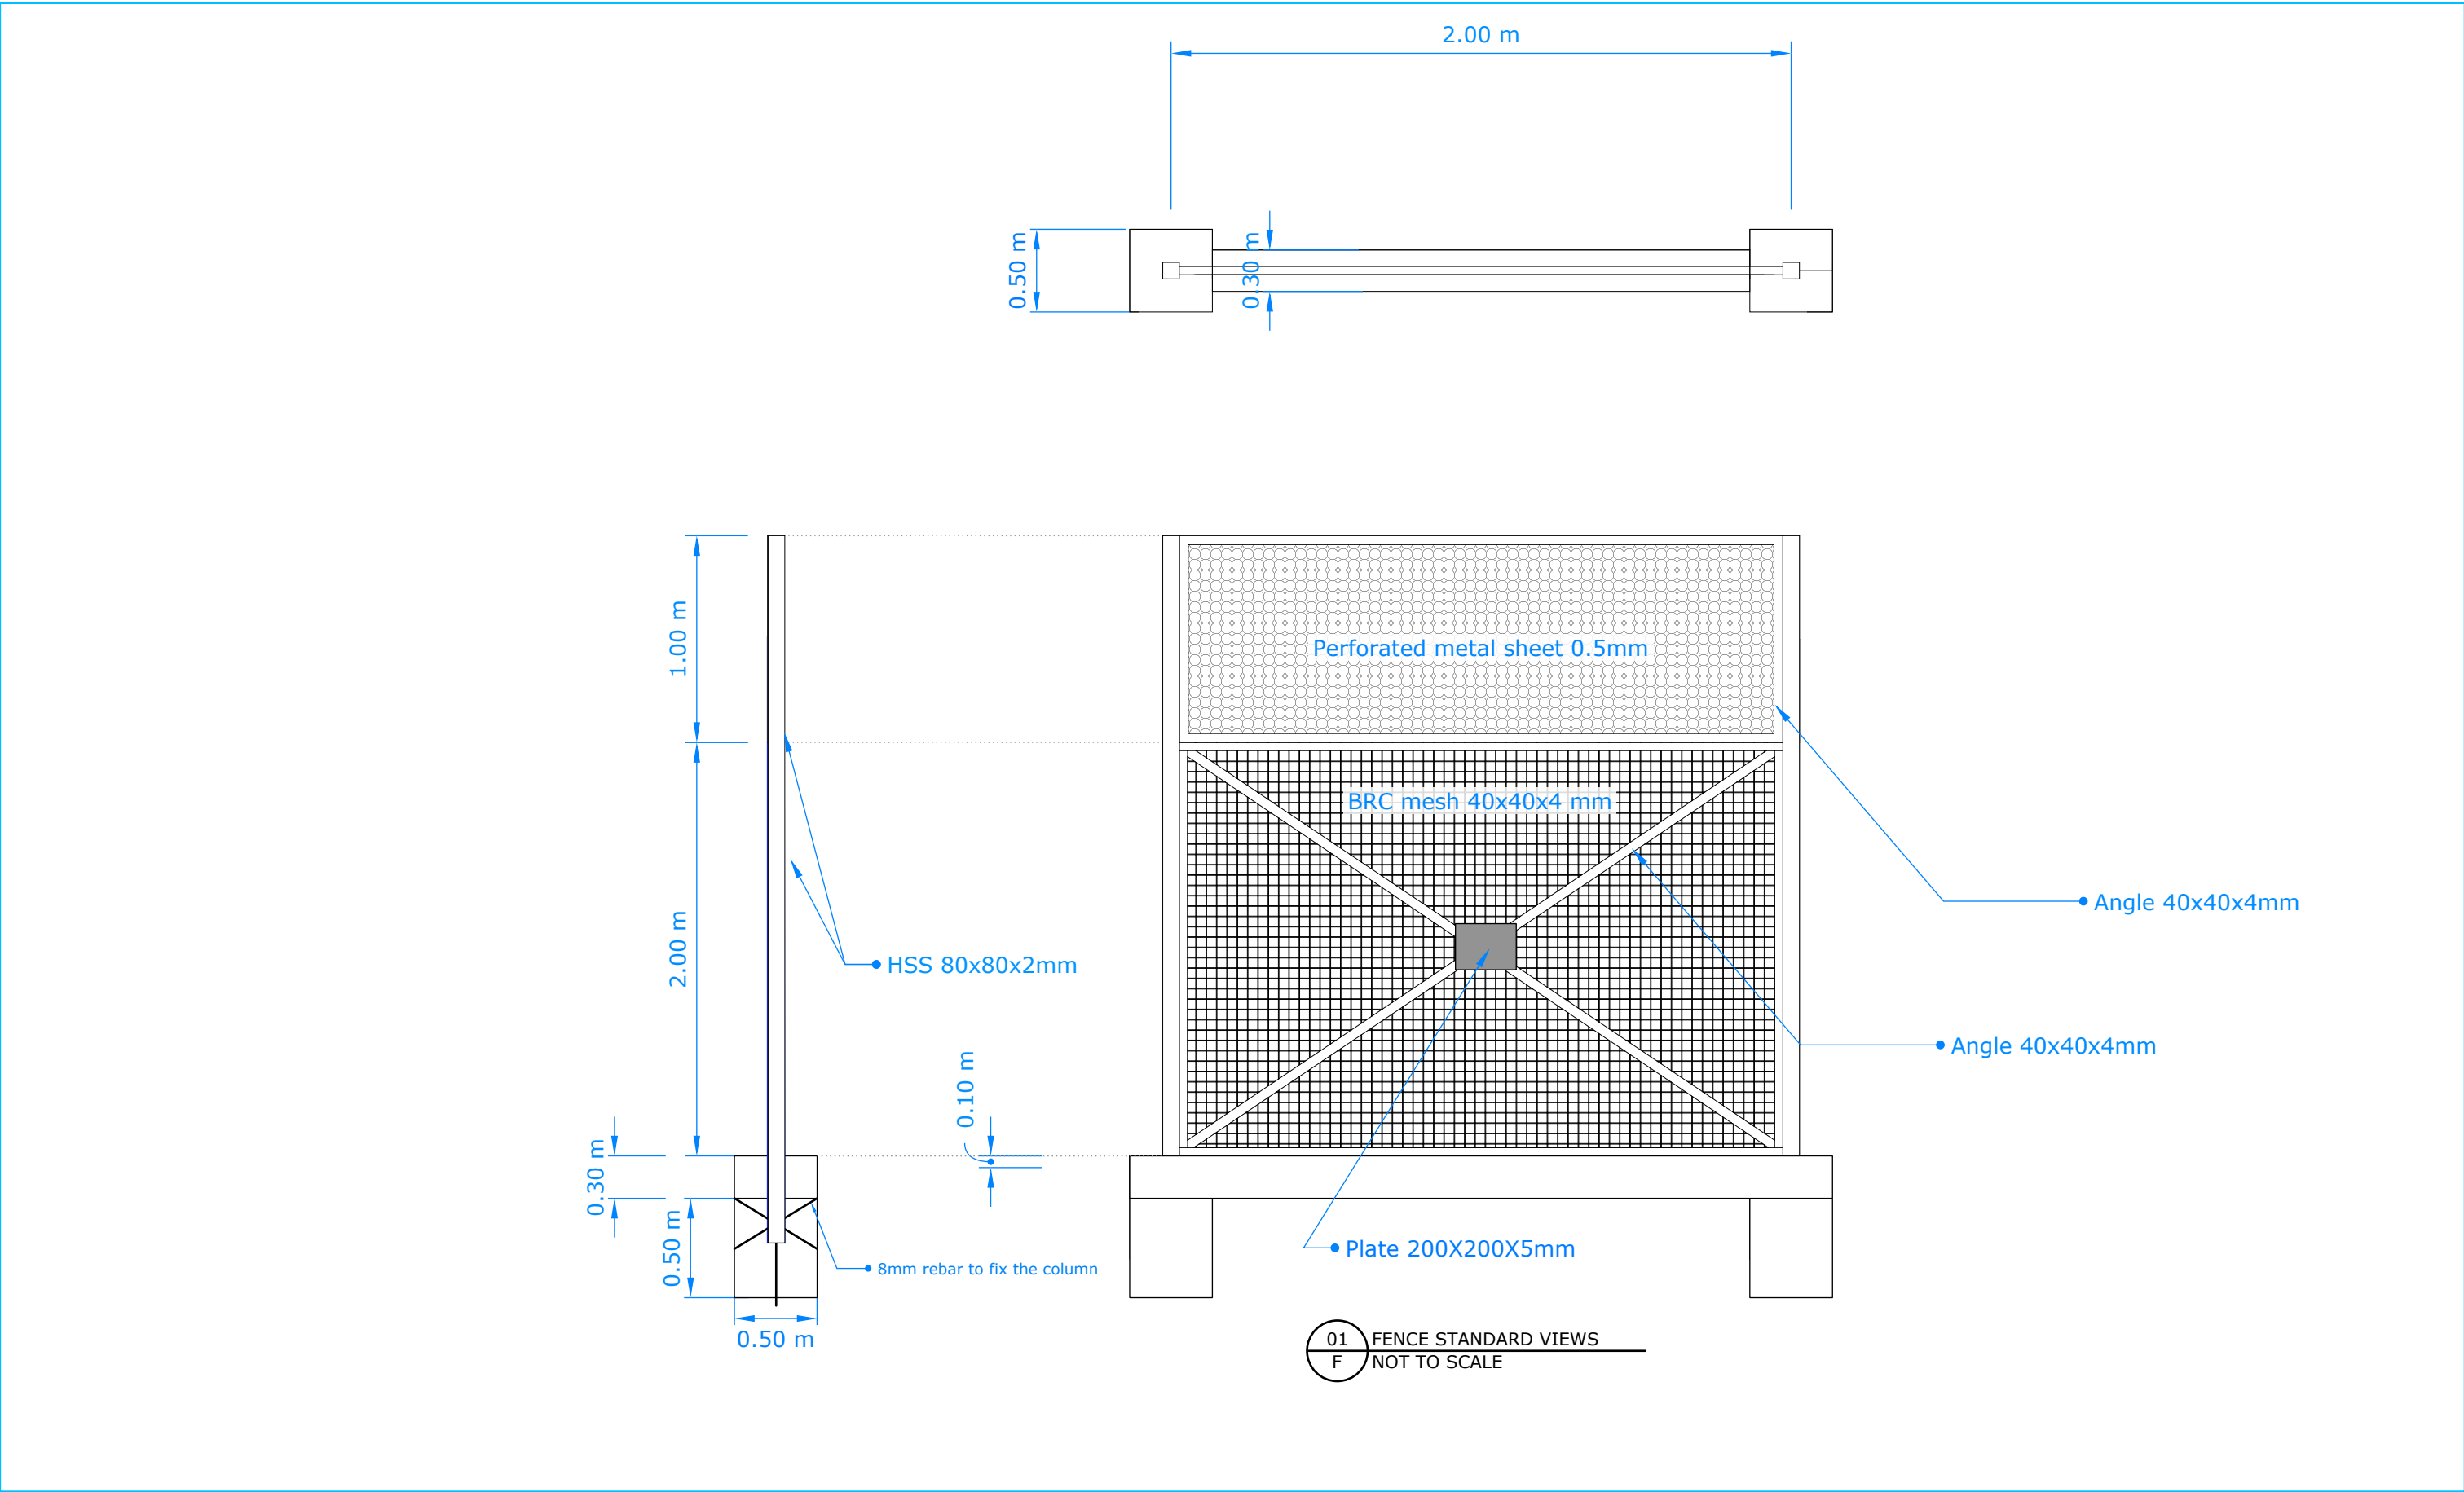

BLUMONT INC.	SHEET TITLE: FENCE DETAILS		NOT TO SCALE	RELATED SHEETS: 1
	BLUEPRINT TITLE: COMMUNITY CENTER COMPOUND		DESIGN BY: Omar Ali	REVISIONS: 1
	BLUEPRINT CODE: MEFA_2025_CCC	CONTRACT NO: SYRIA-TA-2024-XXXX	APPROVED BY: Ibrahim A. Ahmed	DATE: Aug, 11, 2025

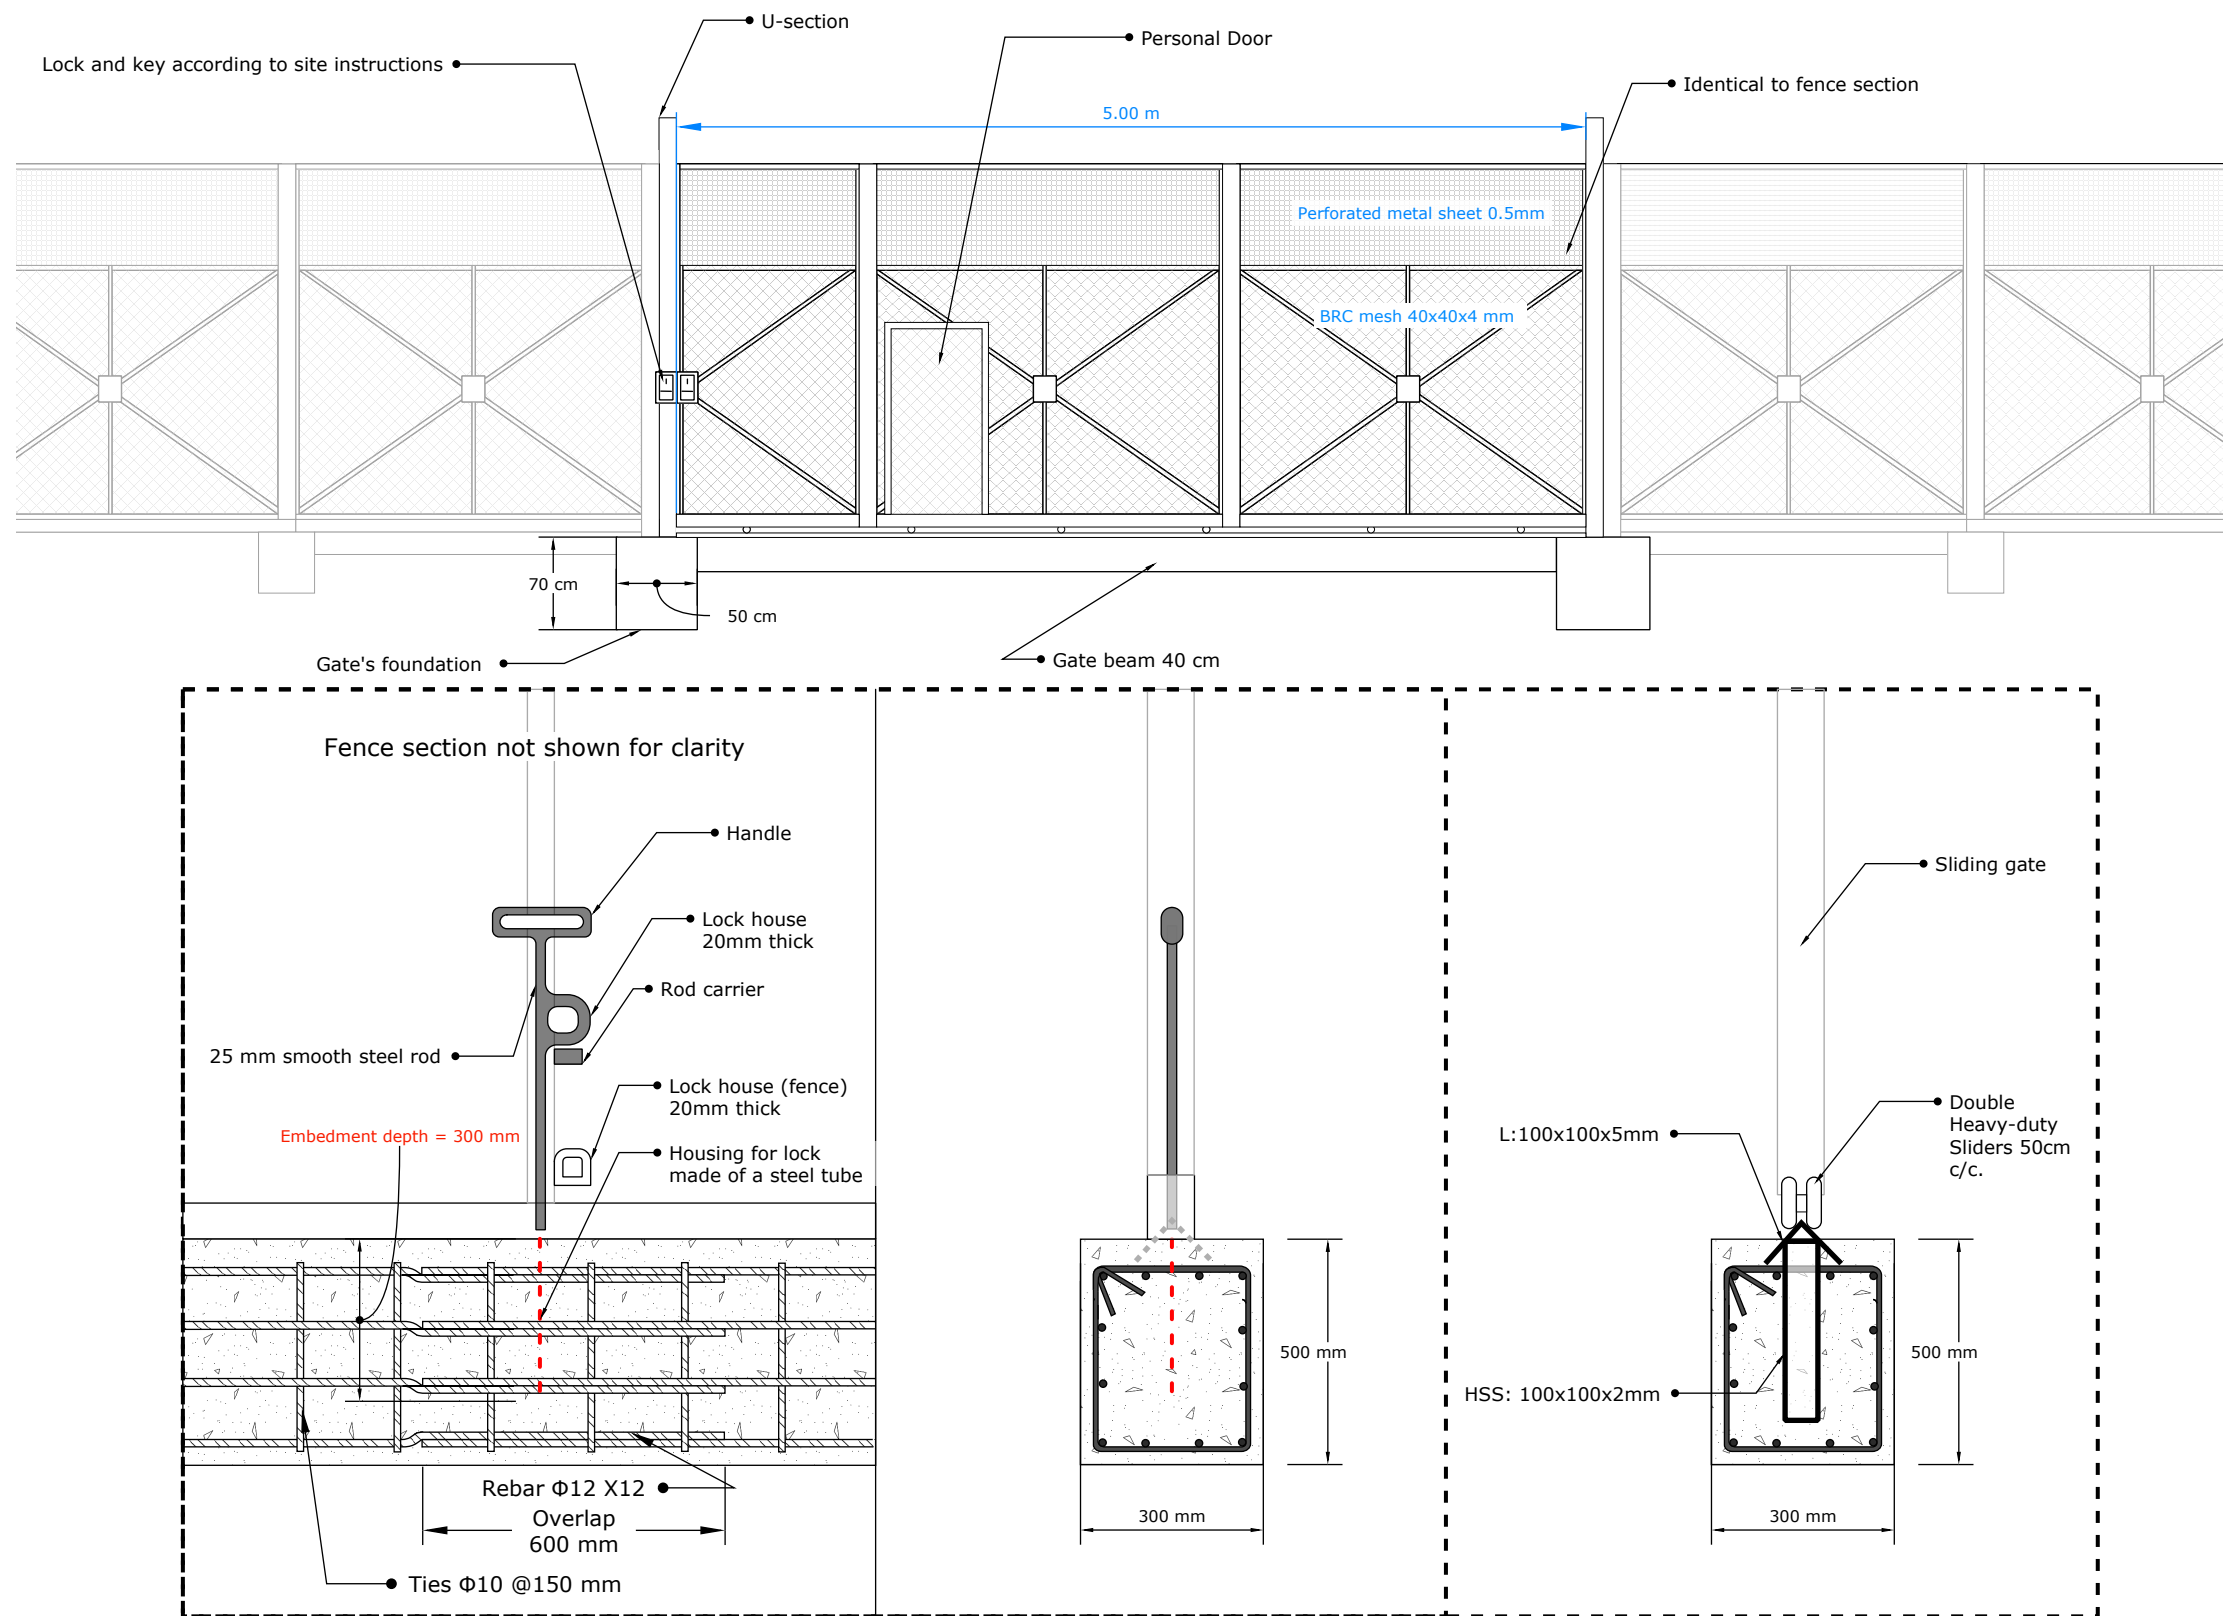

02 GATE DETAILS
F NOT TO SCALE

BLUMONT INC.

SHEET TITLE: FENCE GATE

NOT TO SCALE

RELATED SHEETS: 1

BLUEPRINT TITLE: COMMUNITY CENTER COMPOUND

DESIGN BY: Omar Ali

REVISIONS: 1


BLUEPRINT CODE: MEFA_2025_CCC

CONTRACT NO: SYRIA-TA-2024-XXXX


APPROVED BY: Ibrahim A. Ahmed

DATE: Aug, 11, 2025


A
12

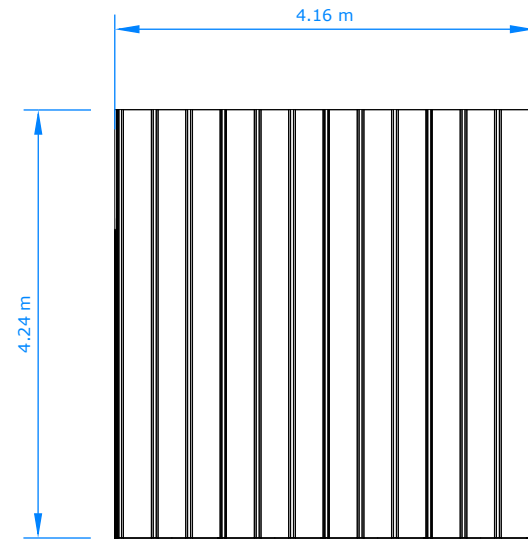


31 TOP VIEW
A SCALE 1:75

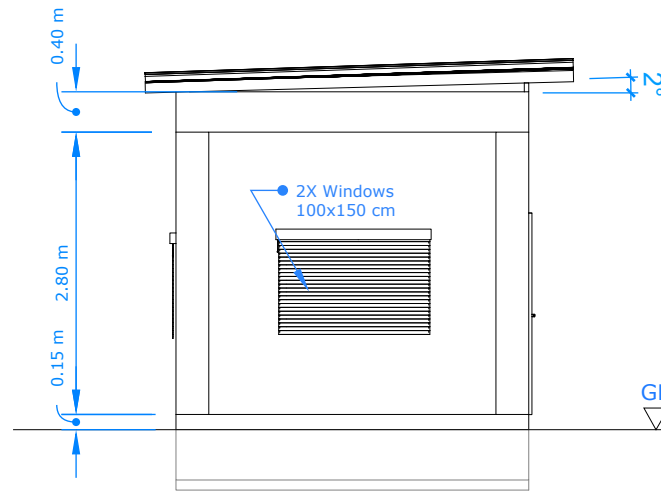


32 SIDE VIEW
A SCALE 1:75

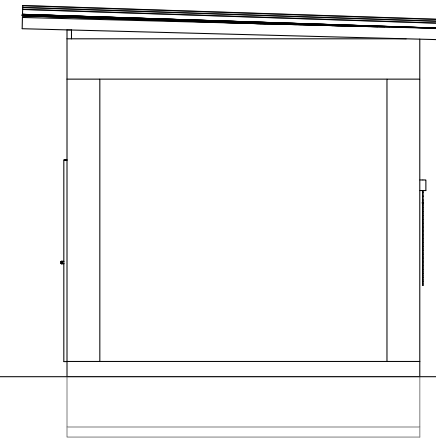


33 SIDE VIEW
A SCALE 1:75

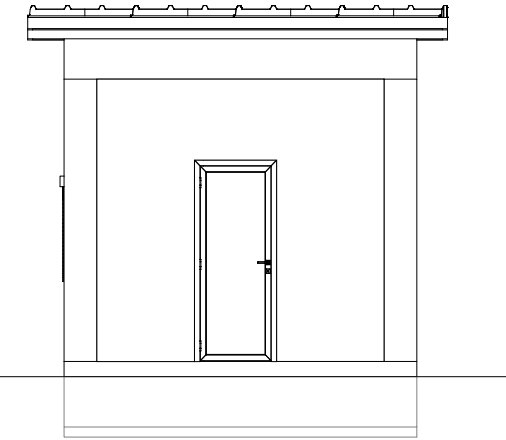


34 FRONT VIEW
A SCALE 1:75

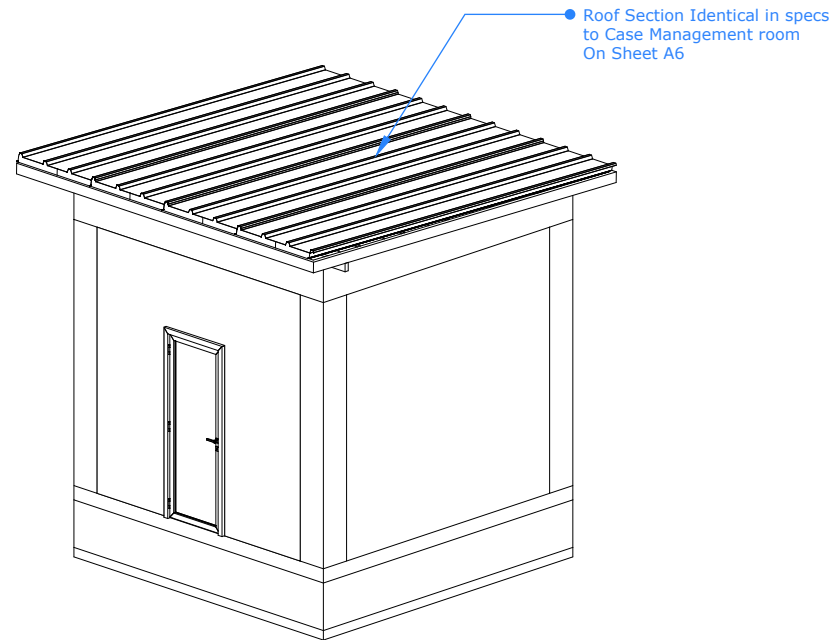

35 ISO VIEW
A SCALE 1:75

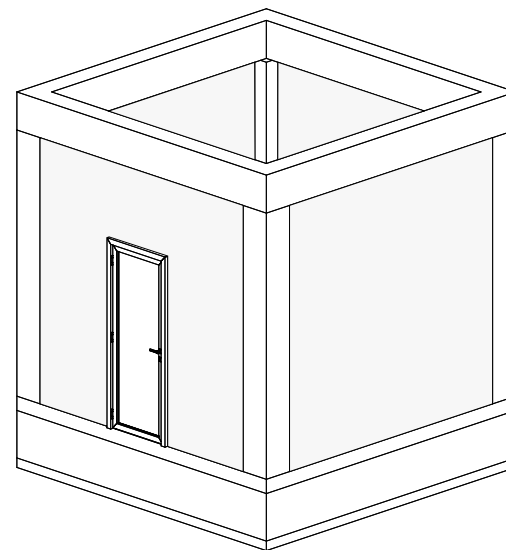

36 NO CIELING ISO
A SCALE 1:75

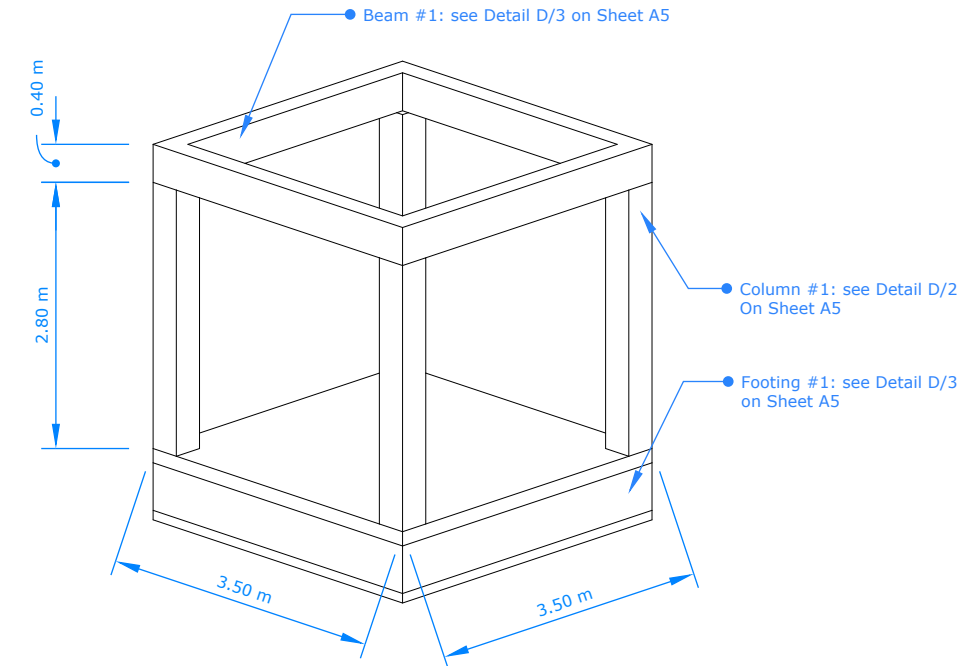

37 SKELETON ISO
A SCALE 1:75

BLUMONT INC.

SHEET TITLE: INFORMATION MANAGEMENT ROOM

TO SCALE 1:75

RELATED SHEETS: 1

BLUEPRINT TITLE: COMMUNITY CENTER COMPOUND

DESIGN BY: Omar Ali

REVISIONS: 1

BLUEPRINT CODE: MEFA_2025_CCC

CONTRACT NO: SYRIA-TA-2024-XXXX

APPROVED BY: Ibrahim A. Ahmed

DATE: Aug, 11, 2025

A
13